
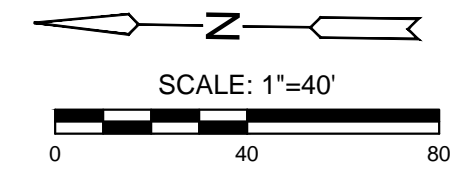


PLOTTED: Wednesday, December 05, 2018 @ 10:15AM


J:\PROJECTS\2018\1301010385_COW BAY COUNTRY DEVELOPMENT\5-CIVIL\CAD\WTRPHASE 3\13386_05_3201.DWG

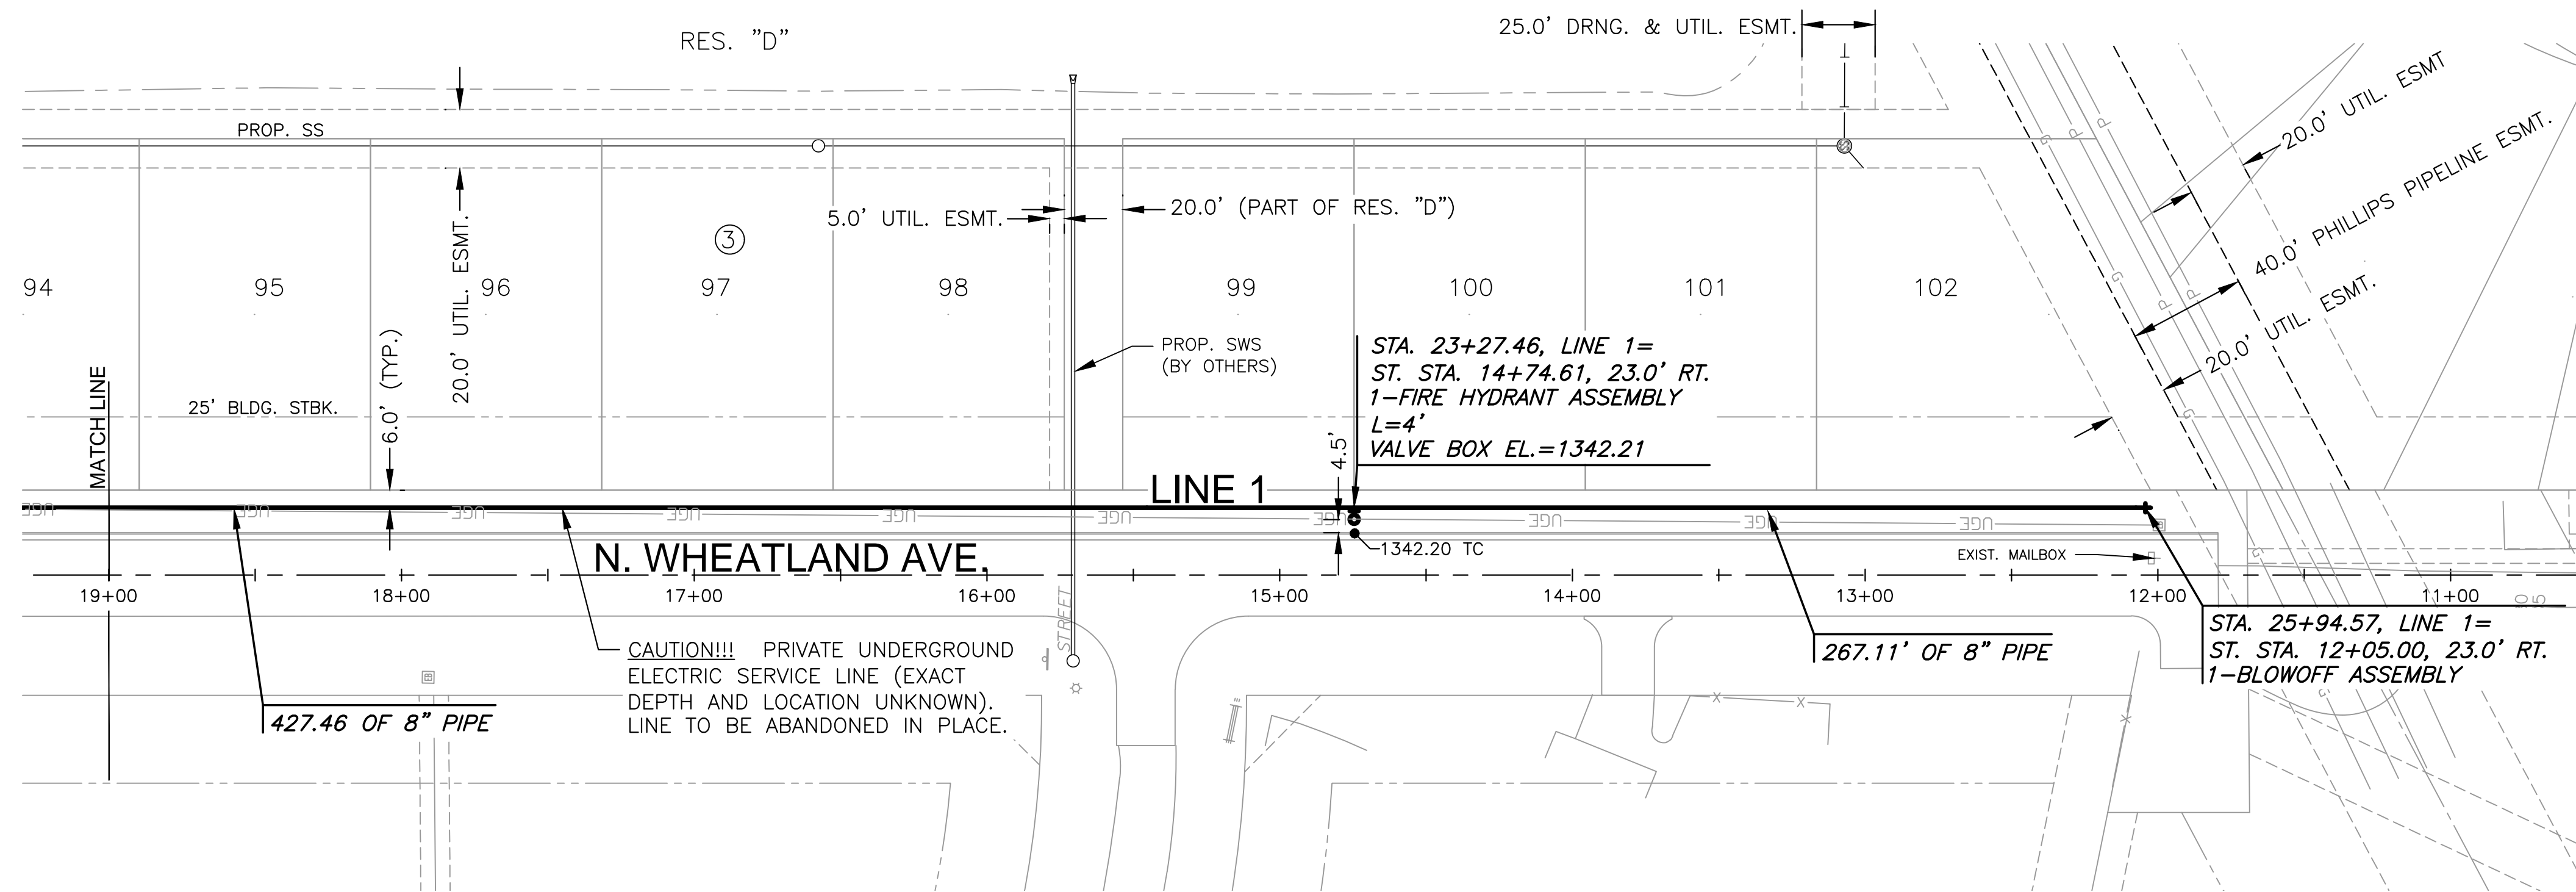

NOTE:
CONTRACTOR TO VERIFY LOCATION AND ELEVATION OF EXISTING WATER LINE AND PRIVATE UNDERGROUND ELECTRIC SERVICE LINE PRIOR TO CONSTRUCTION.

PRIVATE ELECTRIC LINE OWNED BY:
VAL ENERGY (316-263-6688)
COORDINATE WITH TODD ALLAM (316-619-3212)
BEFORE EXPOSING ELECTRIC LINE.

PLAN LINE 1 CONT.
PROFILE LINE 1 CONT.

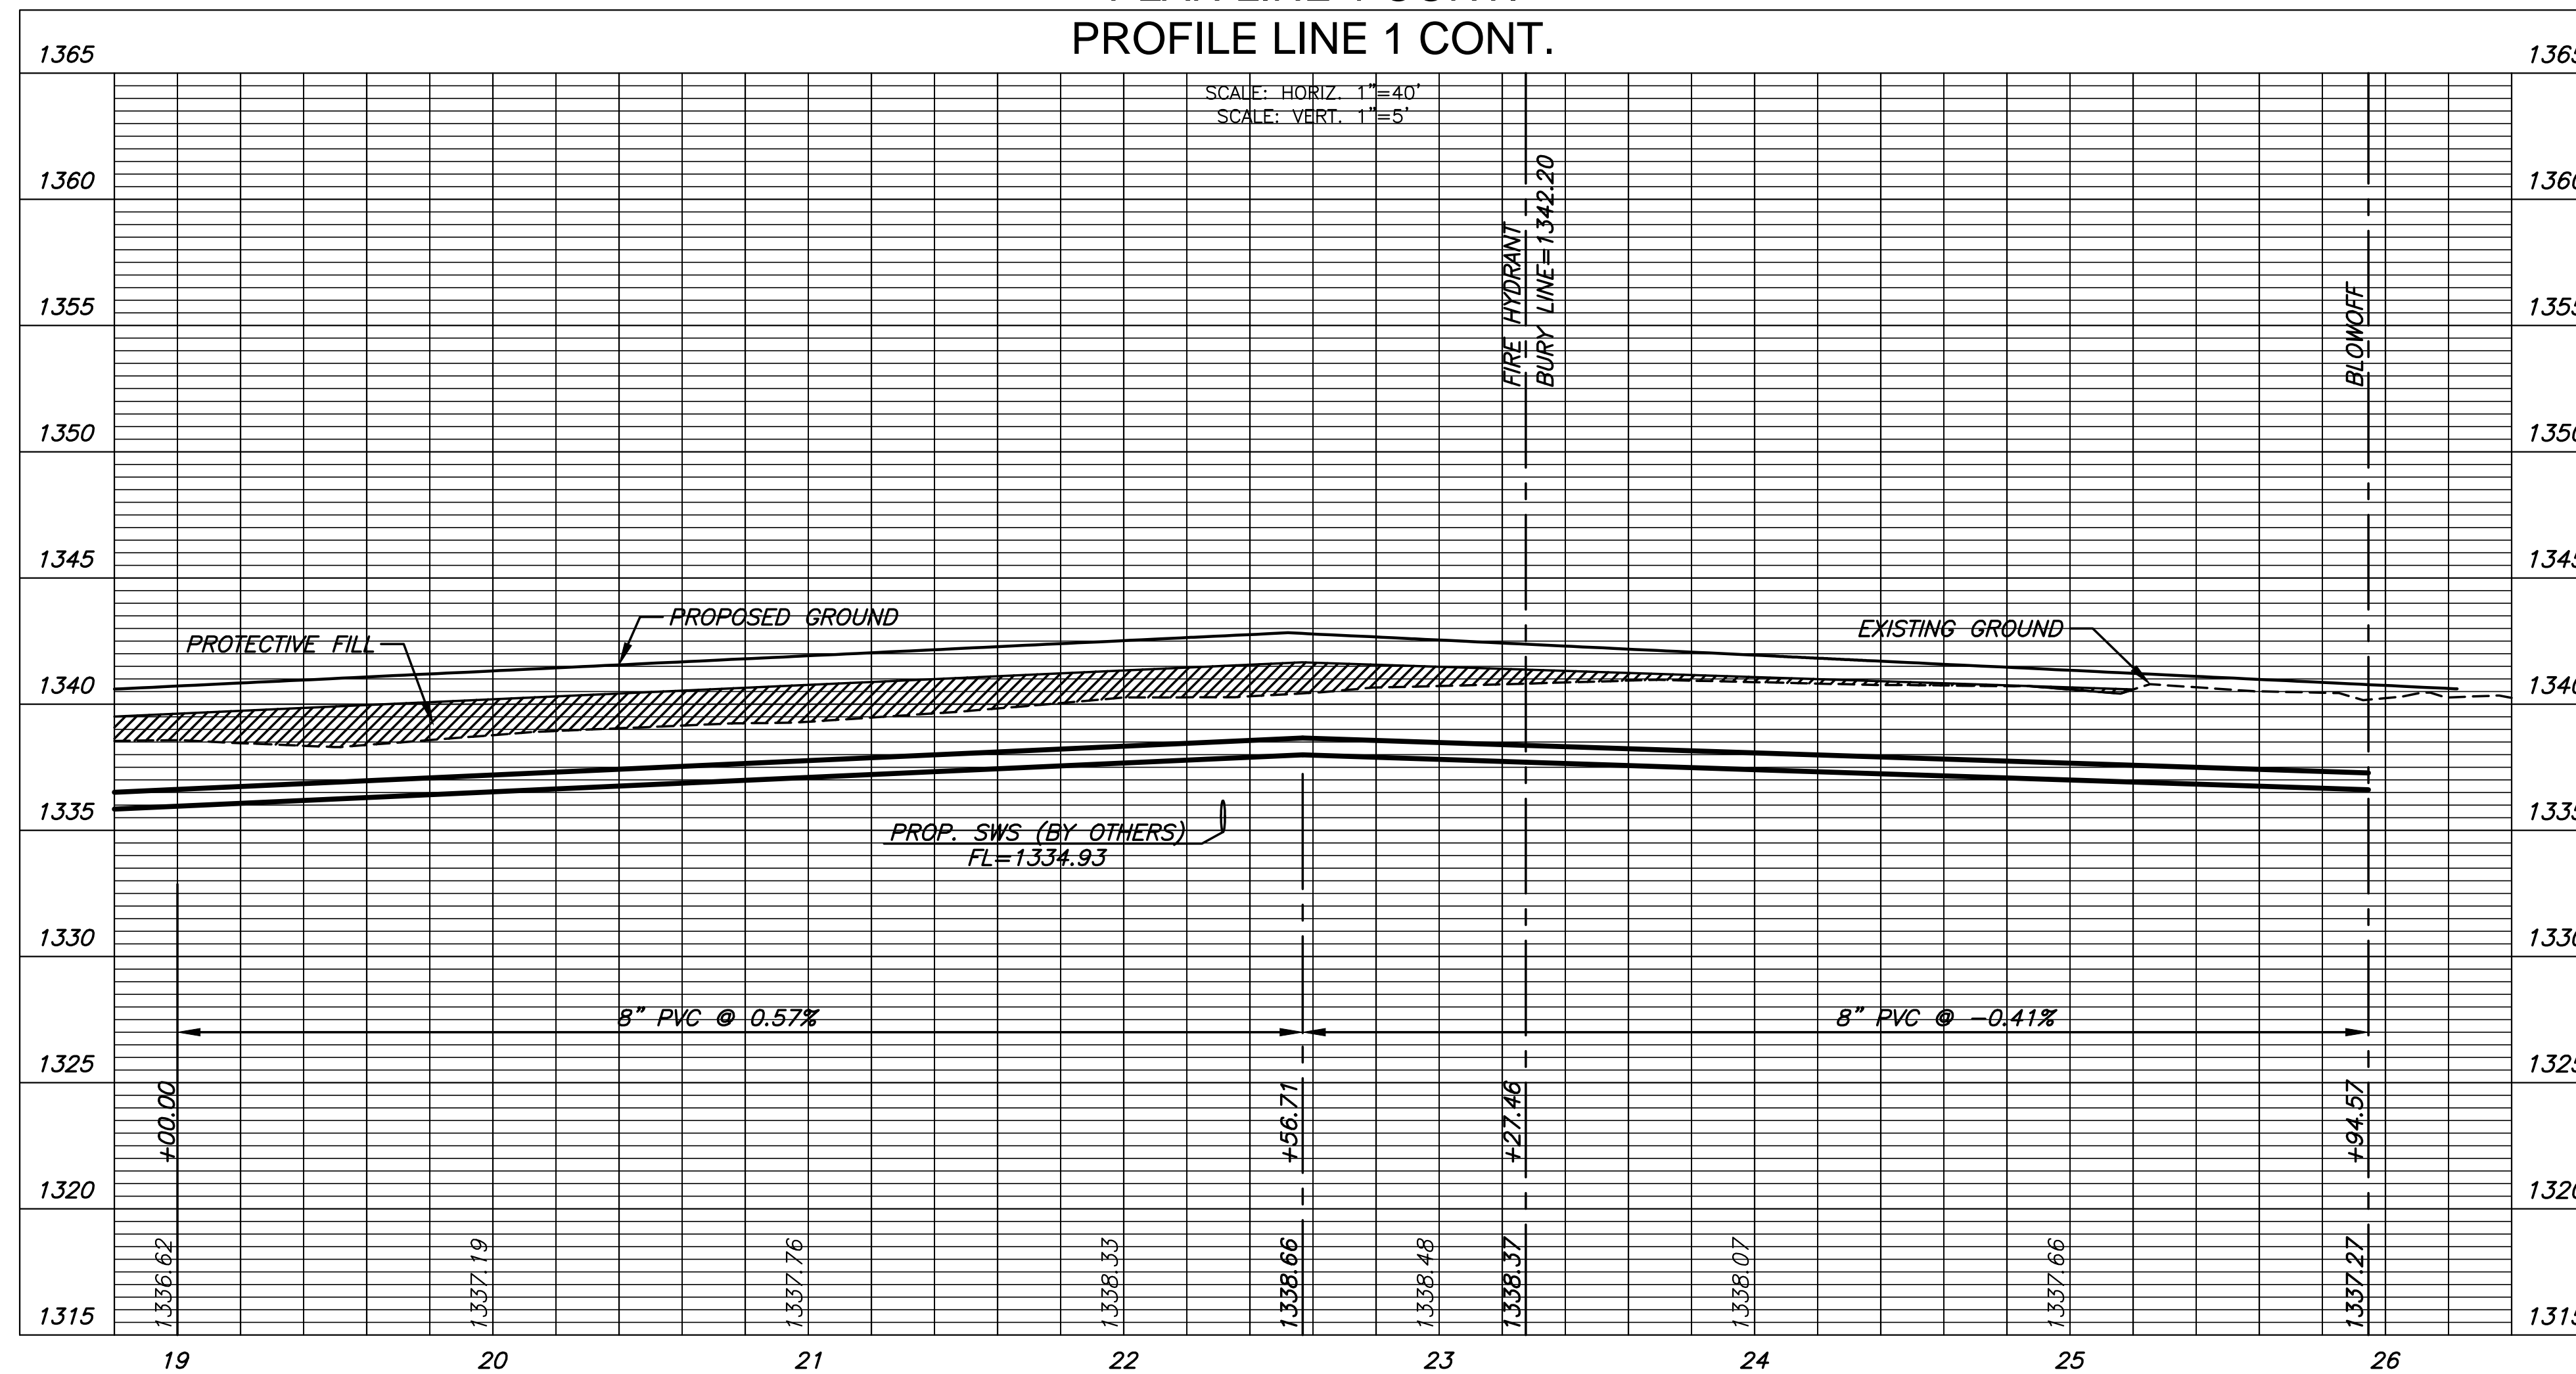

WATER DISTRIBUTION PLANS FOR
BAY COUNTRY ADDITION (PHASE 3)
 WICHITA, KANSAS

©2018 MKEC Engineering All Rights Reserved
 These drawings and their contents, including, but not limited to, all concepts, designs, & ideas are the exclusive property of MKEC Engineering (MKEC), and may not be used or reproduced in any way without the express consent of MKEC.

PLAN AND PROFILE LINE 1 CONT.		
PROJECT NO.	448-90928	
DATE	DEC. 2018	
SCALE	1"=40'	
DESIGNED	DRAWN	CHECKED
GJA	CRM	GJA
NO.	REVISION	DATE
SHEET NO.		
4 OF 11		