


MABCD REVIEWER:

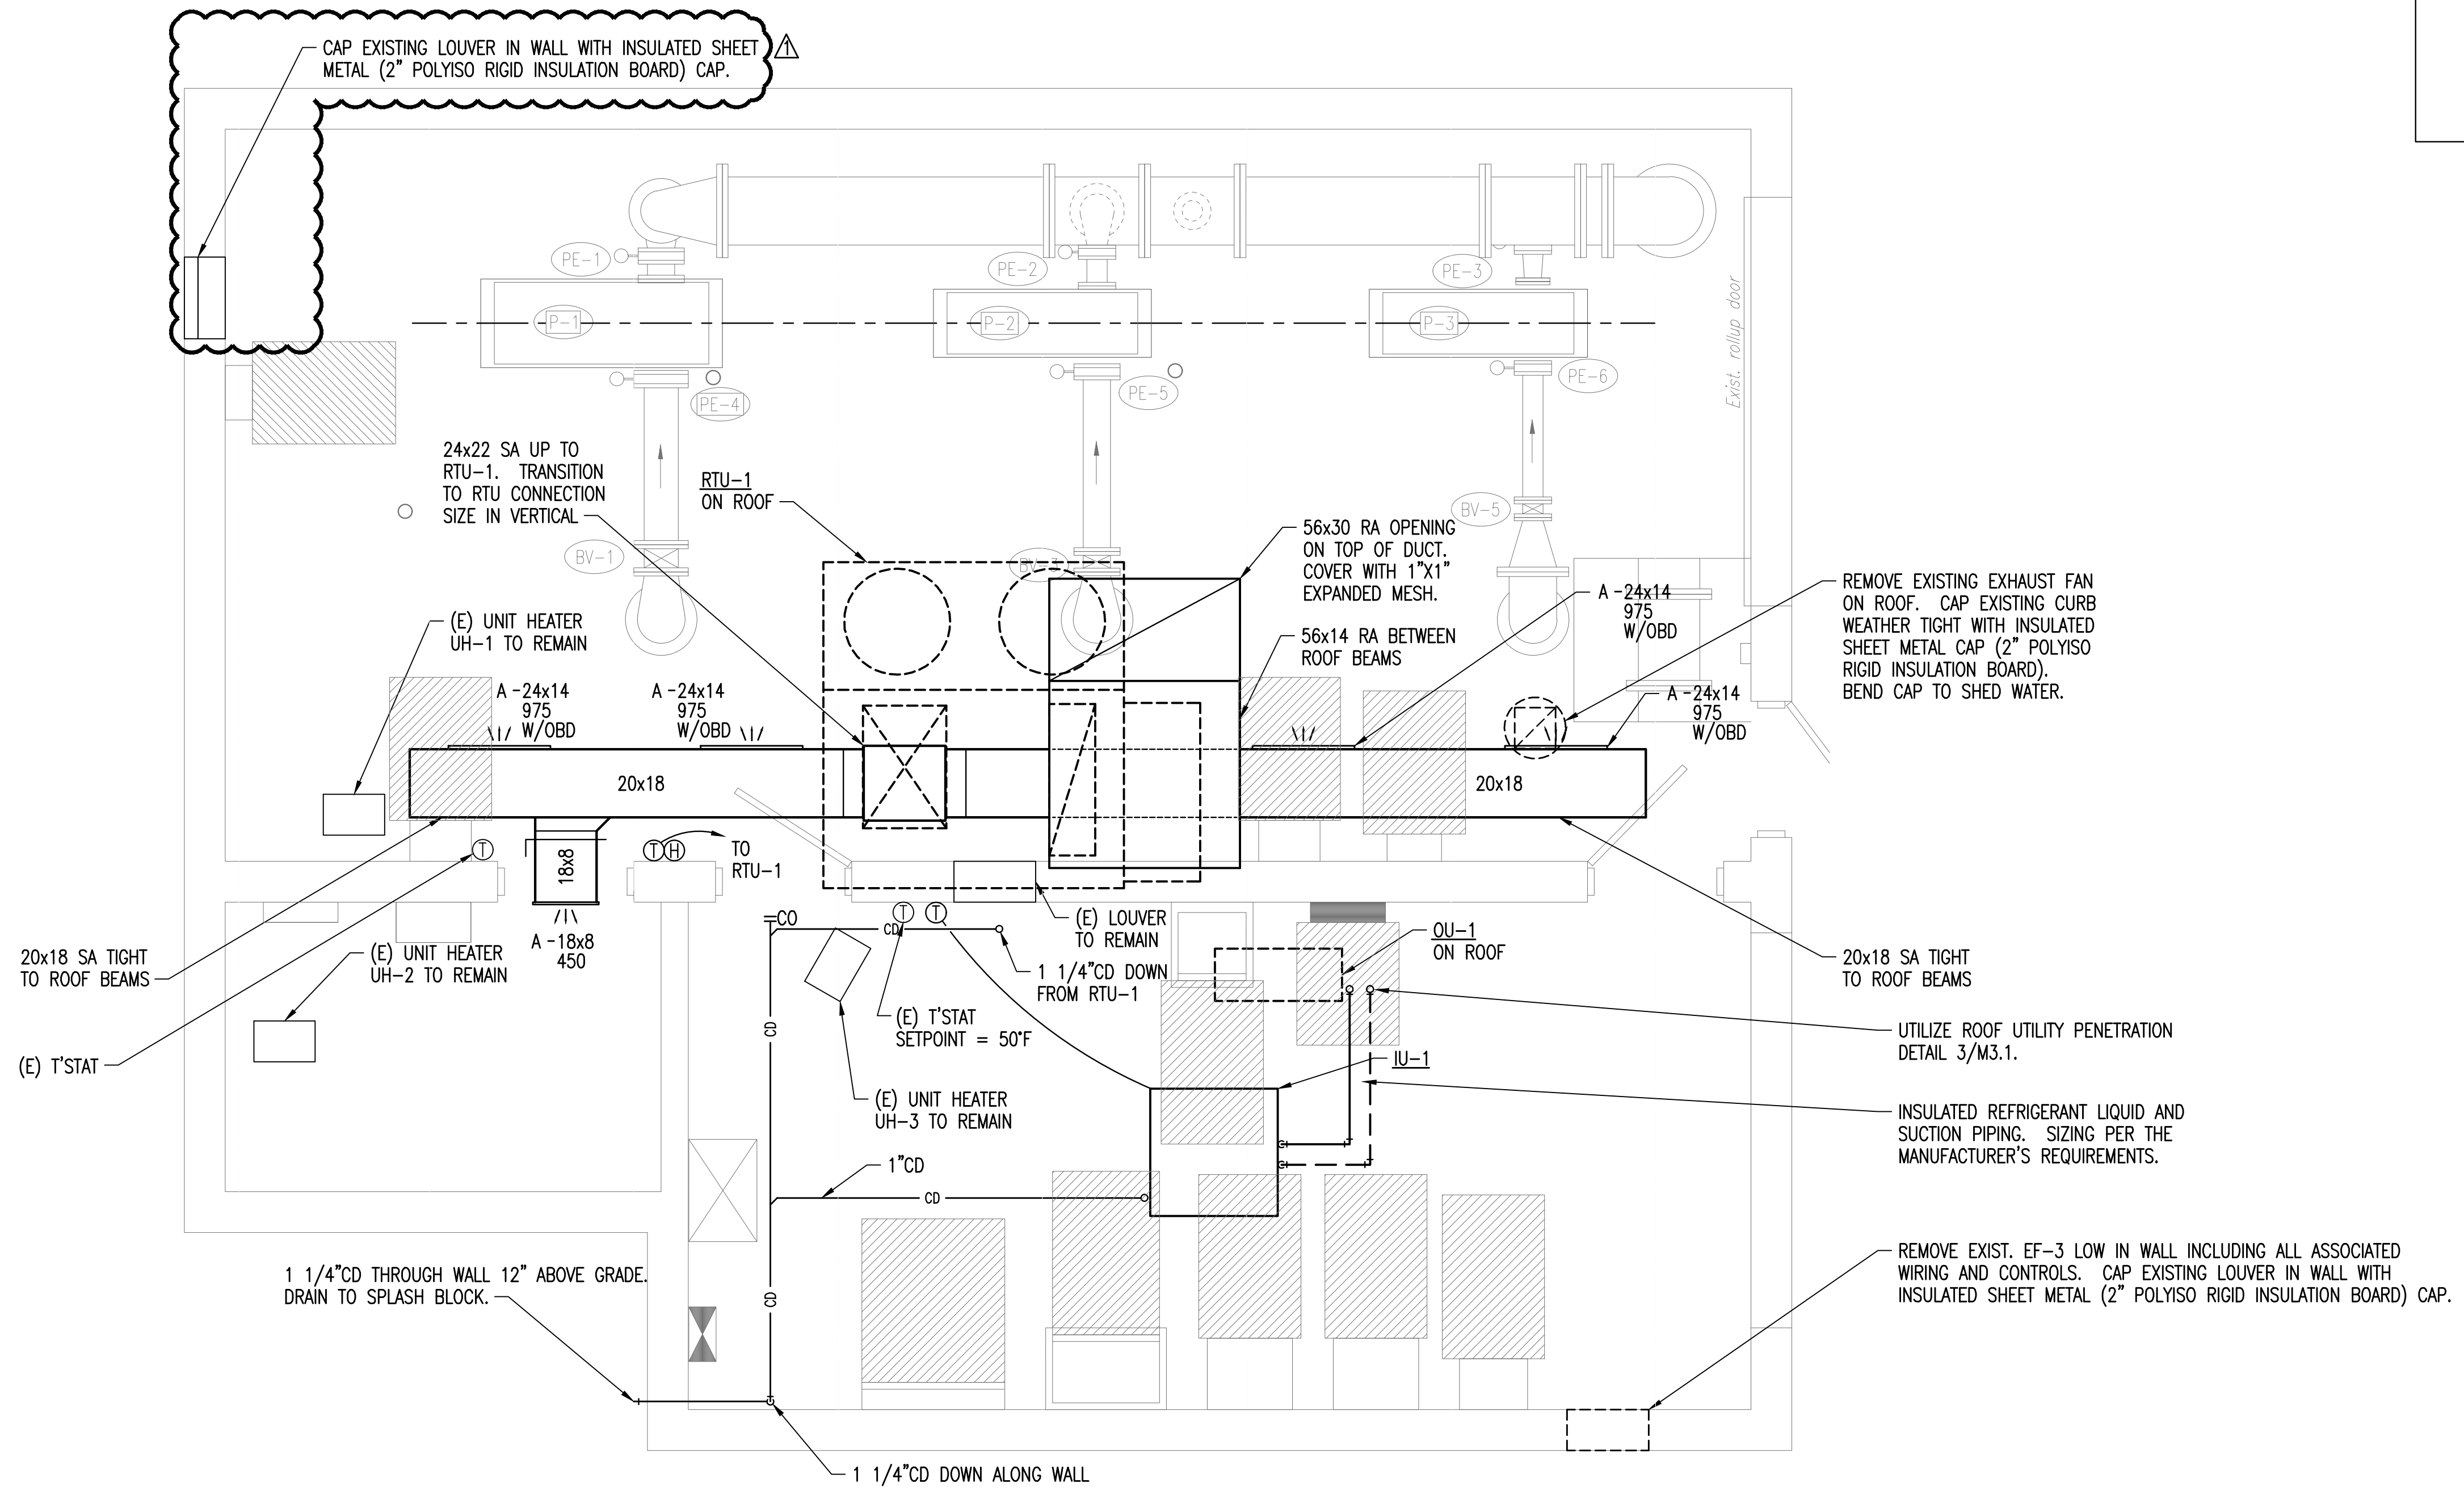

A MECHANICAL FLOOR PLAN

0' 1' 2' 4' 3/8"=1'-0"

Saved: 12-13-2018 12:10:42 AM by BWC
 Plot Scale: 1:1 04-30-2019 2:30:02 PM by CAL
 U:\Wichita-Civil\2017\170920\000\Mech\Drawings\170920-000 - M2.1 MECHANICAL PLAN

	Issued for Bid		CL	4/30/2019
	No.	Revision	By	Date
CITY OF WICHITA, KANSAS				
MECHANICAL FLOOR PLAN				
37TH STREET BOOSTER PUMP STATION IMPROVEMENTS				
		PROFESSIONAL ENGINEERING CONSULTANTS, P.A. 303 SOUTH TOPEKA WICHITA, KS 67202 316-262-2891 www.pec1.com		
Designed by BWC	Job No. 34-170920-000	Sht. M2.1 of 3		
Drawn by BWC	Date: DECEMBER 2018			