



PLAN WATER LINE 3
PROFILE WATER LINE 3

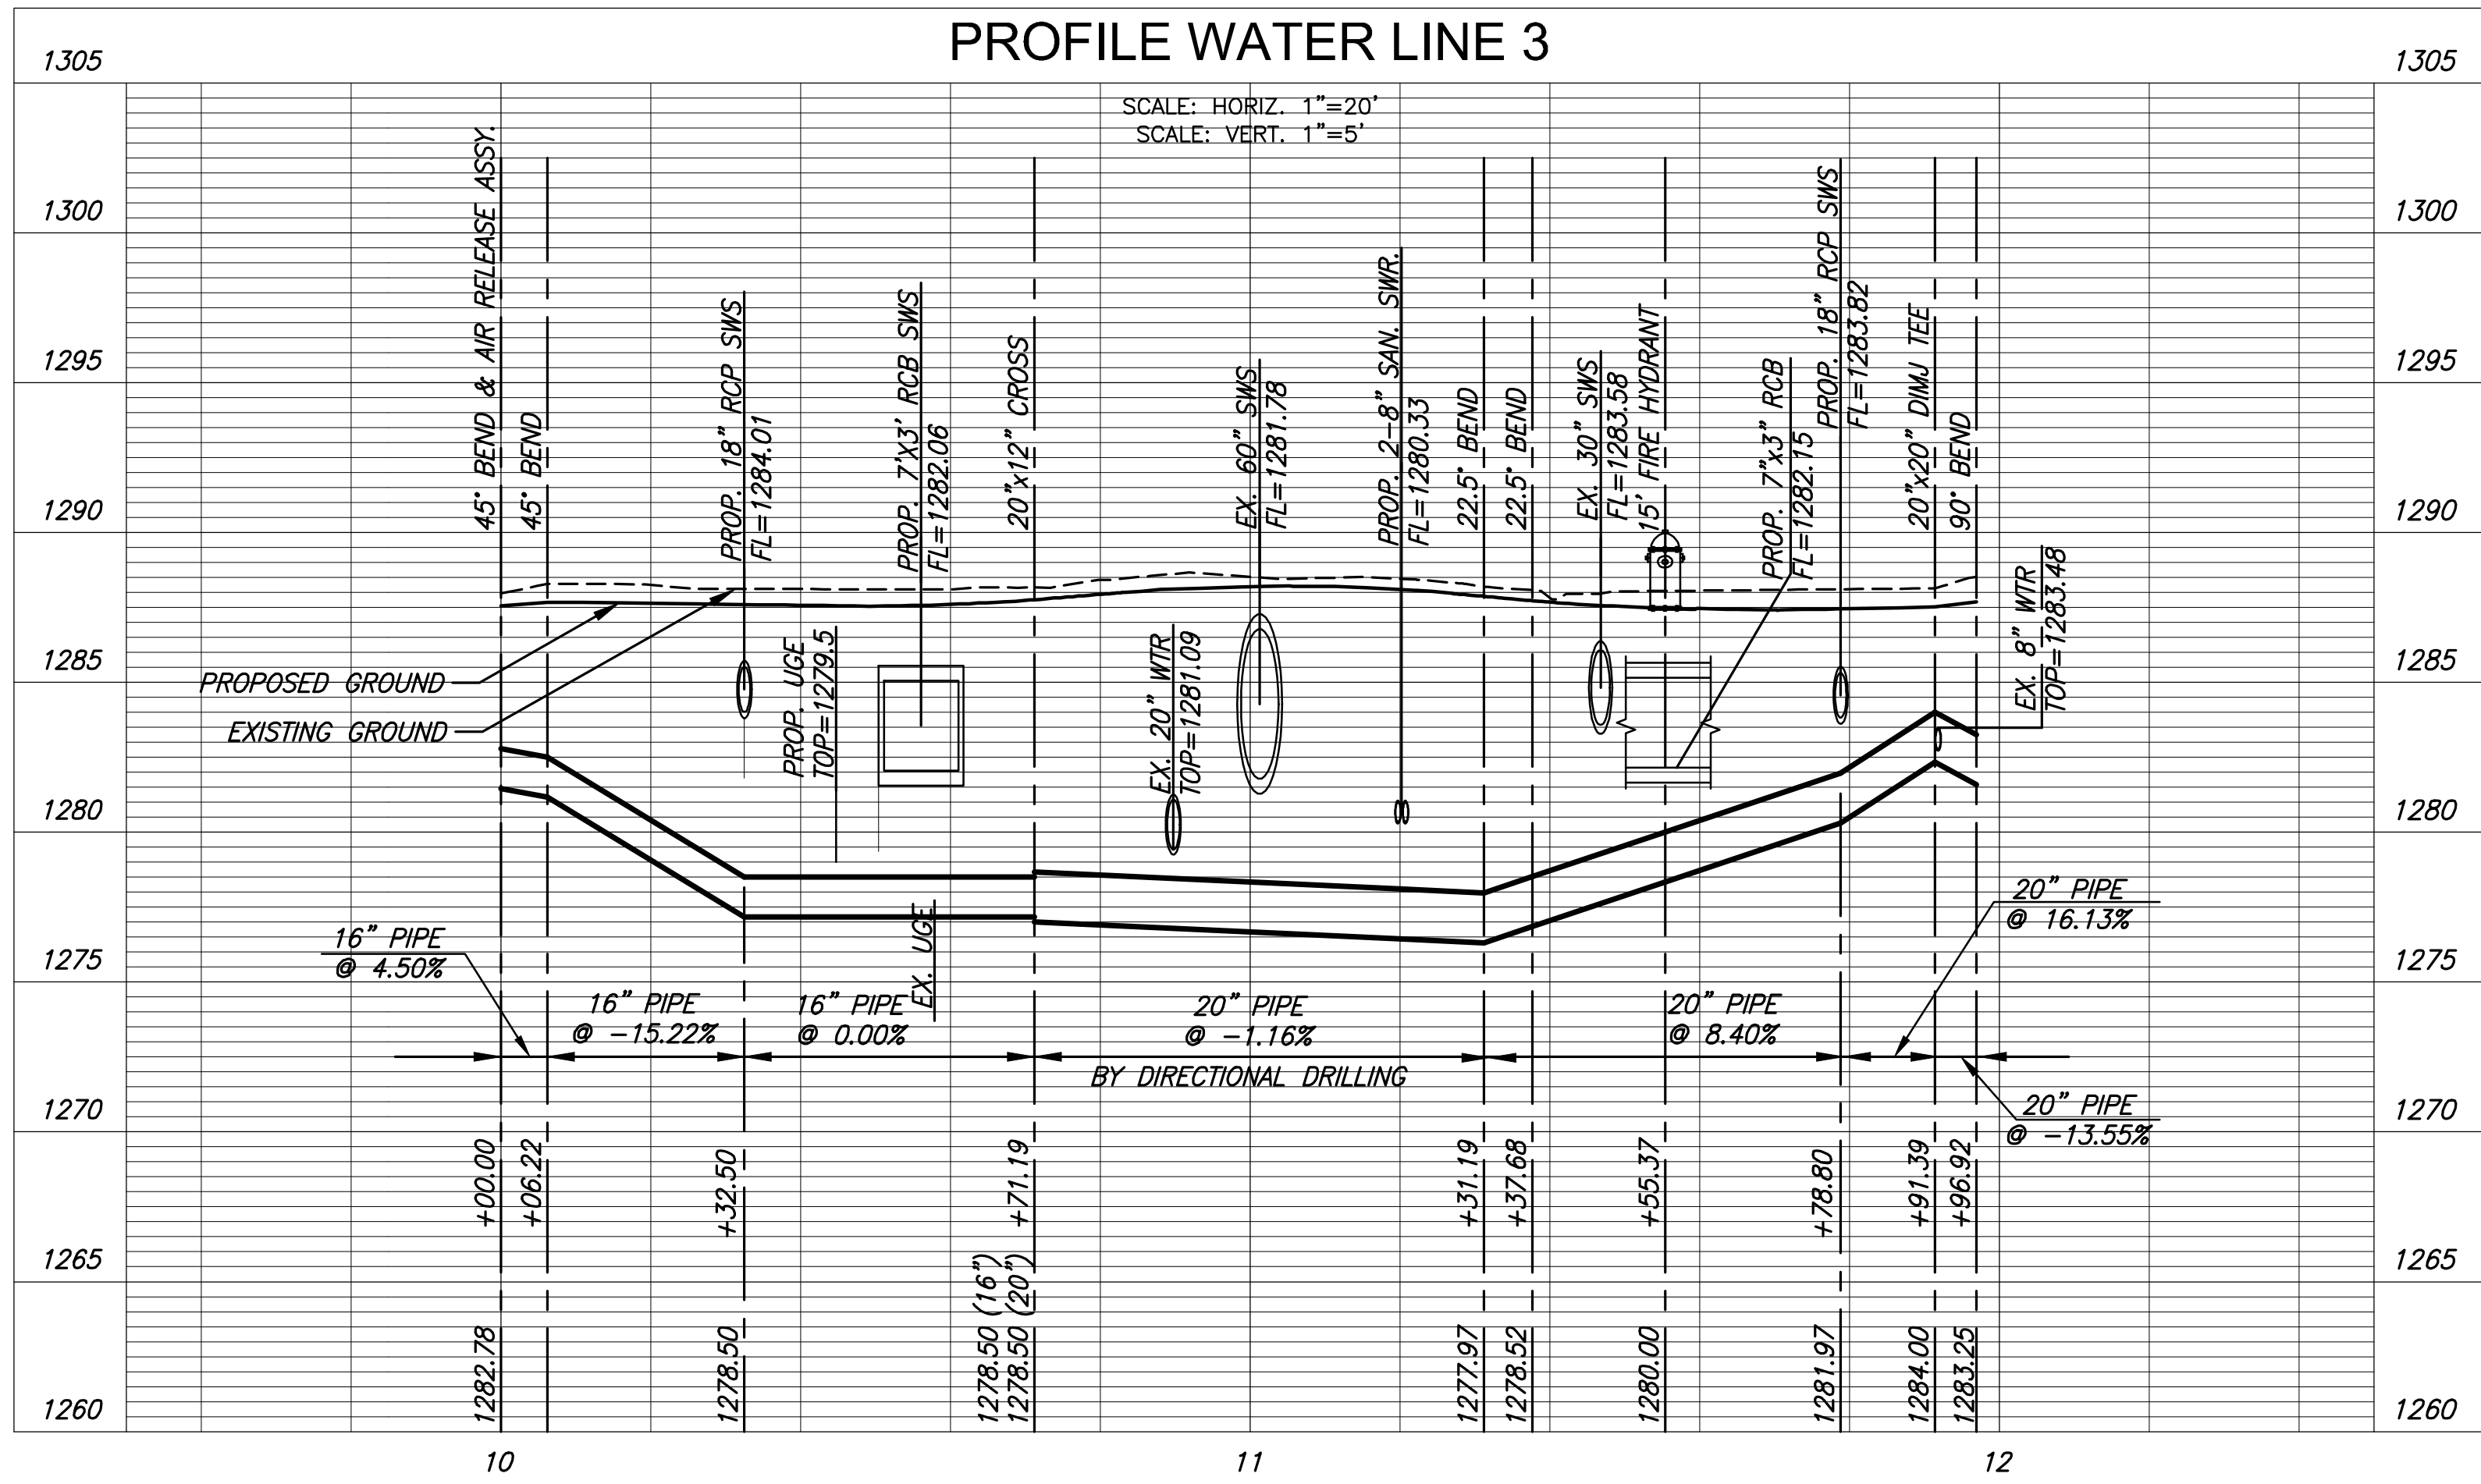

PLAN WATER LINE 4
PROFILE WATER LINE 4

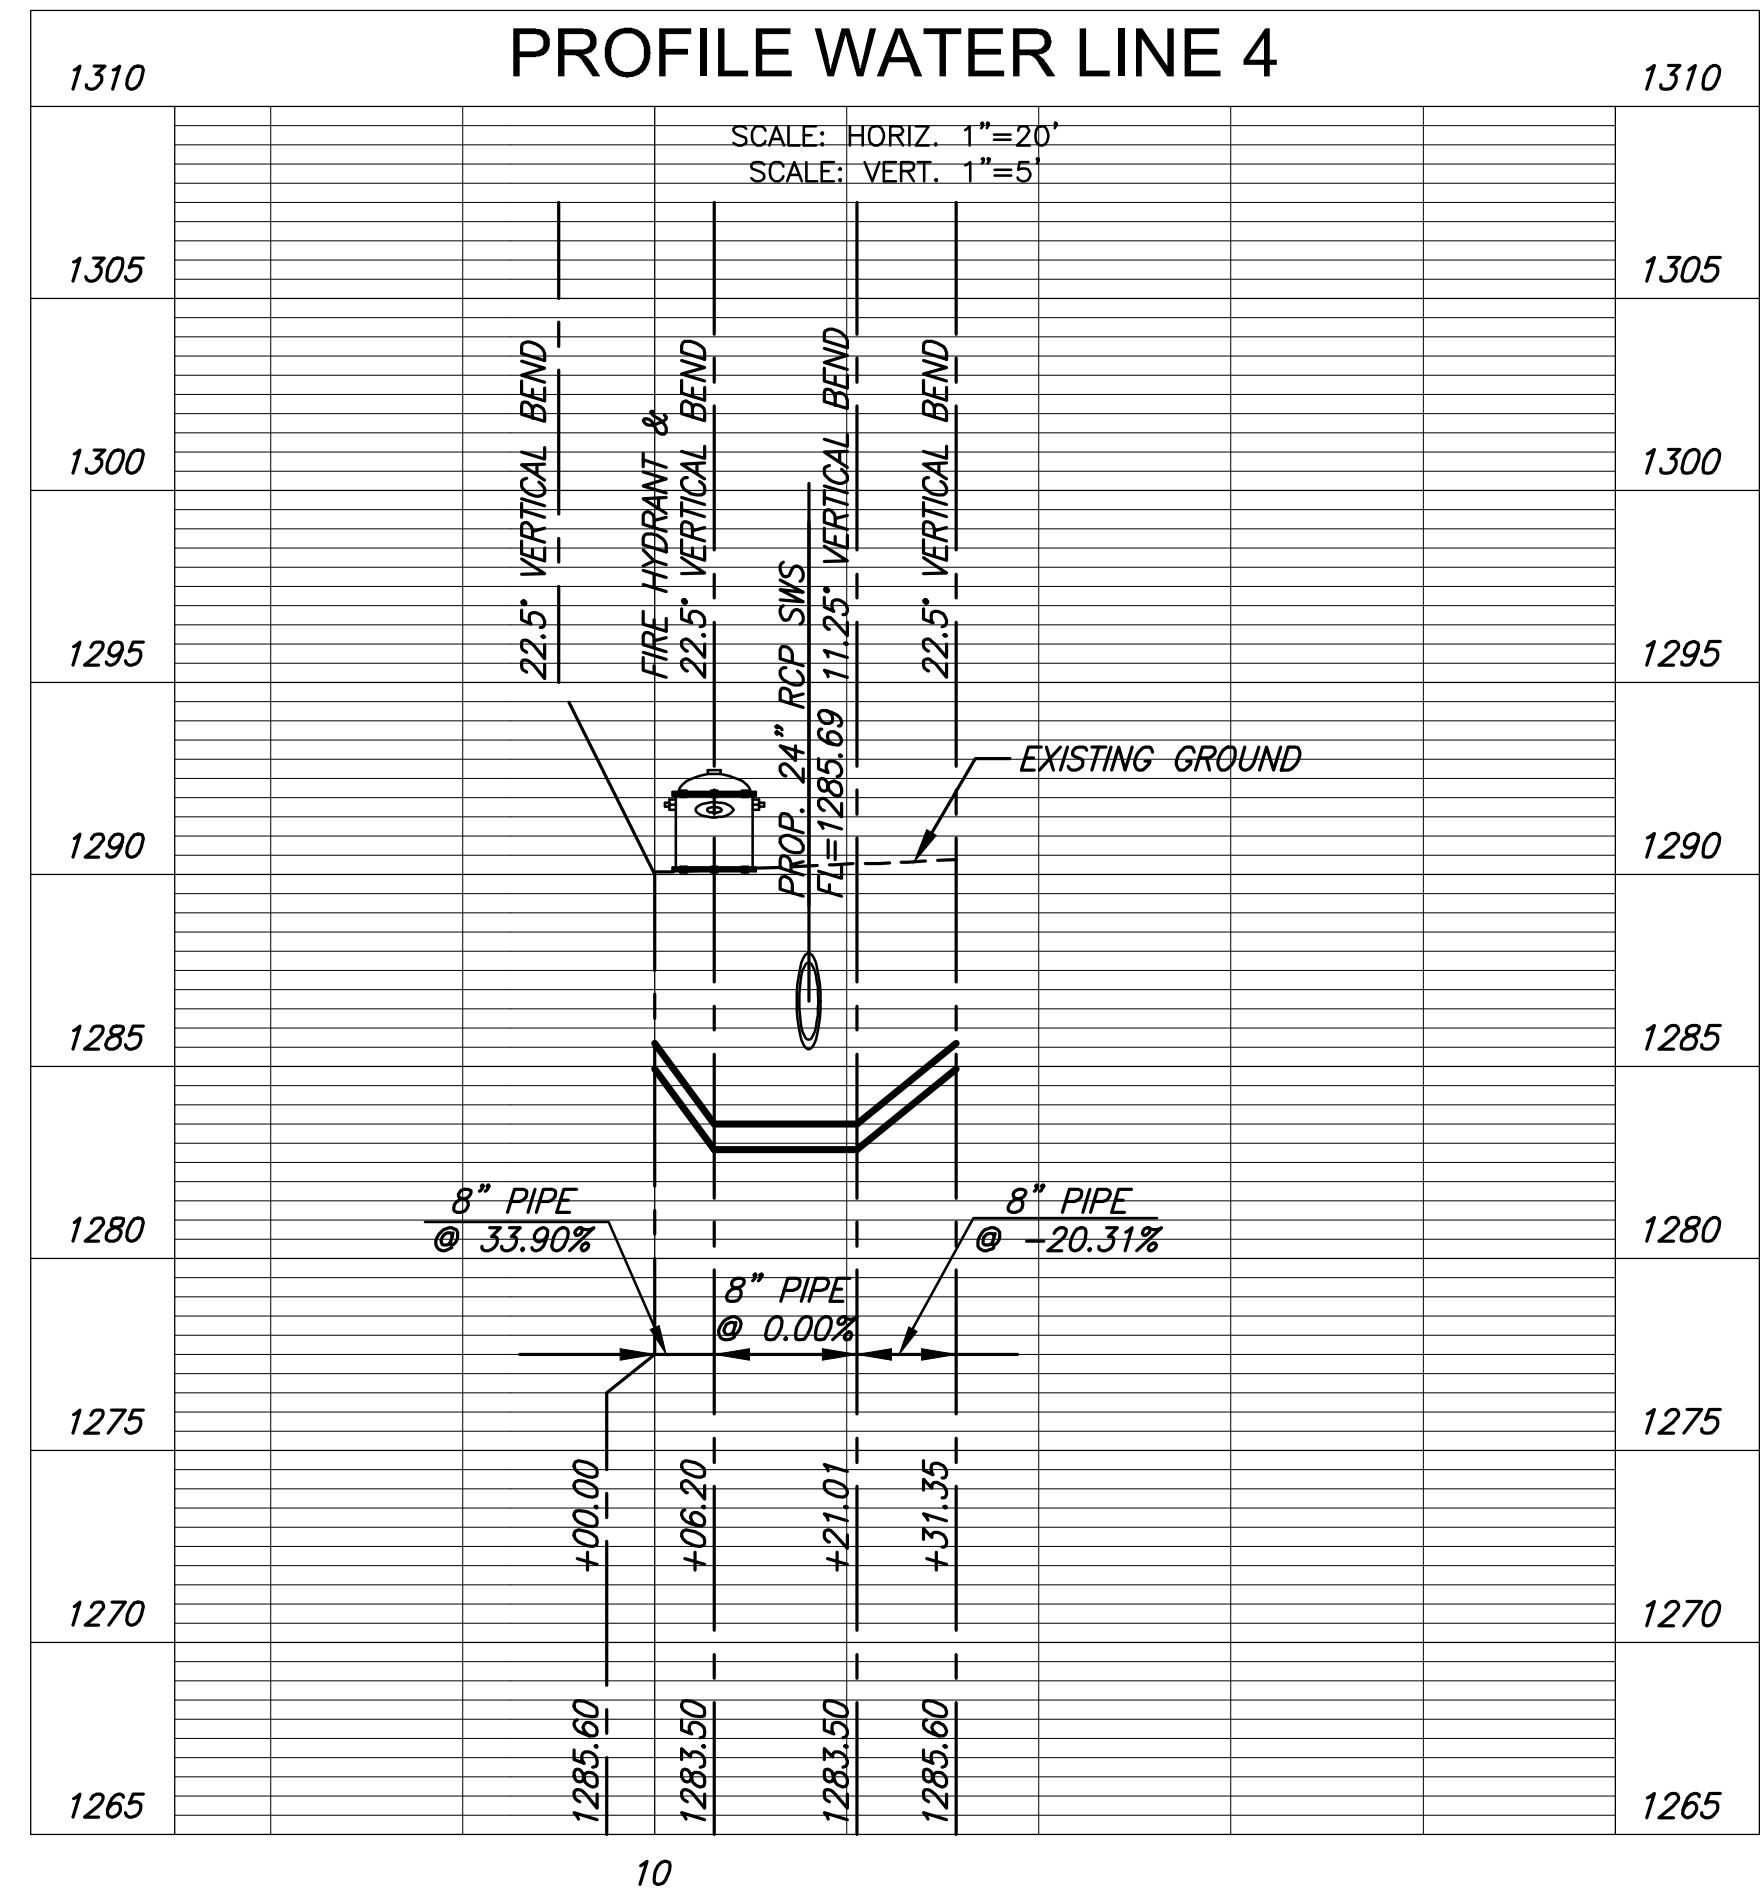

STREET IMPROVEMENTS FOR
MT. VERNON & HILLSIDE INTERSECTION
PAVING PLANS

©2019 MKEC Engineering All Rights Reserved
www.mkec.com
These drawings and their contents, including, but not limited to, all concepts, designs, & ideas are the exclusive property of MKEC Engineering (MKEC), and may not be used or reproduced in any way without the express consent of MKEC.

WATER LINES 3, 4
PLAN & PROFILE

PROJECT NO.	472-85286	
DATE	DATE	
SCALE	AS NOTED	
DESIGNED	DRAWN	CHECKED
JTC	DM	JRA
NO.	REVISION	DATE
SHEET NO.		