


SAVED 4/23/2020 10:36:47 AM BY CSL
 PLOTTED 5/6/2020 11:24:27 AM BY KURTIS DEKAT
 U:\WICHITA-CIVIL\2019\197043\15\MINI\DRAWINGS\197043-015-CU501.DWG

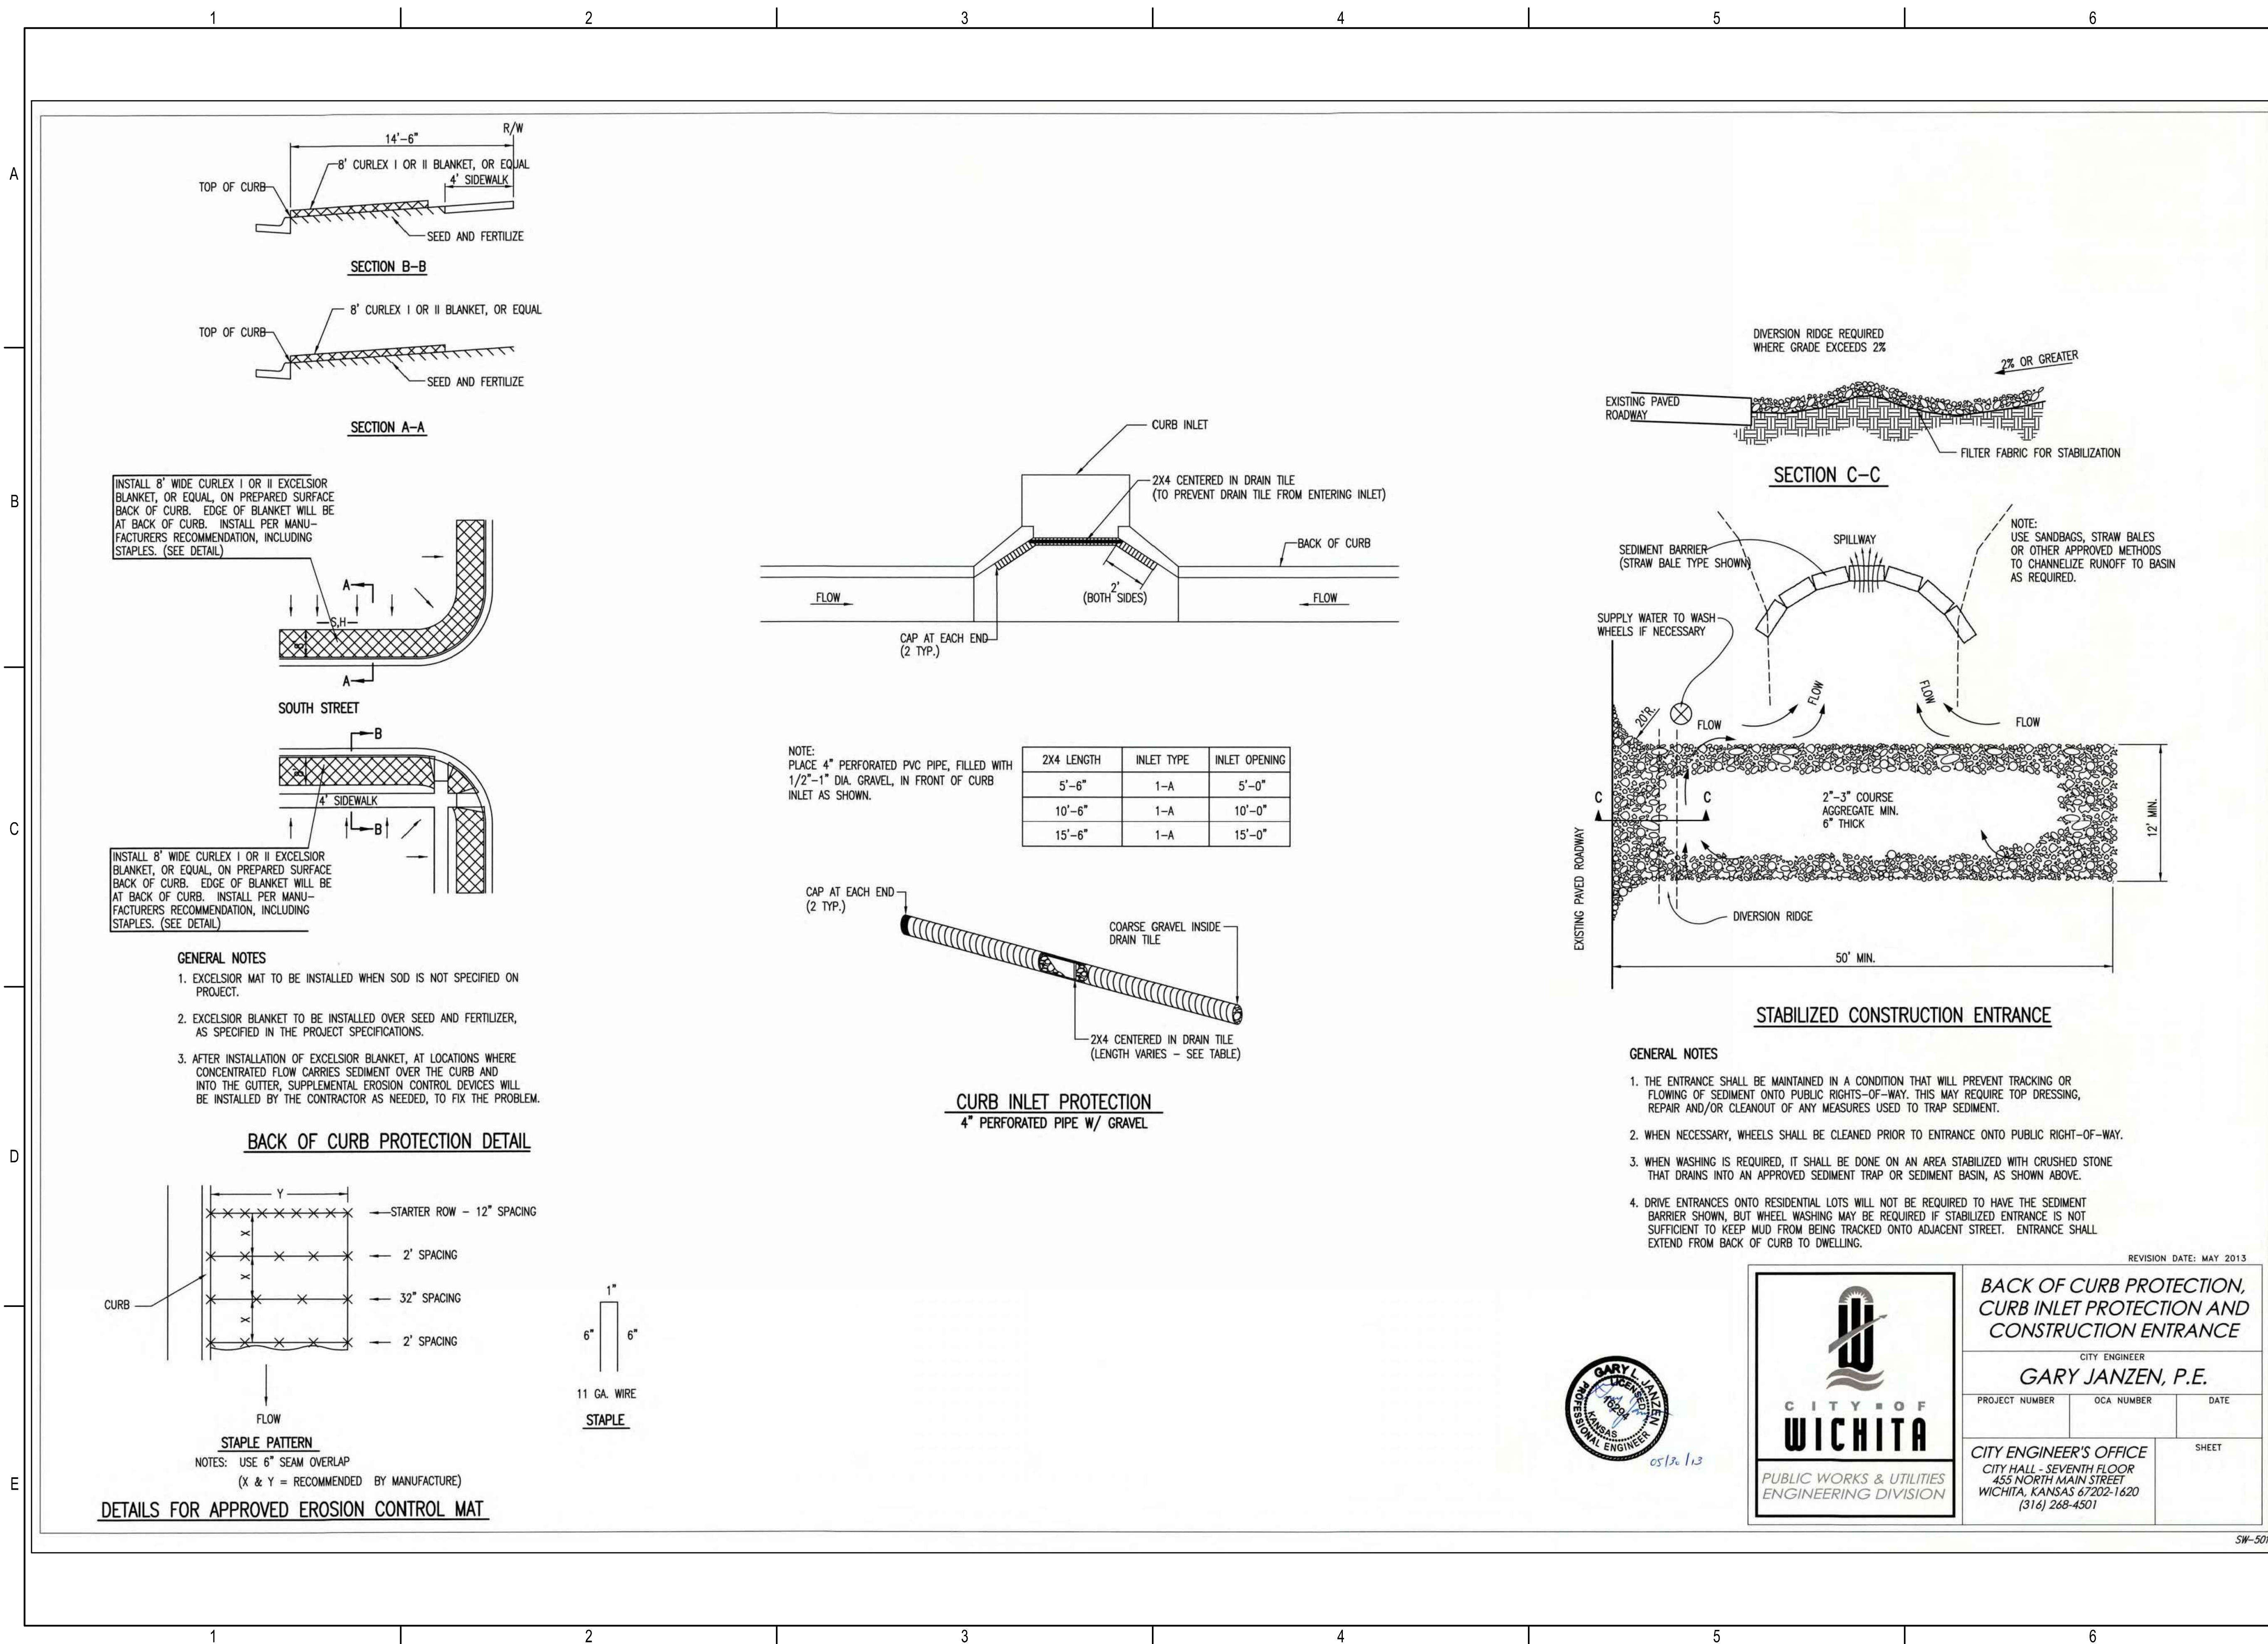

SANITARY SEWER RELOCATION
 TO SERVE


WASTE WATER TREATMENT
 PLANT 3

GARY JANZEN, P.E. - CITY ENGINEER
 CITY OF WICHITA PROJECT NO. 2020-468-004792
 OCA NO. S002 ORG CODE 53200020

Issue:	
JOB NO.	35-197043-015-042
DATE	APRIL 2020
PM	RWG
DESIGNED BY	TBK
DRAWN BY	CSL
CHECKED BY	RWG

EROSION CONTROL DETAILS

CU501

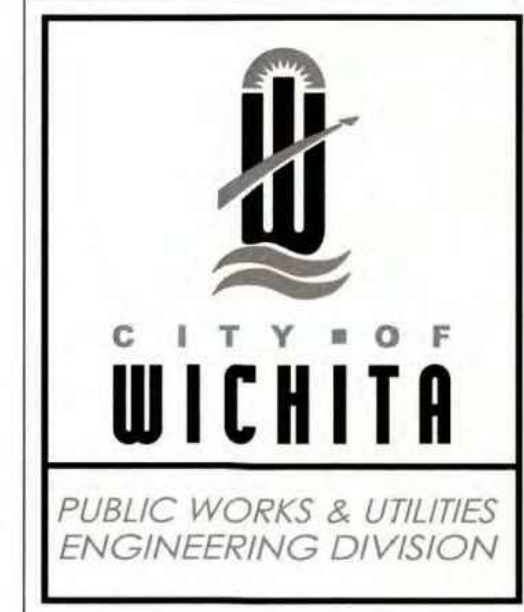

BACK OF CURB PROTECTION, CURB INLET PROTECTION, AND CONSTRUCTION ENTRANCE

CITY ENGINEER
GARY JANZEN, P.E.

PROJECT NUMBER OCA NUMBER DATE

CITY ENGINEER'S OFFICE
 CITY HALL - SEVENTH FLOOR
 455 NORTH MAIN STREET
 WICHITA, KANSAS 67202-1620
 (316) 268-4501



REVISION DATE: MAY 2013

SW-501