
 
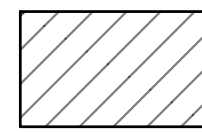


LEGEND



-  Pavement, Sidewalk, and Gutter Removal
-  Tree/Shrub Removal




Note:
 (XXX) For control and coordinate data, See Sheet 3
 The Contractor shall see streetscape plans for all items of construction beyond the back of curb, See Sheets 14-27
 For Storm Sewer Plan and Profiles, See Sheets 28-31
 For Electrical & Lighting Plans, See Sheets 69-73
 Contractor is to field verify all utility locations and elevations prior to excavating. Utility locations and elevations are shown to the best knowledge of the utility companies.

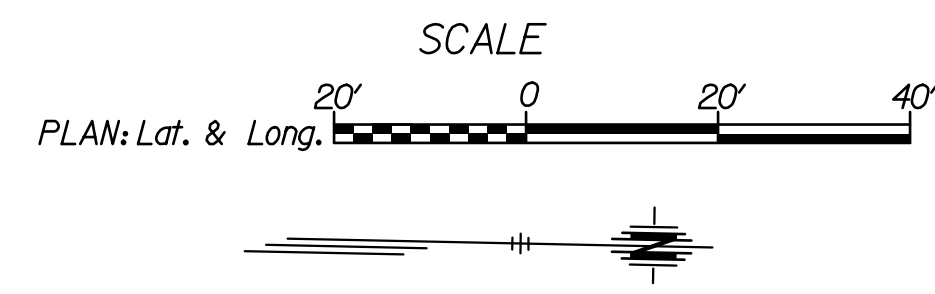

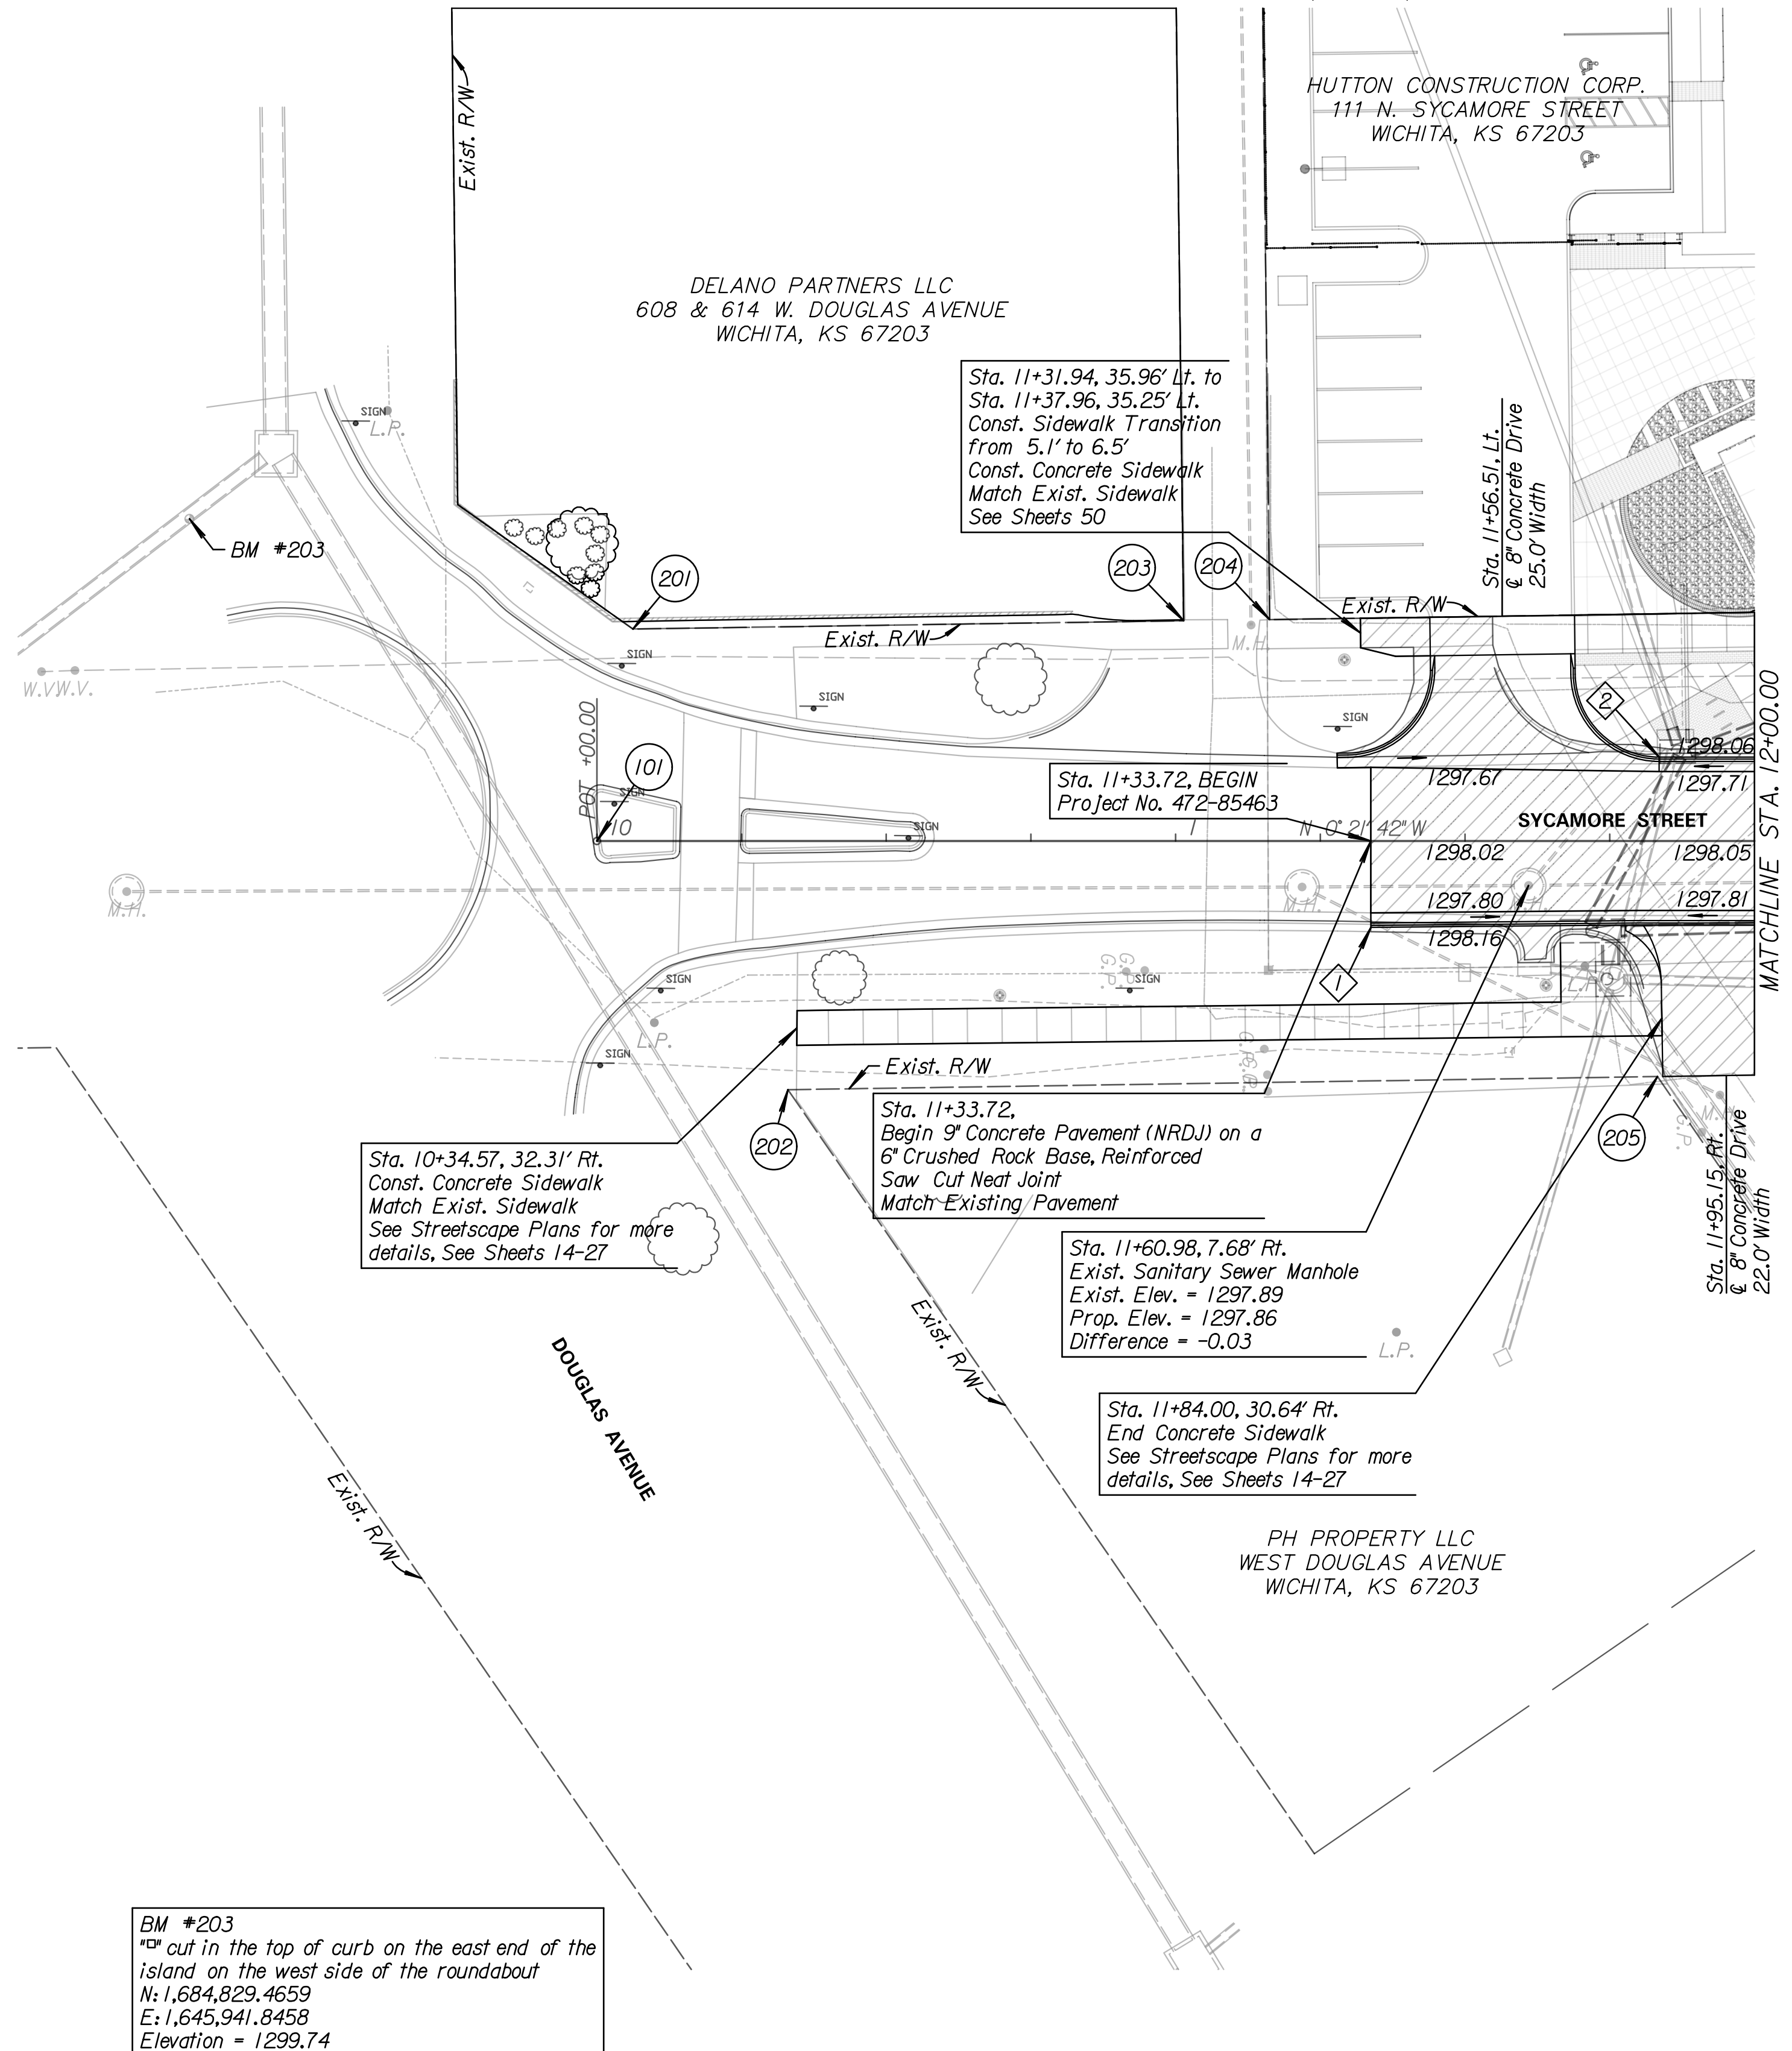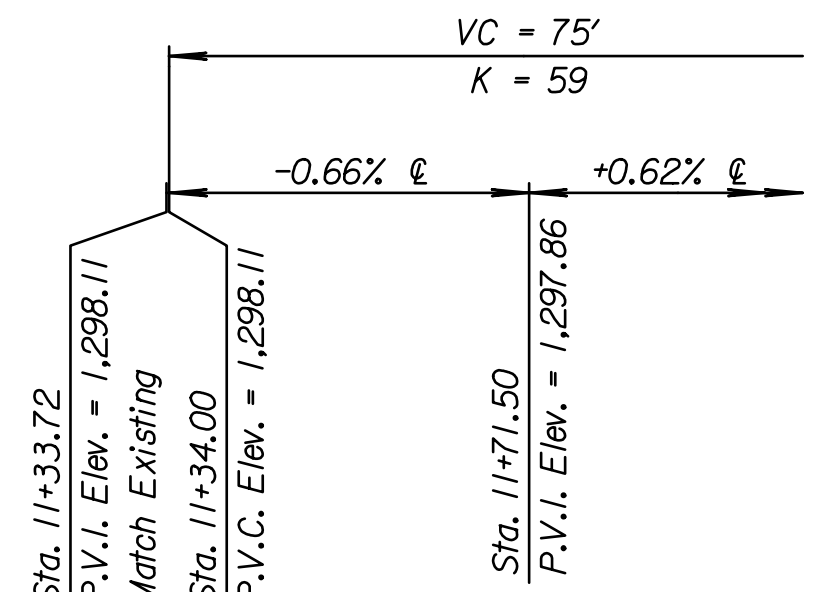

PROJECT SURVEY CONTROL & DATUM BENCHMARK

Horizontal - Kansas State Plane Coordinate System (South Zone) - NAD83 - Reduced to Ground (CAF = 0.999886261)
 Vertical - BM*203
 "0" Cut in the top of curb on the east end of the island on the west side of the roundabout.
 N: 1,684,829.4659
 E: 1,645,941.8458
 Datum: NAVD88 - Elevation = 1299.74

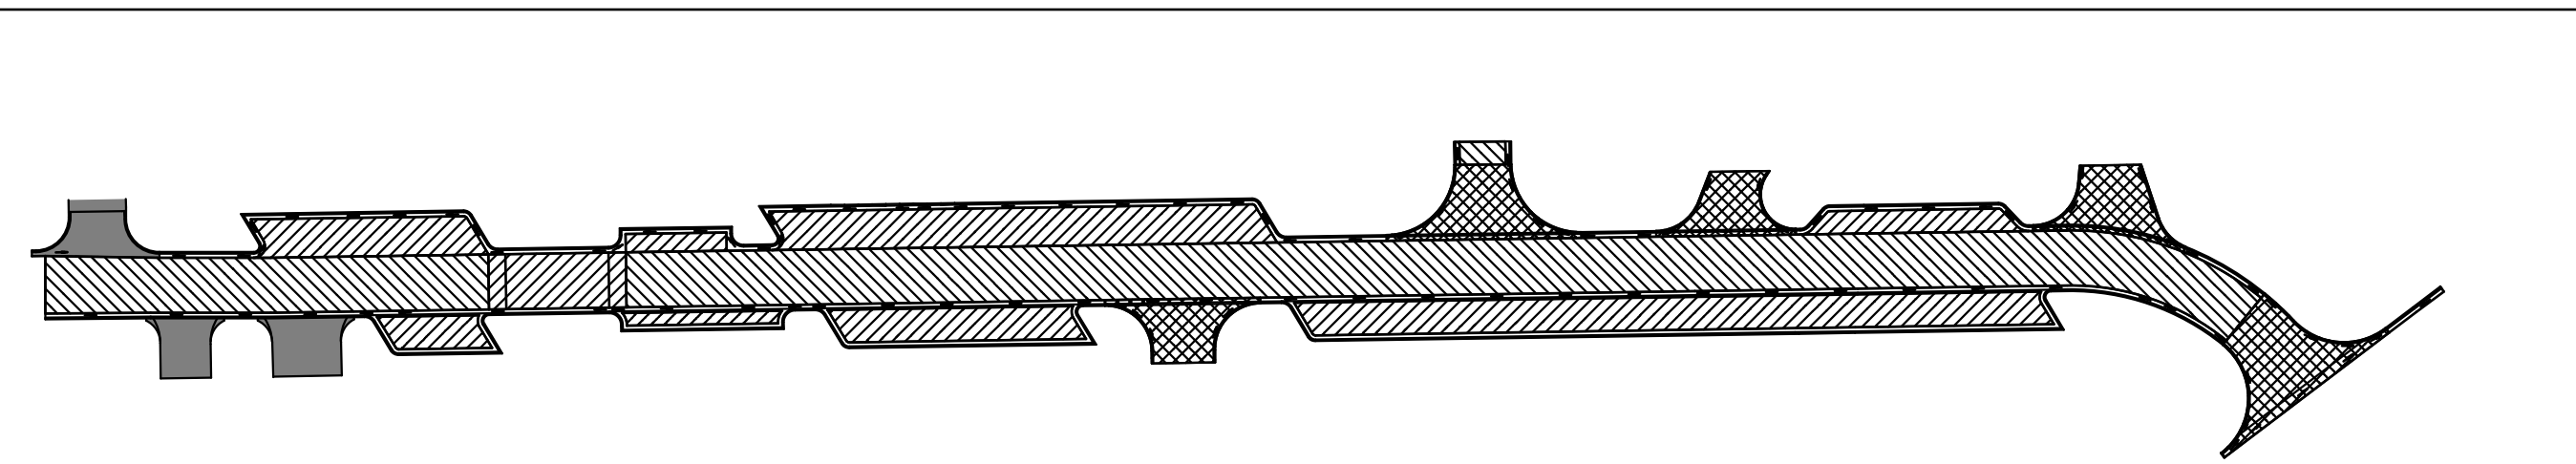

BACK OF CURB LOCATION & ELEVATIONS				
STATION	OFFSET	ELEVATION	DESCRIPTION	
1	11+33.74	14.91' Rt.	1298.19	Begin Type I (6') / Match Existing
2	11+83.53	14.50' Lt.	1297.99	Begin Type I (6')



- LEGEND
-  Concrete Pavement (9' Uniform)(NRDJ)
 -  Concrete Pavement (9' Uniform)(AE)
 -  Concrete Pavement (8' Uniform)(AE)
 -  Concrete Driveway Reinforced (8')

PAVEMENT DETAILS
N.T.S.

BM *203
 "0" cut in the top of curb on the east end of the island on the west side of the roundabout
 N: 1,684,829.4659
 E: 1,645,941.8458
 Elevation = 1299.74

Tran Systems
 245 NORTH WACO
 SUITE 222
 WICHITA, KANSAS 67202
 PHONE: 316-303-3000
 FAX: 316-462-5629

CONSULTANTS:

 LK ARCHITECTURE, INC.
 345 RIVERVIEW
 SUITE 200
 WICHITA, KANSAS 67208
 PHONE: 316-288-0230

SYCAMORE STREET IMPROVEMENTS
 WICHITA, KANSAS


REVISIONS:	MARK	DATE	DESCRIPTION

PROJ NO: 472-85463
 SCALE: 1"=20'
 DATE: 6/1/2020
 DESIGNED BY: TAU
 DRAWN BY: TAU
 CHECKED BY: MDB

SHEET TITLE:
 SYCAMORE STREET IMPROVEMENTS
 STA. 11+33.72 TO
 STA. 12+00.00

SHEET NO.
 7
 SHEET 7 OF 97

6/1/2020 12:21:13 PM c:\transtransystems\paw_bocall\tran\sys\proj\472\472-85463\CADD\DWG\M01-101.dgn