



L/K DWG. NAME: 18193-66-70 SYCAMORE LG NG A 3 2020 12 01 LAS TD TD BY

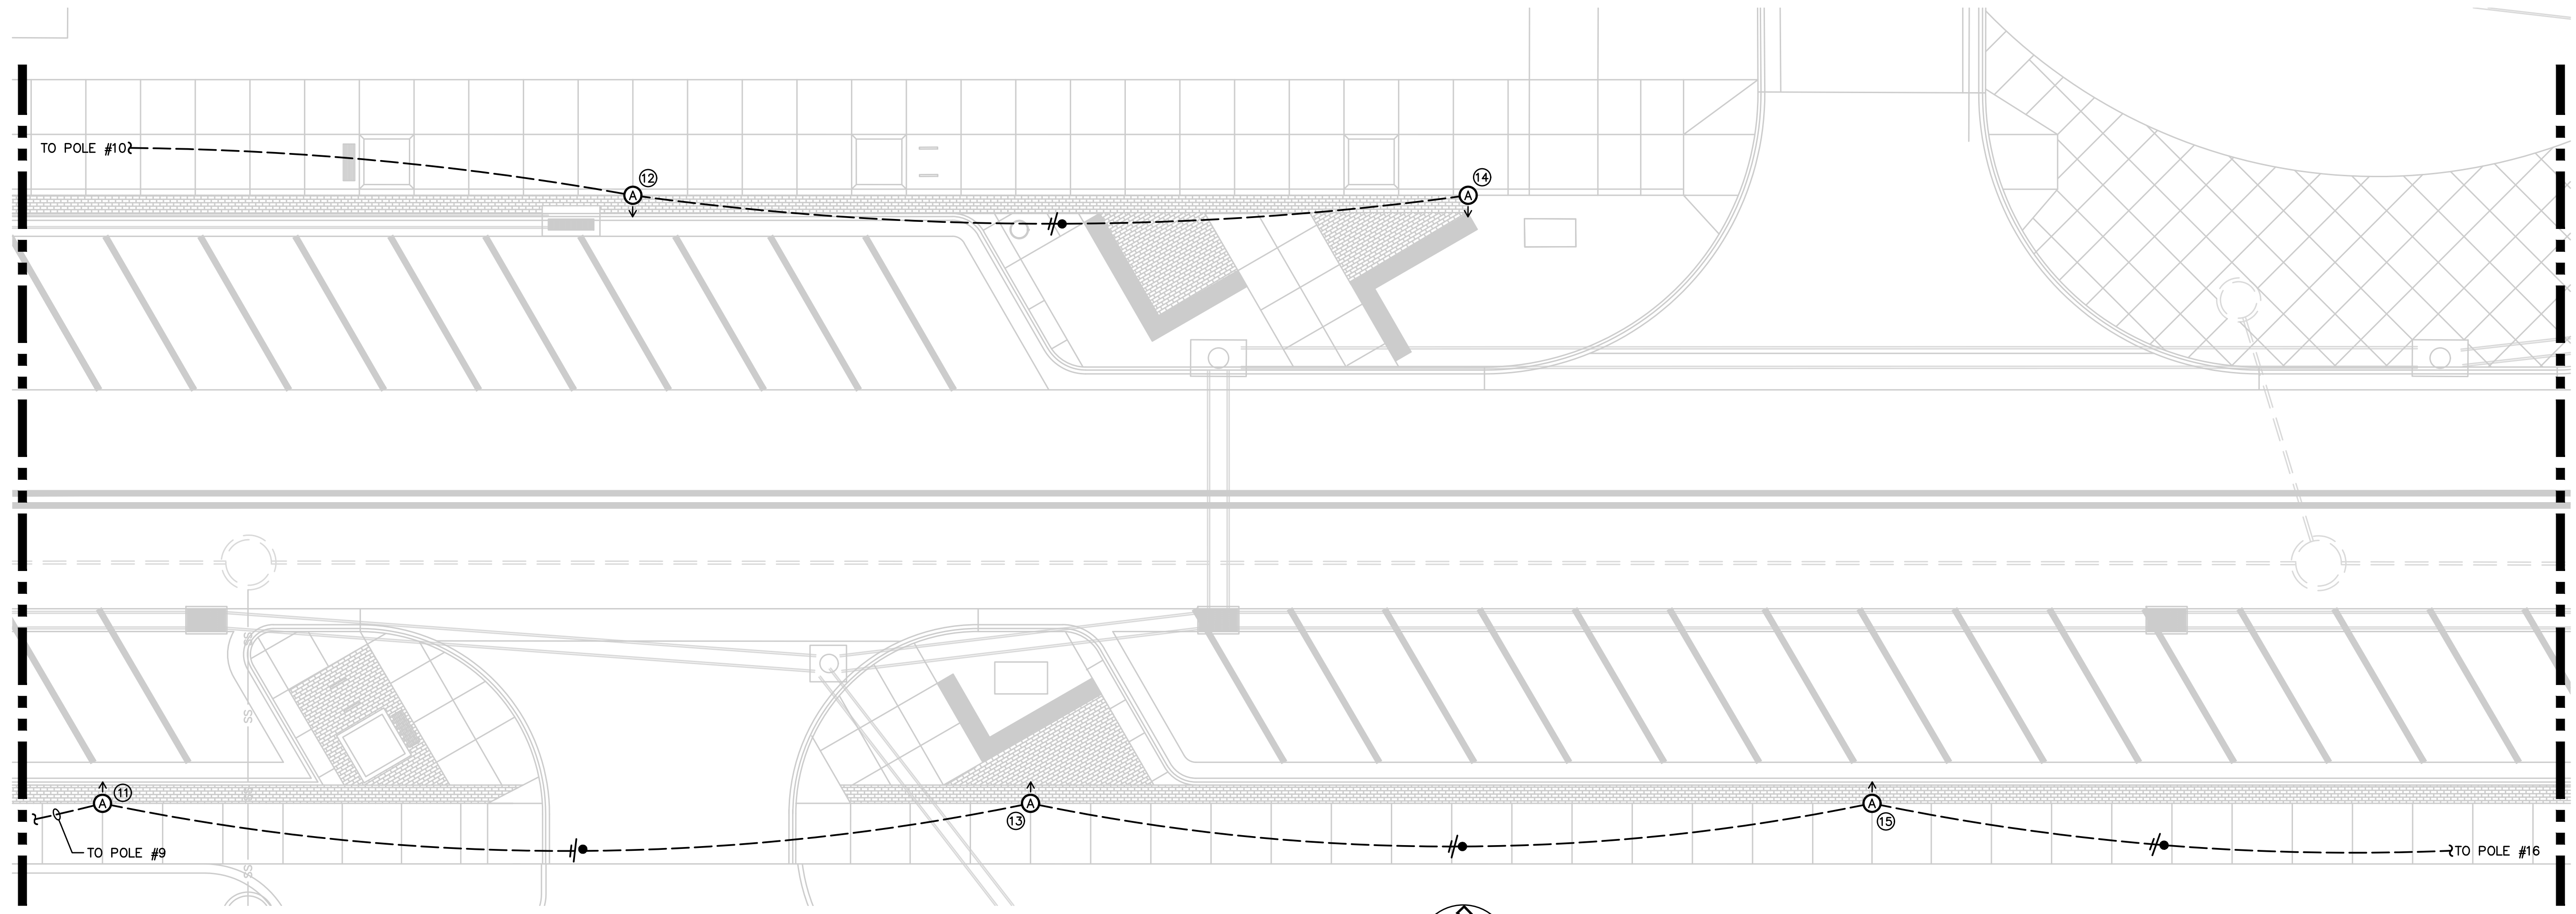

A LIGHTING PLAN - C
 1" = 10'-0"
 0 5' 10' 20'
 NORTH

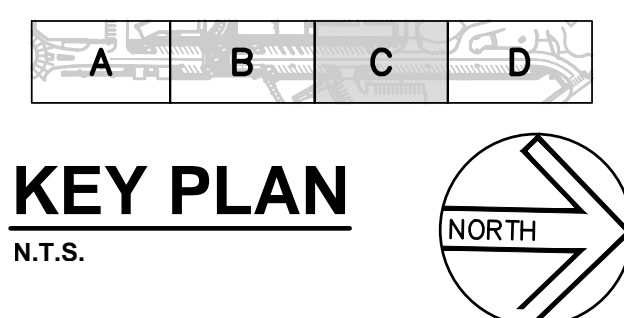

Tran Systems
 245 NORTH WACO
 SUITE 222
 WICHITA, KANSAS 67202
 PHONE: 316-303-3000
 FAX: 316-462-5629

CONSULTANTS:
LK ARCHITECTURE, INC.
 345 RIVERVIEW
 SUITE 200
 WICHITA, KANSAS 67208
 PHONE: 316-268-0230

SYCAMORE STREET IMPROVEMENTS
 WICHITA, KANSAS
CITY OF WICHITA

REVISIONS:	MARK	DATE	DESCRIPTION

PROJ NO: 472-85284
 SCALE: 1" = 10'-0"
 DATE: 5/21/2020
 DESIGNED BY: S. WIEBE
 DRAWN BY: S. WIEBE
 CHECKED BY: T. LEWIS

SHEET TITLE:
SITE ELECTRICAL PLAN - C

SHEET NO.
71
 SHEET 71 OF 92