


BID ITEM (AS PER SHEET)		COMMON NAME
QTY.	BOTANICAL NAME	
4	FRAXINUS PENNSYLVANICA 'MARSHALL'	MARSHALL'S GREEN ASH
2	QUERCUS SHUMARDII	SHUMARD'S OAK
5	CERCIS CANADENSIS	EASTERN REDBUD
2	KOELREUTERIA PANICULATA	GOLDEN RAINTREE
6	PINUS NIGRA	AUSTRIAN PINE
2	PINUS SYLVESTRIS	SCOTCH PINE
33	EUONYMUS FORTUNEI 'SARCOXIE'	SARCOXIE EUONYMUS
66	JUNIPERUS CHINENSIS 'PFITZERANA'	PFITZER JUNIPER
15	JUNIPERUS SABINA 'BROADMOOR'	BROADMOOR JUNIPER
62	TAXUS X MEDIA 'HICKSII'	HICKS YEW
32	EUONYMUS ALATUS	WINGED EUONYMUS
48	LONICERA FRAGRANTISSIMA	WINTER HONEYSUCKLE
32	RIBES ODORATUM 'WENDLAND'	WENDLAND BUFFALO CURRANT
18	SPIRAEA X BUMALDA 'ANTHONY WATERER'	ANTHONY WATERER SPIREA
48	VIBURNUM DENTATUM 'SYNNESTVEDT'	'CHICAGO LUSTRE' ARROWWOOD VIBURNUM
12	VIBURNUM RHYTIDOPHYLLUM	LEATHERLEAF VIBURNUM
2139	EUONYMUS FORTUNEI 'COLORATA'	PURPLELEAF WINTERCREEPER
320	JUNIPERUS HORIZ 'MONISE'	'TURQUOISE SPREADER' JUNIPER
32	PYRACANTHA COCCINEA 'KASAN'	KASAN SCARLET FIRETHORN
SEEDING - TURF TYPE TALL FESCUE (OVERSEEDING)		.82 ACRES
SEEDING - TURF TYPE TALL FESCUE (BARE SOIL)		0 ACRES

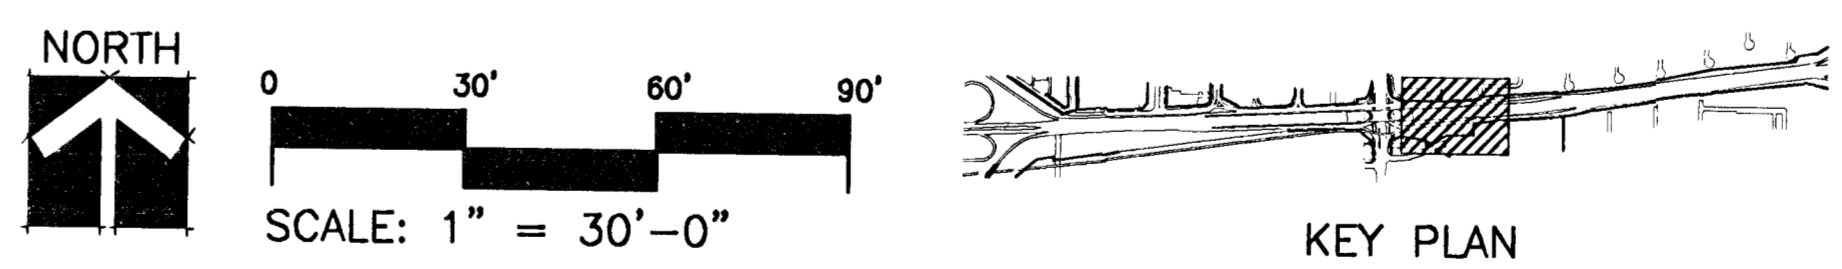

NOTE:
SEE SHT. 18 FOR GENERAL NOTES.
SEE SHT. 26 FOR PLANTING LEGEND,
NOTES AND DETAILS.

UTILITY OWNERS:
CITY OF WICHITA WATER AND SEWER DEPARTMENT (316) 268-4908
MULTIMEDIA CABLEVISION (316) 262-0661
SOUTHWEST BELL TELEPHONE 800-734-7630
WILLIAMS NATURAL GAS PIPELINE (918) 588-4200
KANSAS GAS AND ELECTRIC (316) 832-3169 OR 832-3180

CONTRACTOR TO VERIFY LOCATIONS OF ALL UTILITIES PRIOR TO DIGGING.

KANSAS DEPARTMENT OF TRANSPORTATION
KELLOGG AND WEST STREET
STATION 150+00 TO 157+00
PLANTING PLAN
PROJECT NO. #701221

Wilson Darnell Mann
architecture site planning interiors
Wichita, Kansas

DESIGNED BY: WDM, PA
DRAWN BY: SKW
CHECKED BY: LME
DATE: 7/31/97
SHEET 22 OF 43

2-17-97
E: 94082/LP-5
E: 94082 MAINBASE E: 94082 PLANTS E: 94082 PAVERS