



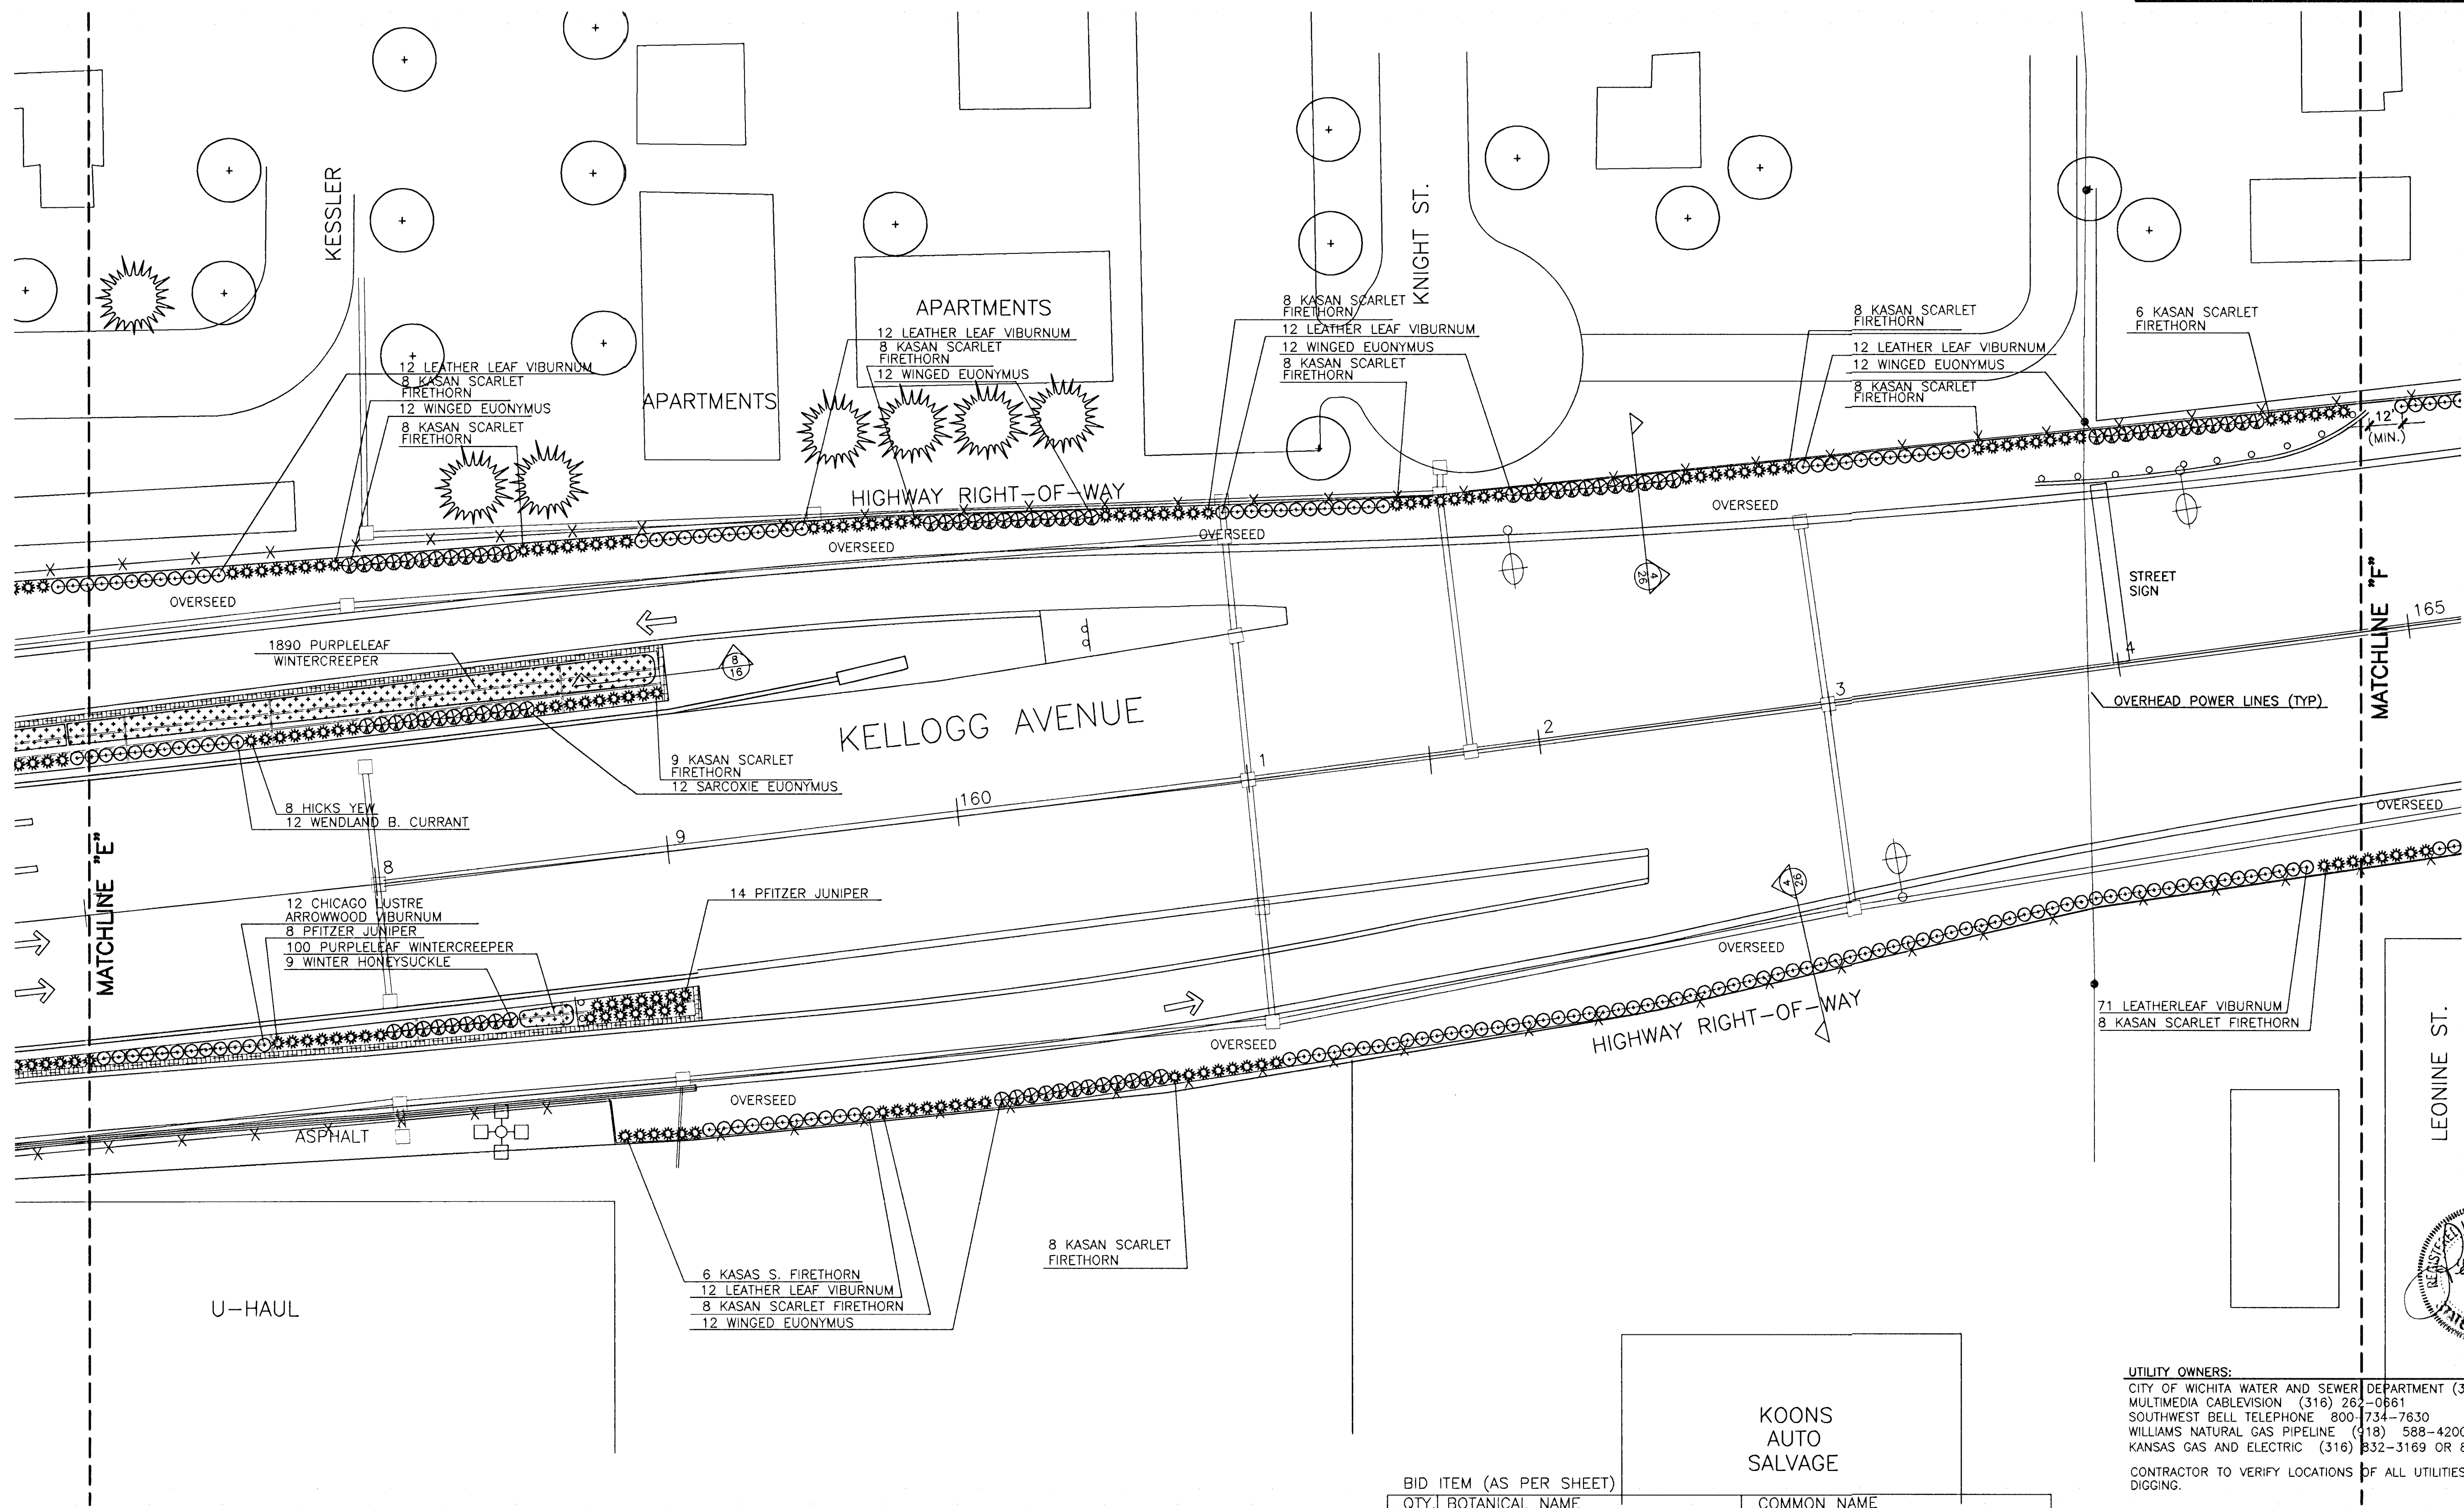

0 30' 60' 90'
SCALE: 1" = 30'-0"

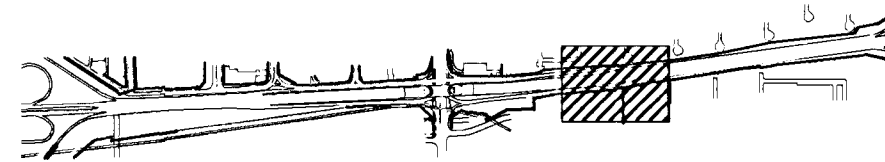

KEY PLAN

NOTE:
SEE SHT. 18 FOR GENERAL NOTES.
SEE SHT. 26 FOR PLANTING LEGEND,
NOTES AND DETAILS.

BID ITEM (AS PER SHEET)

QTY.	BOTANICAL NAME	COMMON NAME
12	EUONYMUS FORTUNEI "SARCOXIE"	SARCOXIE EUONYMUS
22	JUNIPERUS CHINENSIS "PFITZERIANA"	PFITZER JUNIPER
101	PYRACANTHA COCCINEA "KASAN"	KASAN SCARLET FIRETHORN
8	TAXUS X MEDIA "HICKSII"	HICKS YEW
60	EUONYMUS ALATA	WINGED EUONYMUS
9	LONICERA FRAGRANTISSIMA	WINTER HONEYSUCKLE
12	RIBES ODORATUM "WENDLAND"	WENDLAND BUFFALO CURRANT
12	VIBURNUM DENTATUM "CHICAGO LUSTER"	"CHICAGO LUSTER" ARROWWOOD VIBURNUM
131	VIBURNUM RHYTIDOPHYLLUM	LEATHER LEAF VIBURNUM
1990	EUONYMUS FORTUNEI "COLORATA"	PURPLELEAF WINTERCREEPER
SEEDING - TURF TYPE TALL FESCUE (OVERSEEDING)		.41 ACRES
SEEDING - TURF TYPE TALL FESCUE (BARE SOIL)		0 ACRES

KOONS
AUTO
SALVAGE

UTILITY OWNERS:
CITY OF WICHITA WATER AND SEWER DEPARTMENT (316) 268-4908
MULTIMEDIA CABLEVISION (316) 262-0661
SOUTHWEST BELL TELEPHONE 800-734-7630
WILLIAMS NATURAL GAS PIPELINE (318) 588-4200
KANSAS GAS AND ELECTRIC (316) 832-3169 OR 832-3180

CONTRACTOR TO VERIFY LOCATIONS OF ALL UTILITIES PRIOR TO DIGGING.

KANSAS DEPARTMENT OF TRANSPORTATION

KELLOGG AND WEST STREET
STATION 157+00 TO 165+00
PLANTING PLAN
PROJECT NO. #101221

Wilson Darnell Mann
architecture site planning interiors
Wichita, Kansas



DESIGNED BY: WDM, PA	CHECKED BY: LME
DRAWN BY: SKW	DATE: 7/31/97 SHEET 23 OF 43