



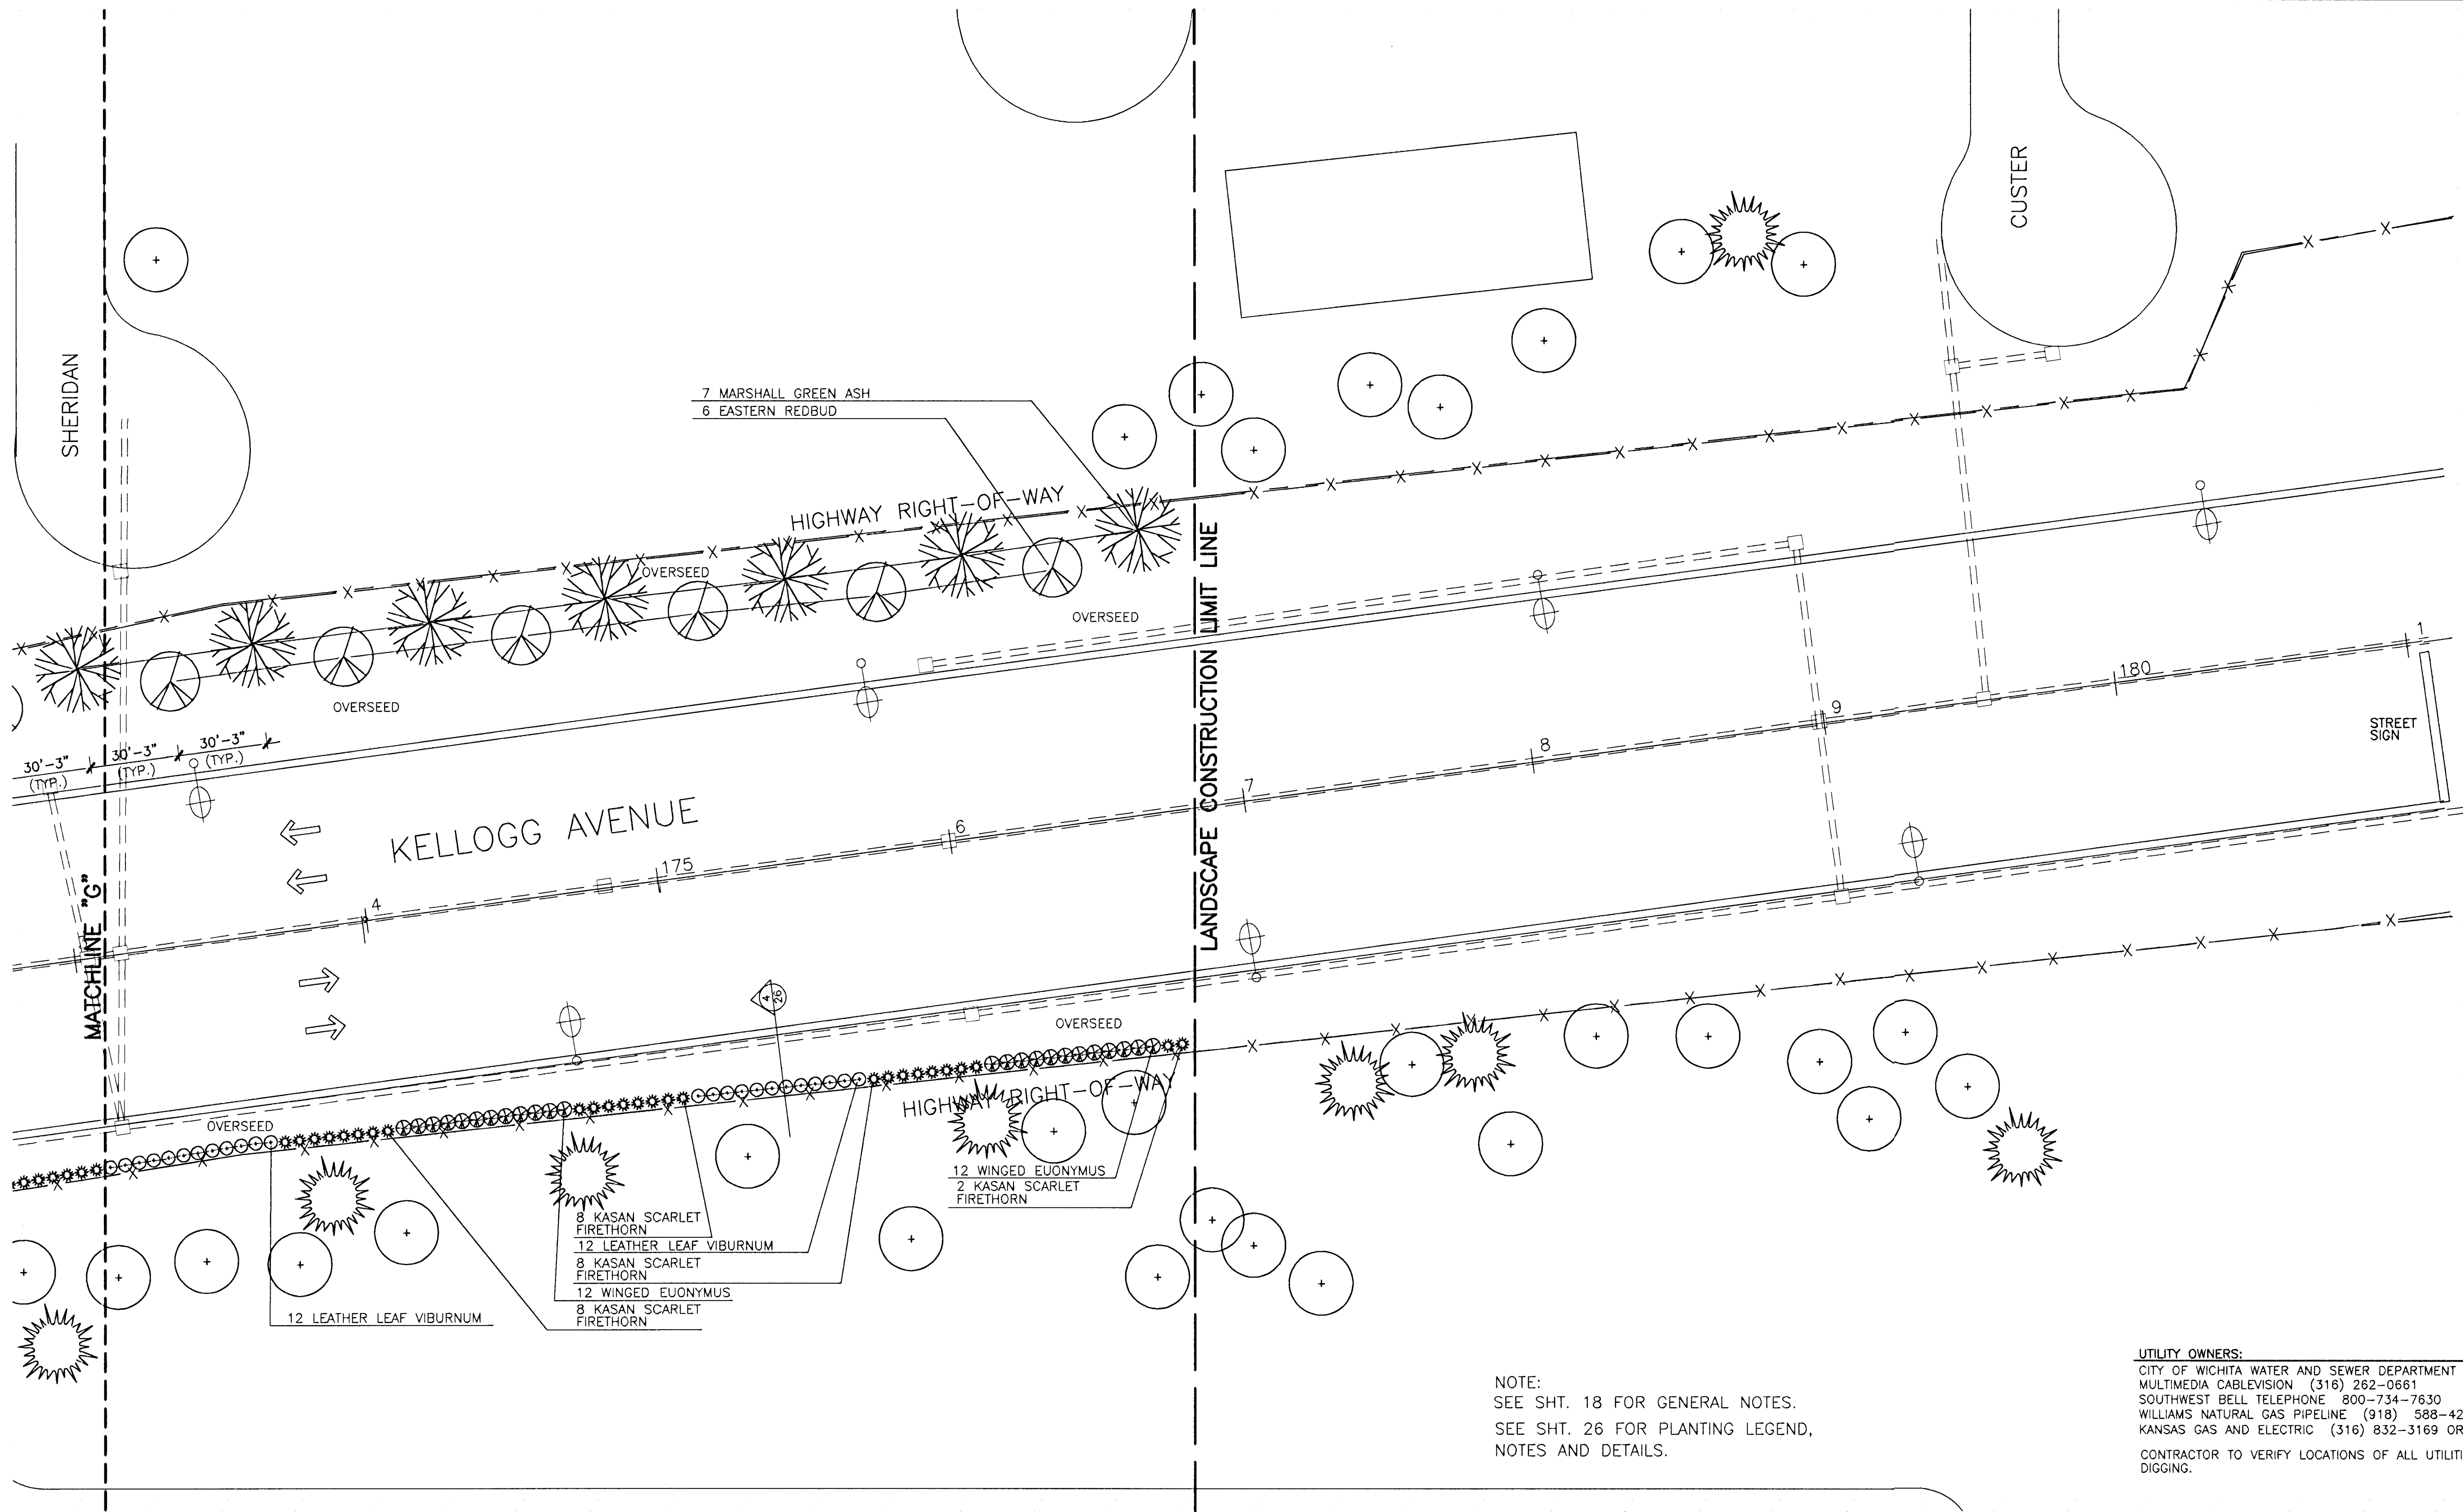


NOTE:
SEE SHT. 18 FOR GENERAL NOTES.
SEE SHT. 26 FOR PLANTING LEGEND,
NOTES AND DETAILS.

UTILITY OWNERS:
CITY OF WICHITA WATER AND SEWER DEPARTMENT (316) 268-4908
MULTIMEDIA CABLEVISION (316) 262-0661
SOUTHWEST BELL TELEPHONE 800-734-7630
WILLIAMS NATURAL GAS PIPELINE (918) 588-4200
KANSAS GAS AND ELECTRIC (316) 832-3169 OR 832-3180
CONTRACTOR TO VERIFY LOCATIONS OF ALL UTILITIES PRIOR TO DIGGING.

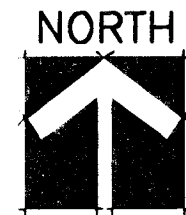

0 30' 60' 90'
SCALE: 1" = 30'-0"

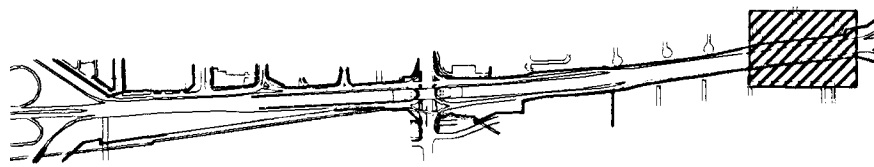

KEY PLAN

BID ITEM (AS PER SHEET)

QTY.	BOTANICAL NAME	COMMON NAME
7	FRAXINUS PENNSYLVANICA "MARSHALL"	MARSHALL GREEN ASH
6	CERCIS CANADENSIS	EASTERN REDBUD
26	PYRACANTHA COCCINEA 'KASAN'	KASAN SCARLET FIRETHORN
24	EUONYMUS ALATA	WINGED EUONYMUS
24	VIBURNUM RHYTIDOPHYLLUM	LEATHER LEAF VIBURNUM
SEEDING - TURF TYPE TALL FESCUE (OVERSEEDING)		.55 ACRES
SEEDING - TURF TYPE TALL FESCUE (BARE SOIL)		0 ACRES

KANSAS DEPARTMENT OF TRANSPORTATION

KELLOGG AND WEST STREET
STATION 173+00 TO 181+00

PLANTING PLAN

PROJECT NO. #101227

Wilson Darnell Mann
architecture site planning interiors
Wichita, Kansas

