
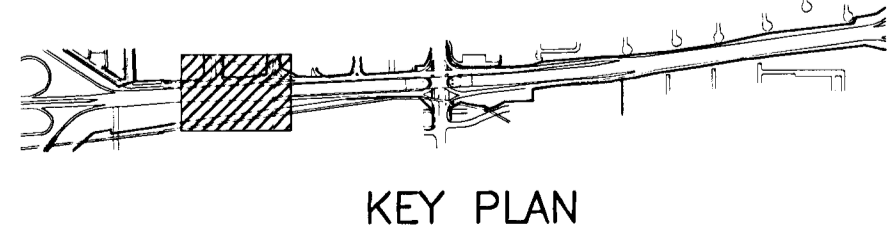
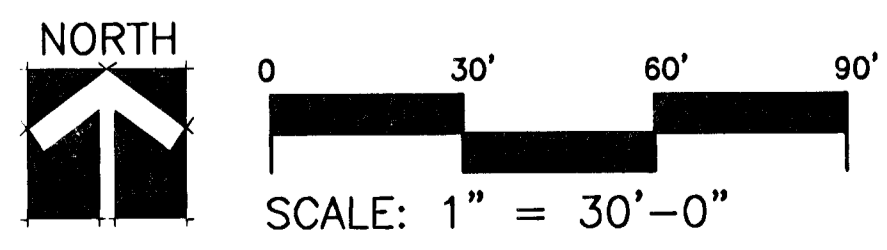



FHWA REG NO.	STATE	PROJECT NO.	YEAR	SHEET NO.	SHEETS
7	KANSAS	54-87-TE-0039-01	1997	28	43

UTILITY OWNERS:
 CITY OF WICHITA WATER AND SEWER DEPARTMENT (316) 268-4908
 MULTIMEDIA CABLEVISION (316) 262-0661
 SOUTHWEST BELL TELEPHONE 800-734-7630
 WILLIAMS NATURAL GAS PIPELINE (918) 588-4200
 KANSAS GAS AND ELECTRIC (316) 832-3169 OR 832-3180

CONTRACTOR TO VERIFY LOCATIONS OF ALL UTILITIES PRIOR TO DIGGING.

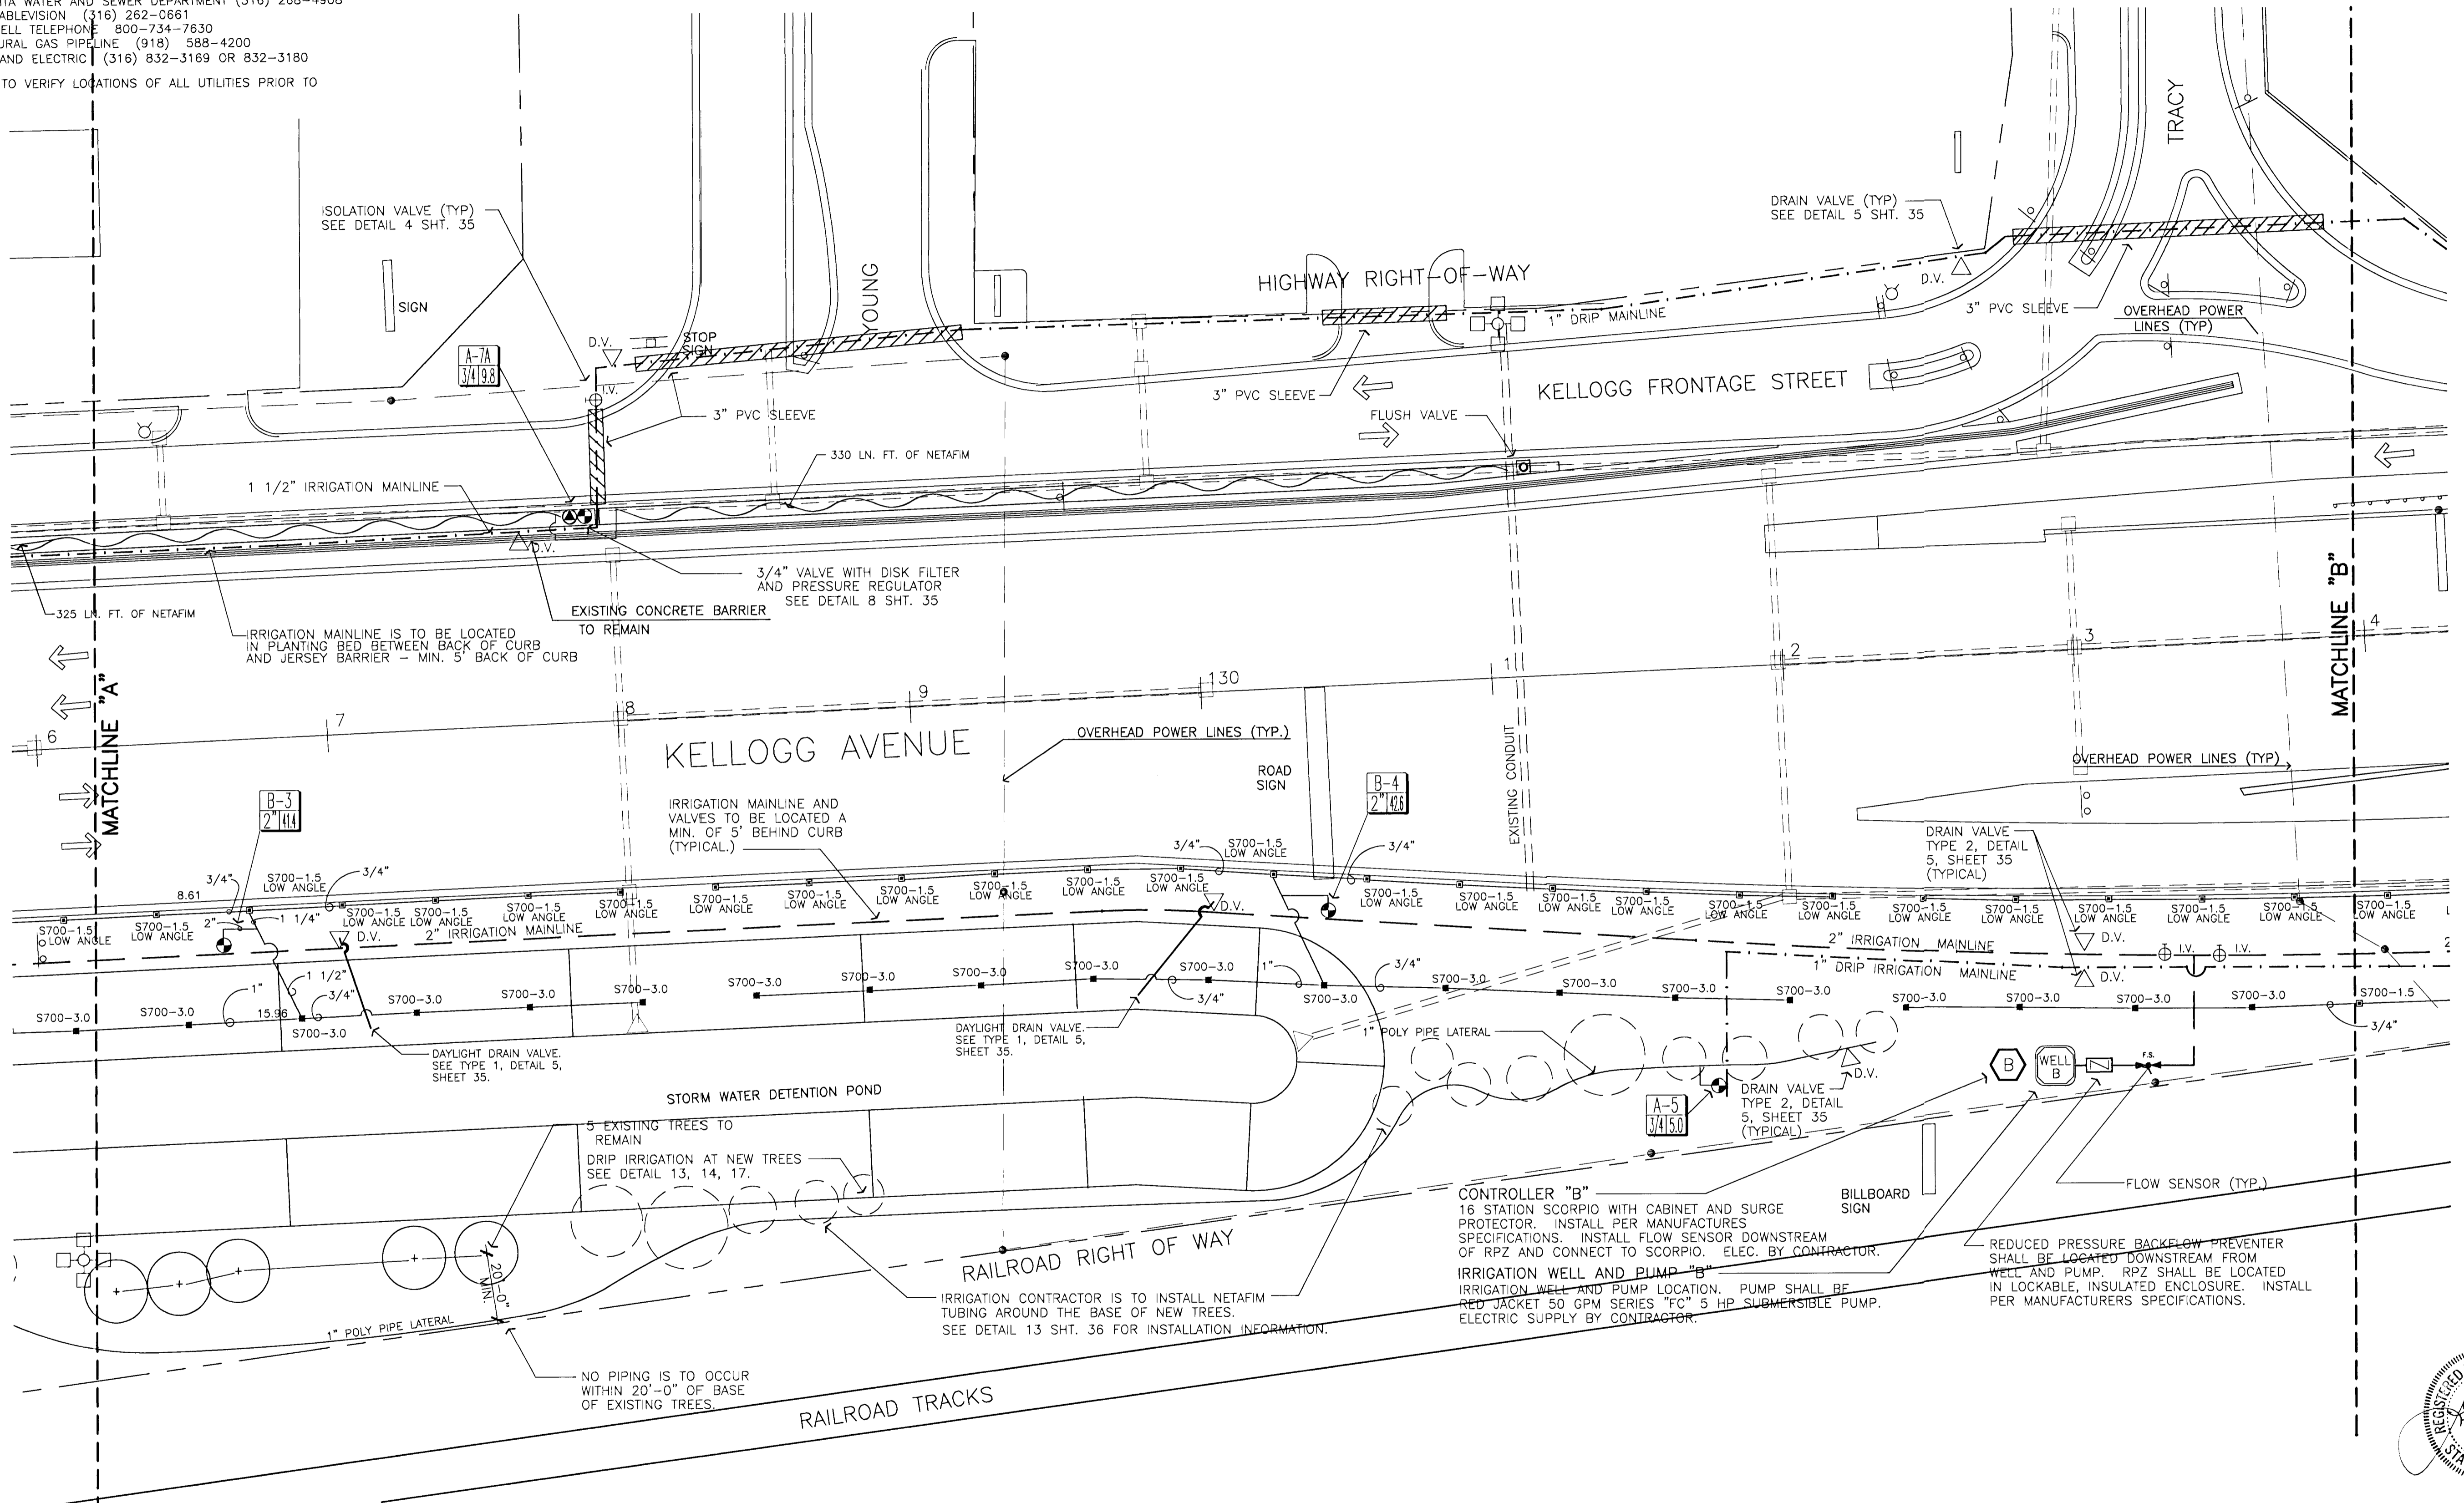

NOTE:
 SEE SHEETS 35 AND 36 FOR IRRIGATION DETAILS
 SEE SHEET 37 FOR IRRIGATION NOTES AND LEGEND

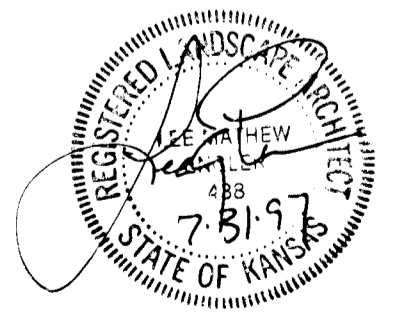

KANSAS DEPARTMENT OF TRANSPORTATION

KELLOGG AND WEST STREET
 STATION 126+00 TO 134+00
 IRRIGATION PLANS
 PROJECT NO. #701221

Wilson Darnell Mann
 architecture site planning interiors
 Wichita, Kansas

DESIGNED BY: WDM, PA
 DRAWN BY: SKW

CHECKED BY: LME
 DATE: 7/31/97

SHEET 28 OF 43

2-17-97
 E:\94082\11-2
 E:\94082\MAINBASE E:\94082\IRRI