
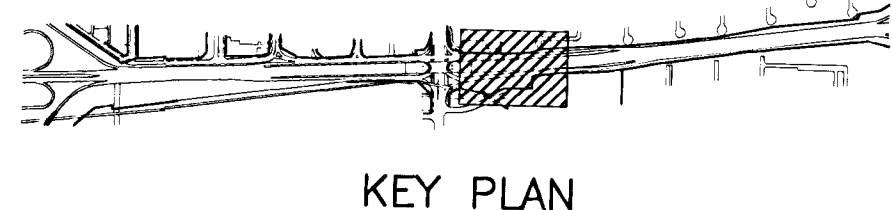
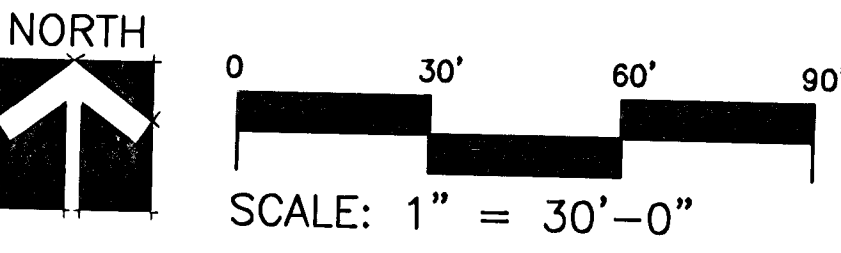


FHWA REG NO.	STATE	PROJECT NO.	YEAR	SHEET NO.	SHEETS
7	KANSAS	54-87-TE-0039-01	1997	31	43

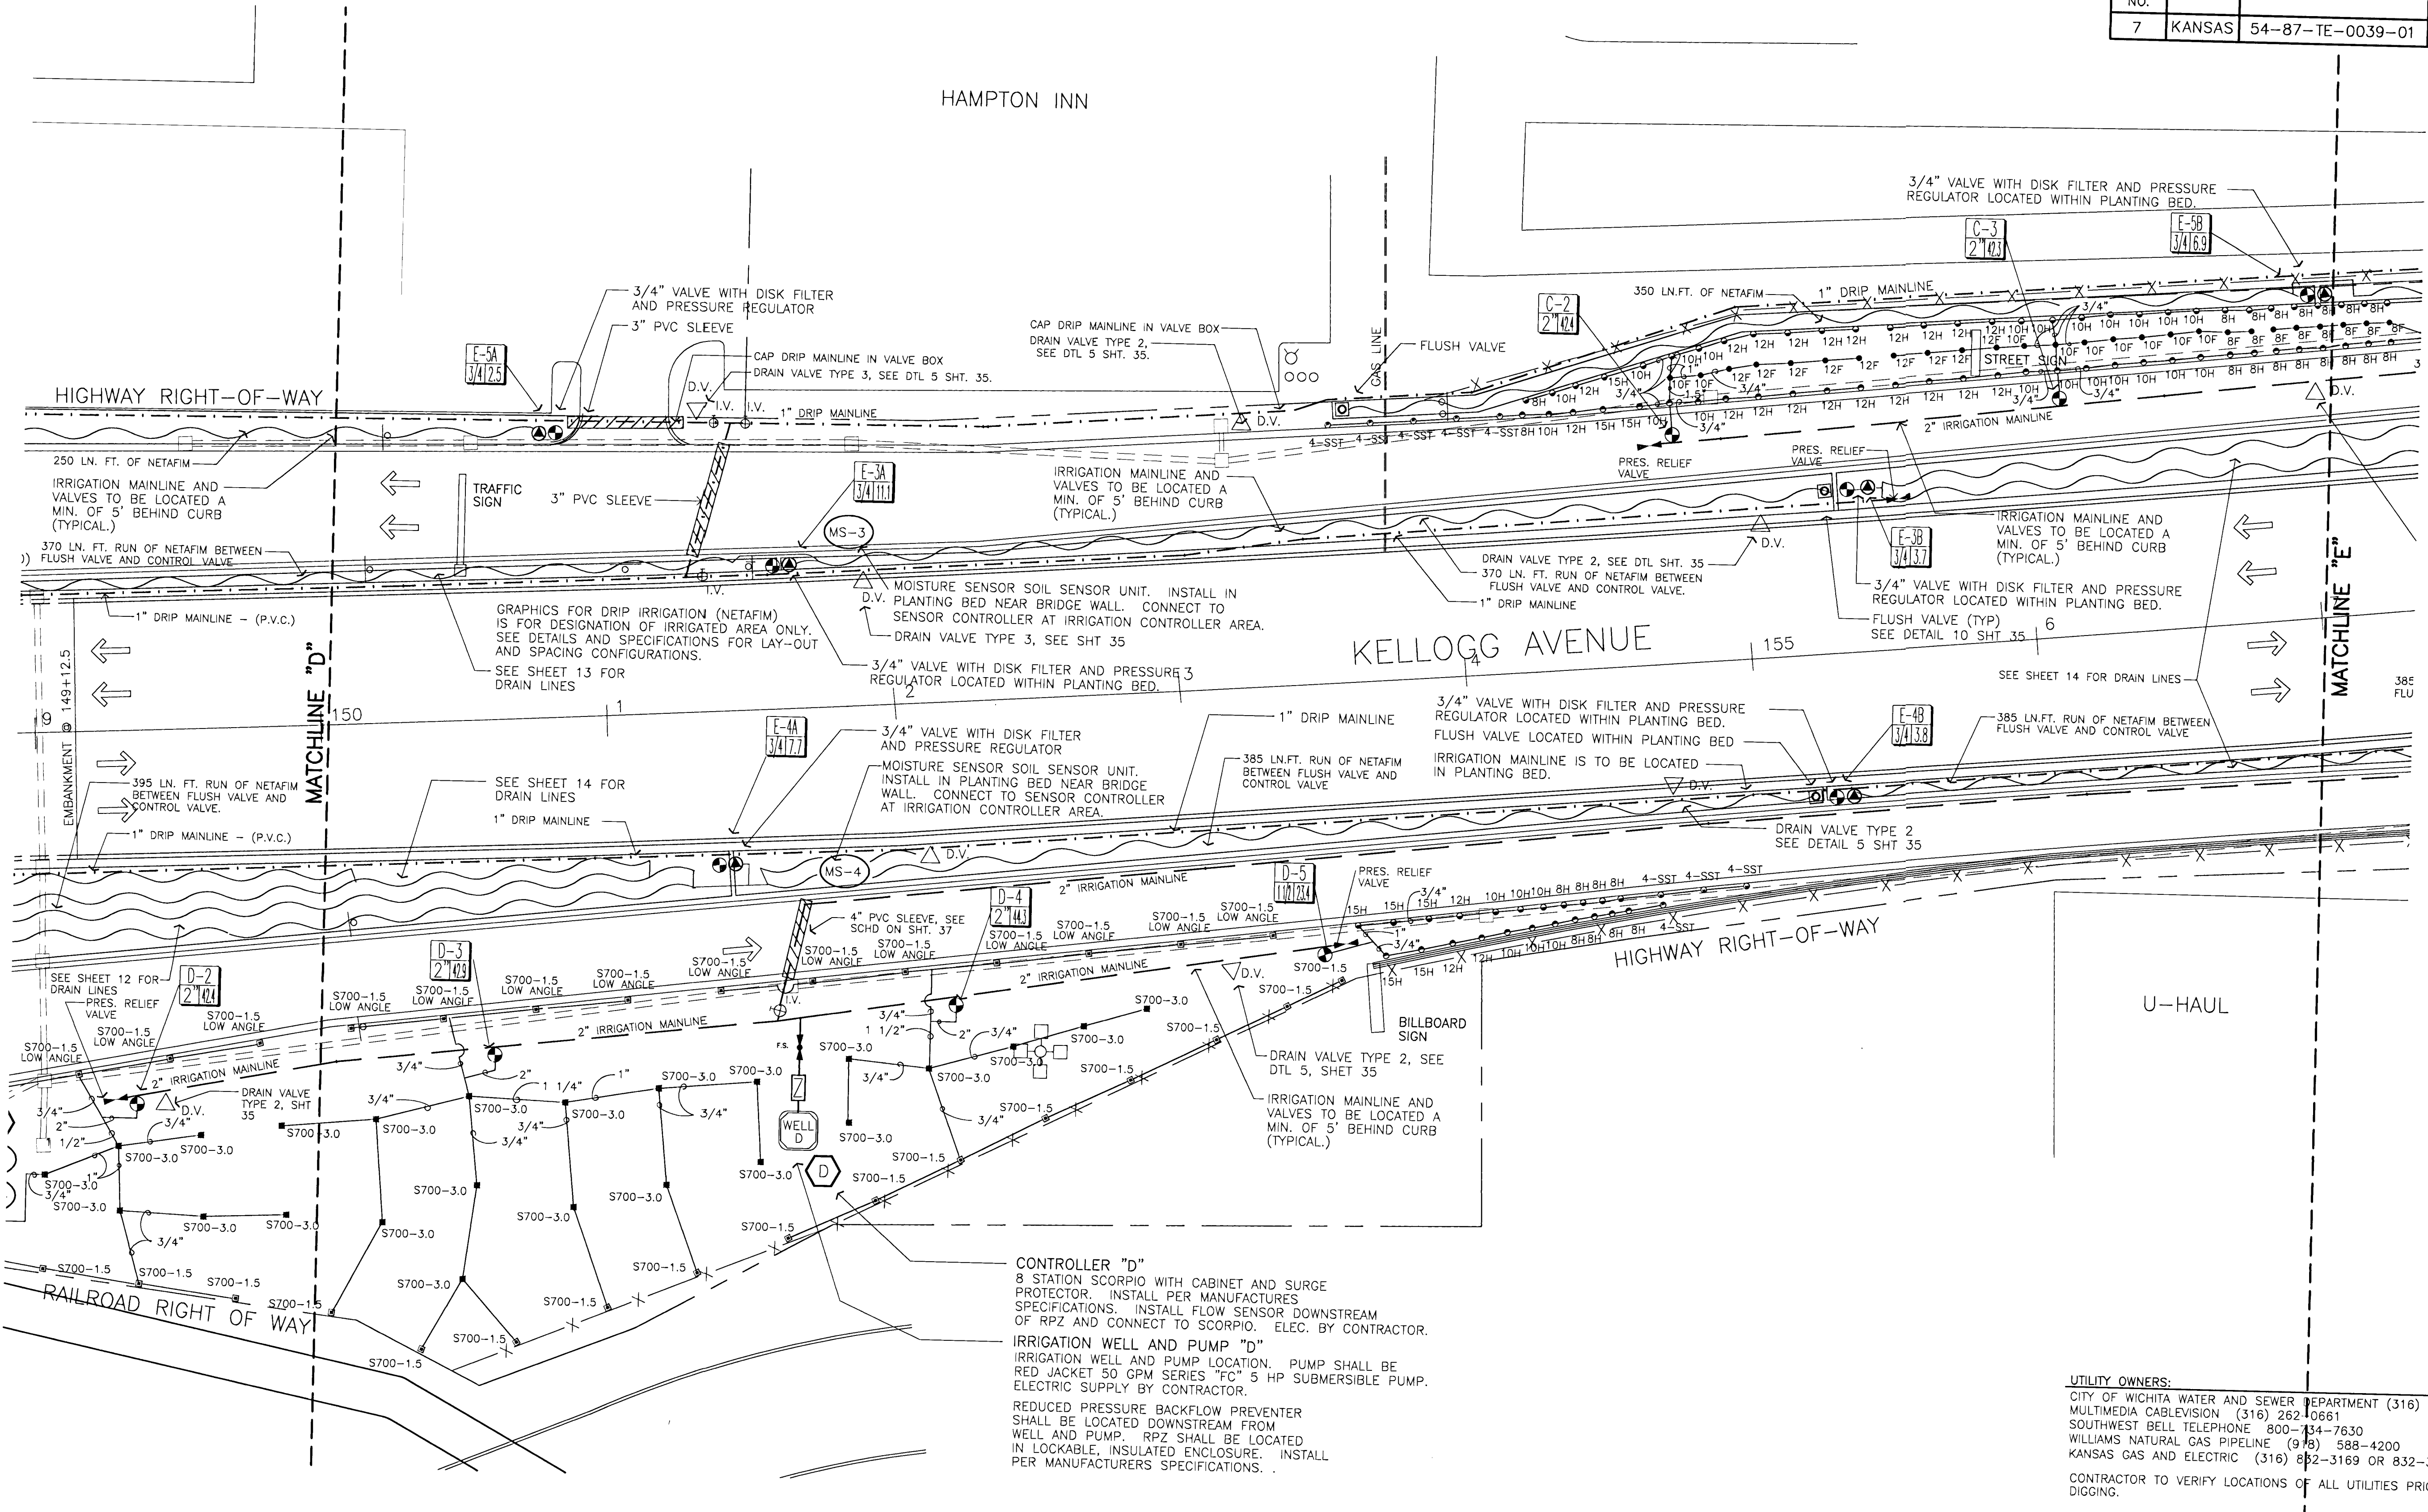

NOTE:
SEE SHEETS 35 AND 36 FOR IRRIGATION DETAILS
SEE SHEET 37 FOR IRRIGATION NOTES AND LEGEND
SEE SHEET 14 FOR DRAIN TILE LOCATIONS

UTILITY OWNERS:
CITY OF WICHITA WATER AND SEWER DEPARTMENT (316) 268-4908
MULTIMEDIA CABLEVISION (316) 262-0661
SOUTHWEST BELL TELEPHONE 800-334-7630
WILLIAMS NATURAL GAS PIPELINE (918) 588-4200
KANSAS GAS AND ELECTRIC (316) 832-3169 OR 832-3180
CONTRACTOR TO VERIFY LOCATIONS OF ALL UTILITIES PRIOR TO DIGGING.

KANSAS DEPARTMENT OF TRANSPORTATION
KELLOGG AND WEST STREET
STATION 150+00 TO 157+00
IRRIGATION PLAN
PROJECT NO. # 54-87-TE-0039-01

Wilson Darnell Mann
architecture site planning interiors
Wichita, Kansas

DESIGNED BY: WDM, PA
DRAWN BY: SKW
CHECKED BY: LME
DATE: 7/31/97
SHEET 31 OF 43

