



FHWA REG NO.	STATE	PROJECT NO.	YEAR	SHEET NO.	SHEETS
7	KANSAS	54-87-TE-0039-01	1997	32	43

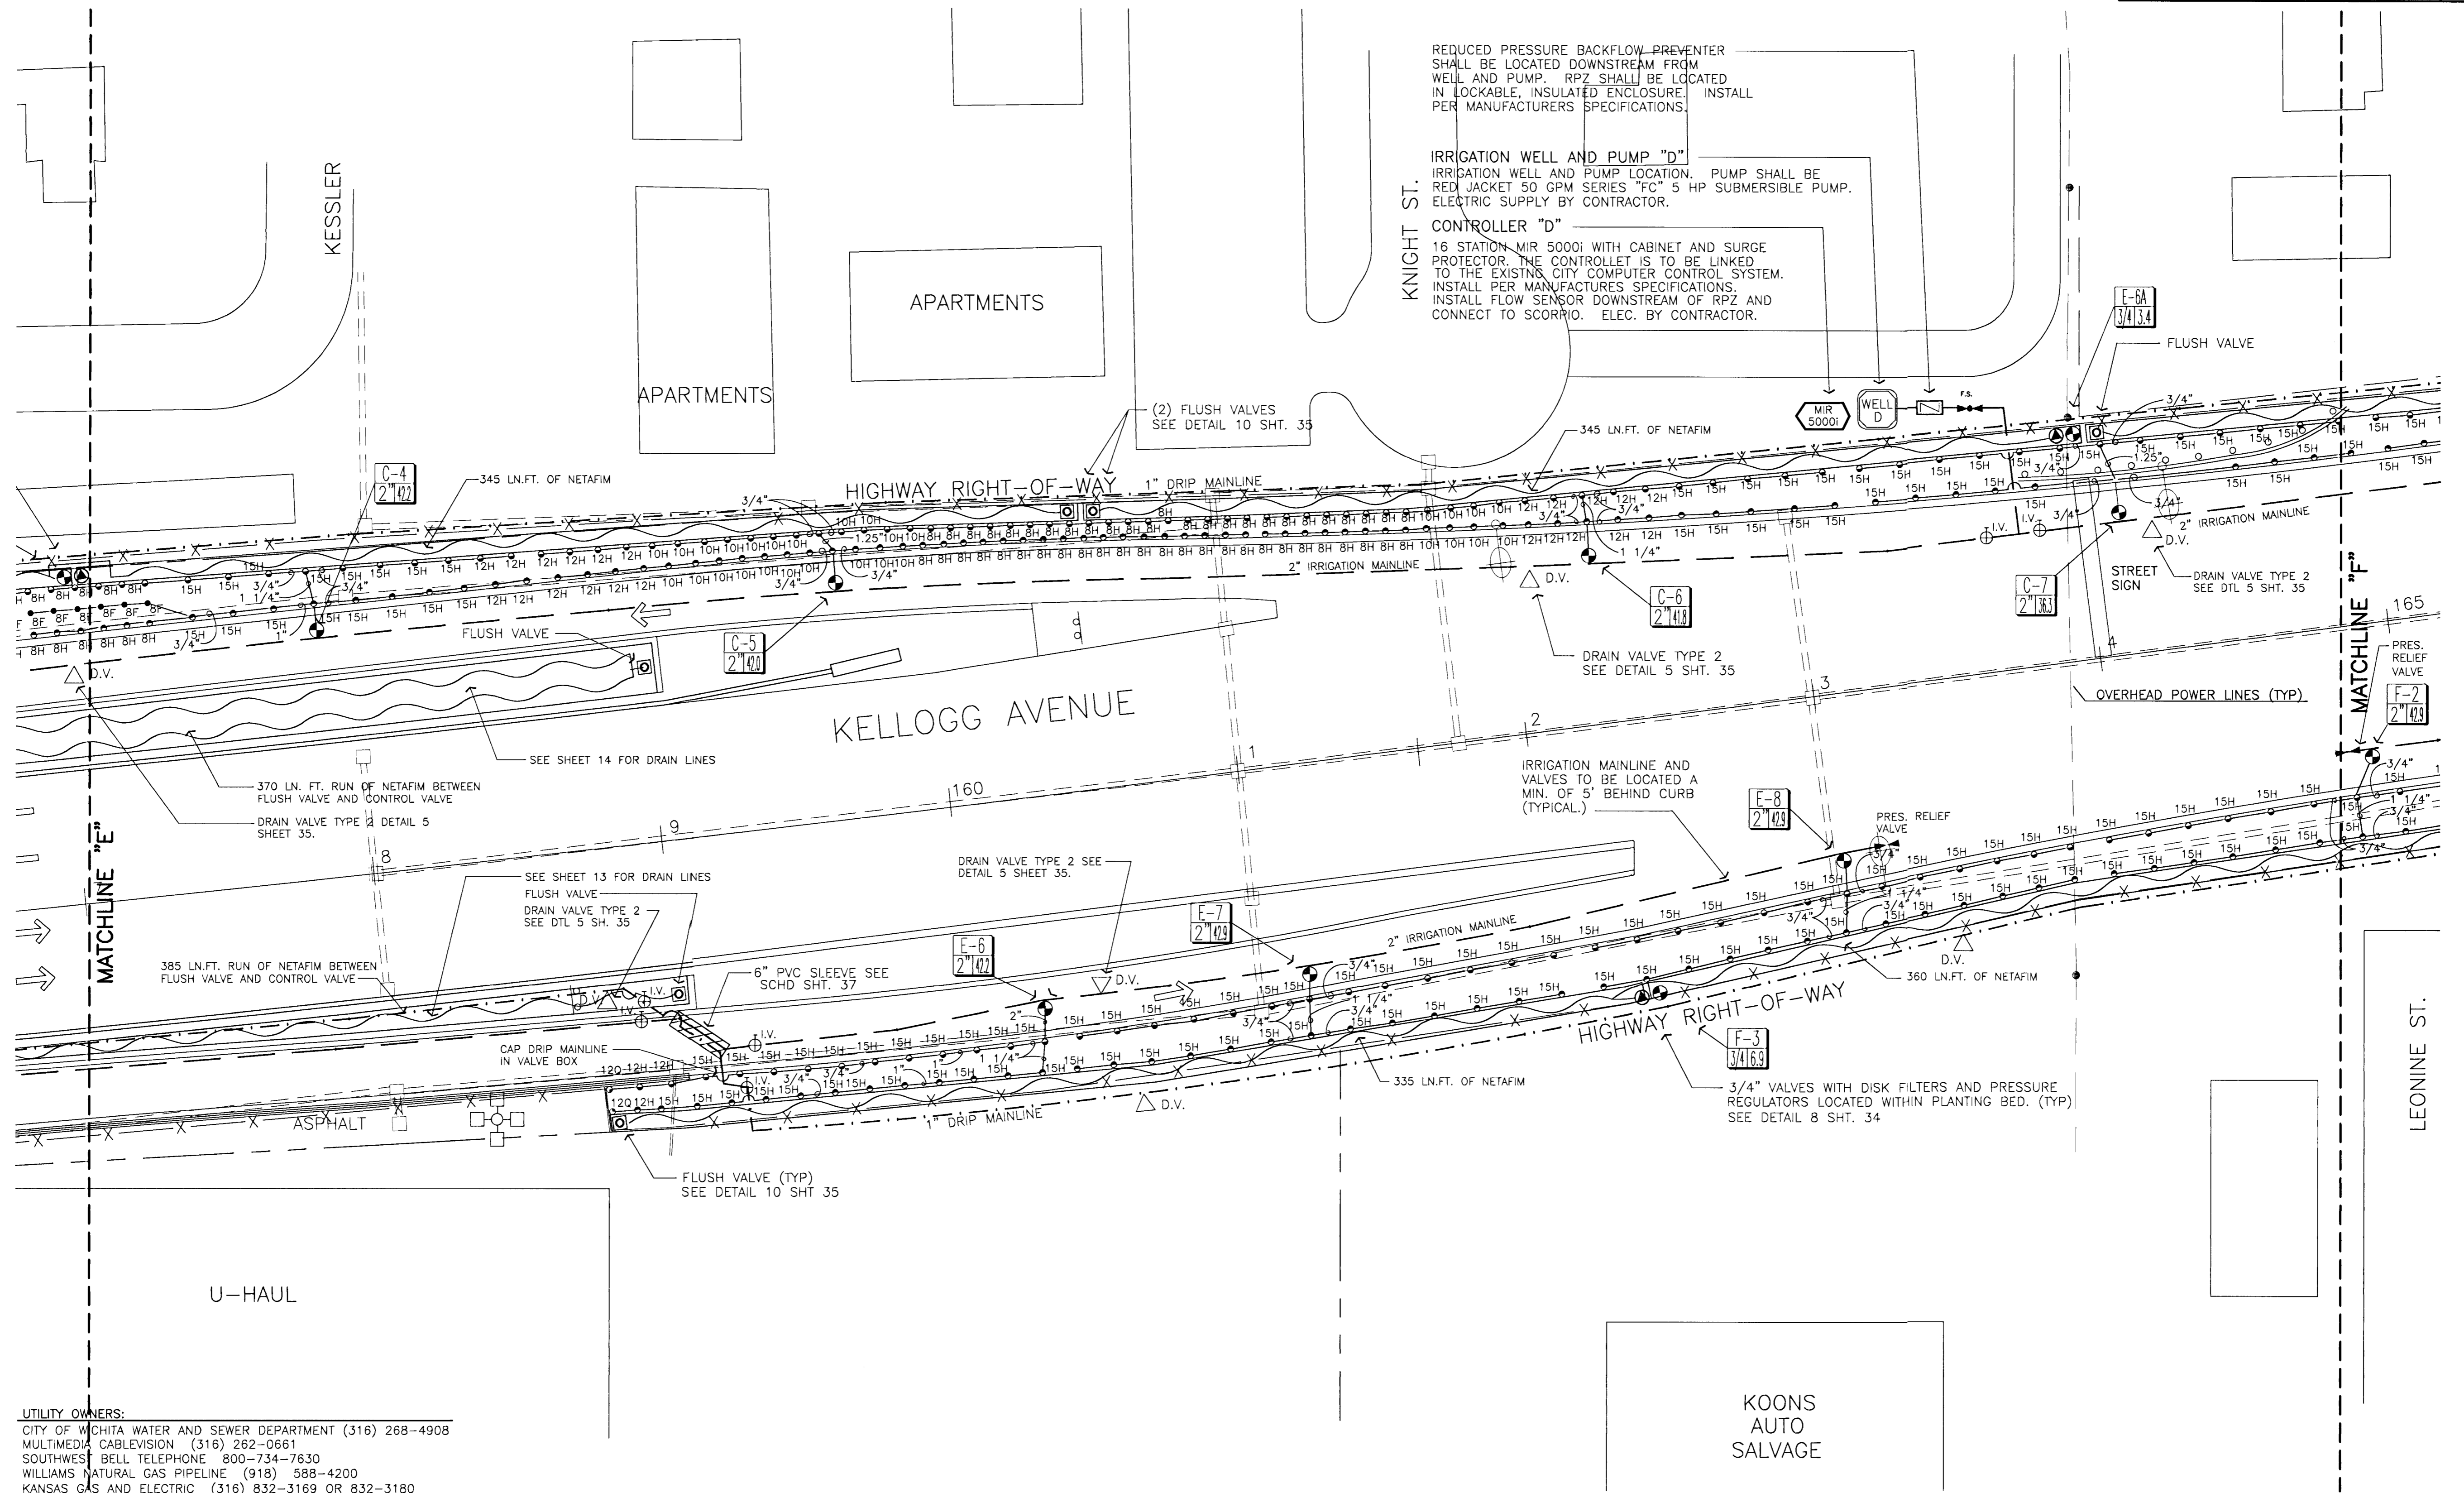

UTILITY OWNERS:  
 CITY OF WICHITA WATER AND SEWER DEPARTMENT (316) 268-4908  
 MULTIMEDIA CABLEVISION (316) 262-0661  
 SOUTHWEST BELL TELEPHONE 800-734-7630  
 WILLIAMS NATURAL GAS PIPELINE (918) 588-4200  
 KANSAS GAS AND ELECTRIC (316) 832-3169 OR 832-3180

CONTRACTOR TO VERIFY LOCATIONS OF ALL UTILITIES PRIOR TO DIGGING.

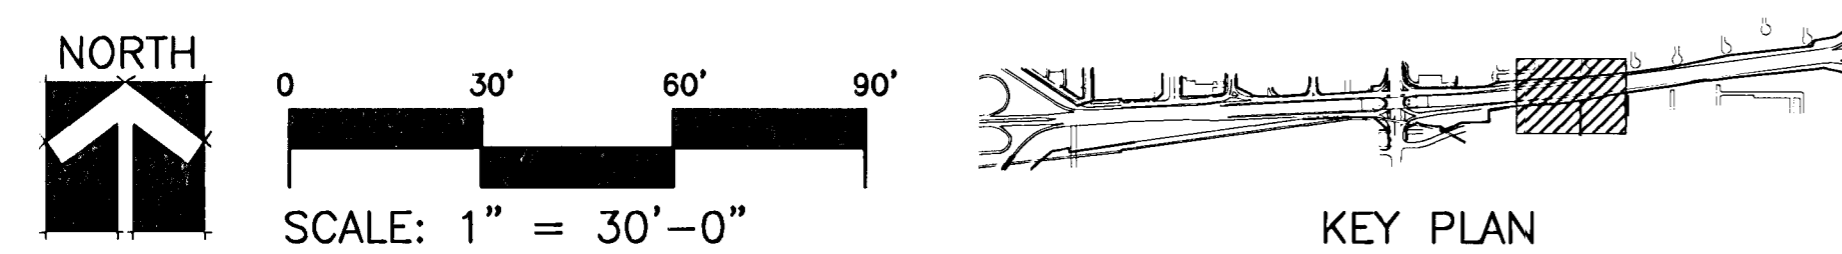


NOTE:  
 SEE SHEETS 35 AND 36 FOR IRRIGATION DETAILS  
 SEE SHEET 37 FOR IRRIGATION NOTES AND LEGEND  
 SEE SHEET 15 FOR DRAIN TILE LOCATIONS

KANSAS DEPARTMENT OF TRANSPORTATION  
 KELLOGG AND WEST STREET  
 STATION 157+00 TO 165+00  
 IRRIGATION PLAN  
 PROJECT NO. #70122-1

**Wilson Darnell Mann**  
 architecture site planning interiors  
 Wichita, Kansas

DESIGNED BY: WDM, PA      CHECKED BY: LME  
 DRAWN BY: SKW      DATE: 7/31/97      SHEET 32 OF 43

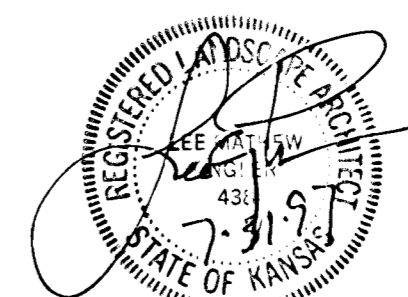

13-06  
 08/19/1997  
 K:\94082\RRIG\LI-6  
 E:\94082\MAINBASE E:\94082\RRIG