

SOUTHEAST BOOSTER PUMP STATION STANDBY POWER GENERATION


C.O.W. PROJECT NO. 448-2021-004719

O.R.G. NO. 54251508

CITY OF WICHITA, KANSAS

GARY JANZEN, P.E. - CITY ENGINEER


INDEX TO DRAWINGS	
SHEET NO.	DESCRIPTION
G000	COVER SHEET
V001	SURVEY
C001	CIVIL GENERAL NOTES
CD101	DEMOLITION PLAN
CS101	SITE PLAN
CP101	JOINTING PLAN
CG101	GRADING PLAN
CG102	EROSION CONTROL PLAN
CG501	EROSION CONTROL DETAILS
CG502	EROSION CONTROL DETAILS
CG503	EROSION CONTROL DETAILS
CG504	EROSION CONTROL DETAILS
CG505	EROSION CONTROL DETAILS
CG506	SITE DETAILS
LP101	PLANTING PLAN
DP101	CHLORINE ANALYZER PLAN AND SECTION
S001	STRUCTURAL GENERAL NOTES
S101	FRAMING PLAN
S501	STRUCTURAL DETAILS
M001	MECHANICAL COVER SHEET
MD101	MECHANICAL DEMOLITION FLOOR PLAN
MH101	MECHANICAL FLOOR PLAN
M601	MECHANICAL SCHEDULES
E001	ELECTRICAL LEAD SHEET
E101	DEMOLITION FLOOR PLAN
E110	ELECTRICAL SITE PLAN
E111	POWER FLOOR PLAN
E121	LIGHTING FLOOR PLAN
E501	ELECTRICAL DETAILS
E601	ELECTRICAL ONE-LINE DIAGRAM DEMOLITION
E602	ELECTRICAL ONE-LINE DIAGRAM PROPOSED
E611	ELECTRICAL SCHEDULES

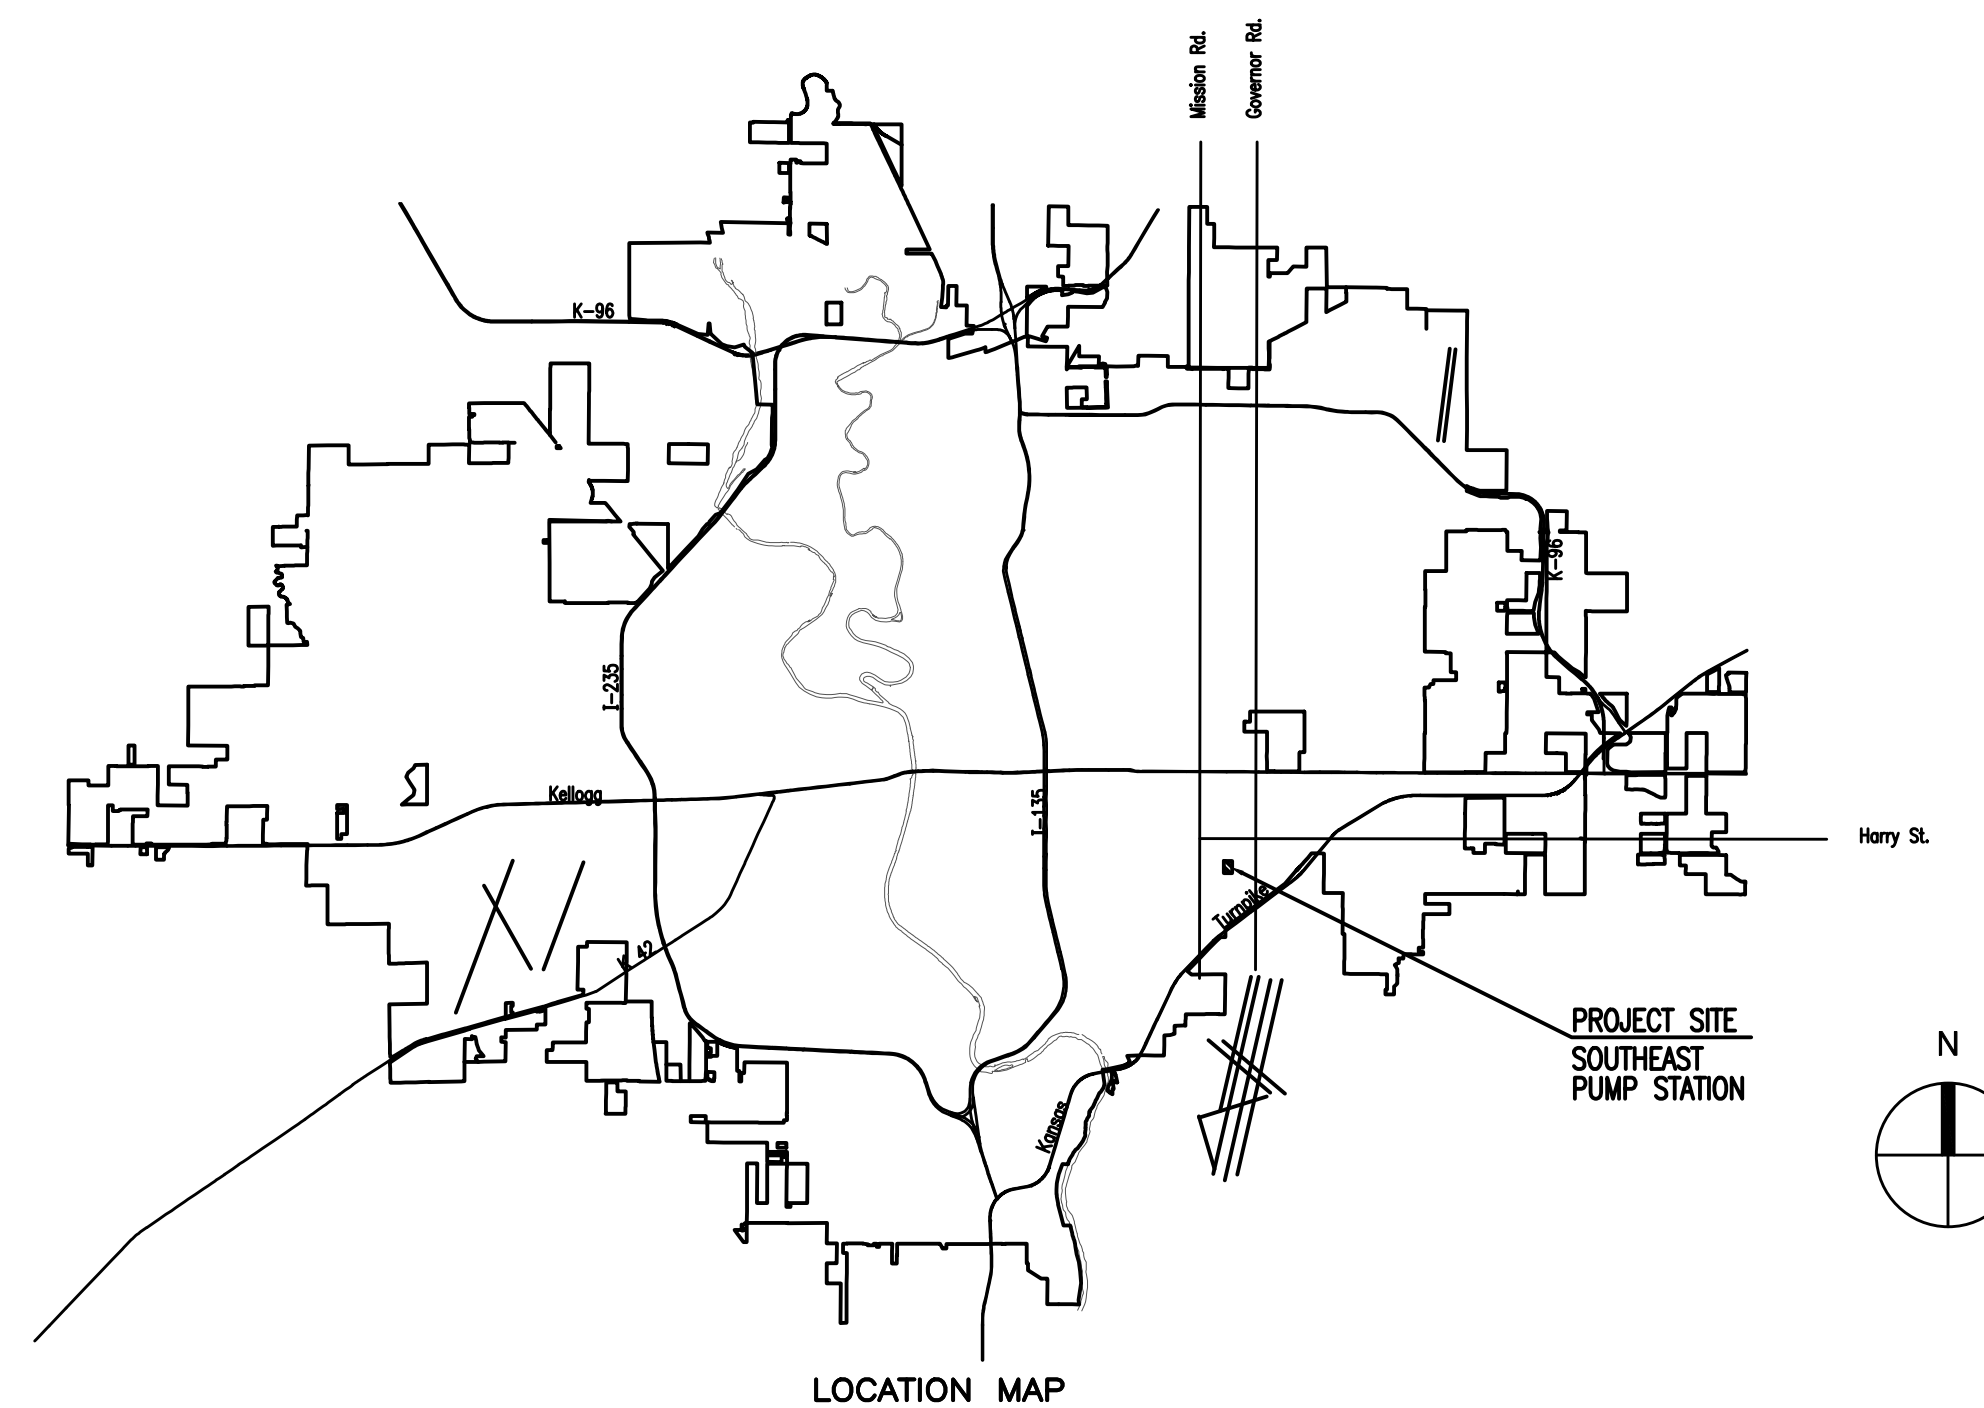

MARCH 2021

PLANS PREPARED BY
PROFESSIONAL ENGINEERING CONSULTANTS, P.A.
ENGINEERS
WICHITA, KANSAS

Saved: 02-24-2021 10:52:08 AM by JOSE RAMOS
 Plot Scale: 1:5.379008 03-04-2021 11:58:02 AM by JOSE RAMOS
 U:\Wichita-Facility\180537\000\Elec\Drawings\180537-000 - G00

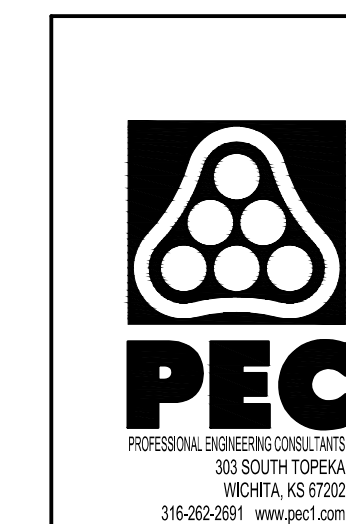

4			
3			
2			
1	CONSTRUCTION DOCUMENTS		03-04-21
No.	Revision	By	Date
CITY OF WICHITA, KANSAS			
COVER SHEET			
STANDBY POWER GENERATION - SOUTHEAST PUMP STATION			
Professional Engineering Consultants, P.A. 303 S. TOPEKA • WICHITA, KANSAS 67202 316-262-2691 • FAX 316-262-3003			
Designed by	DCG	Job No.	180537-000
Drawn by	JAR	Checked by	DCG
Date	MARCH 2021	Dwg No.	G000