



A WALL FRAMING PLAN

0' 2' 4' 6' 10'

SCALE: 1/4" = 1'-0"

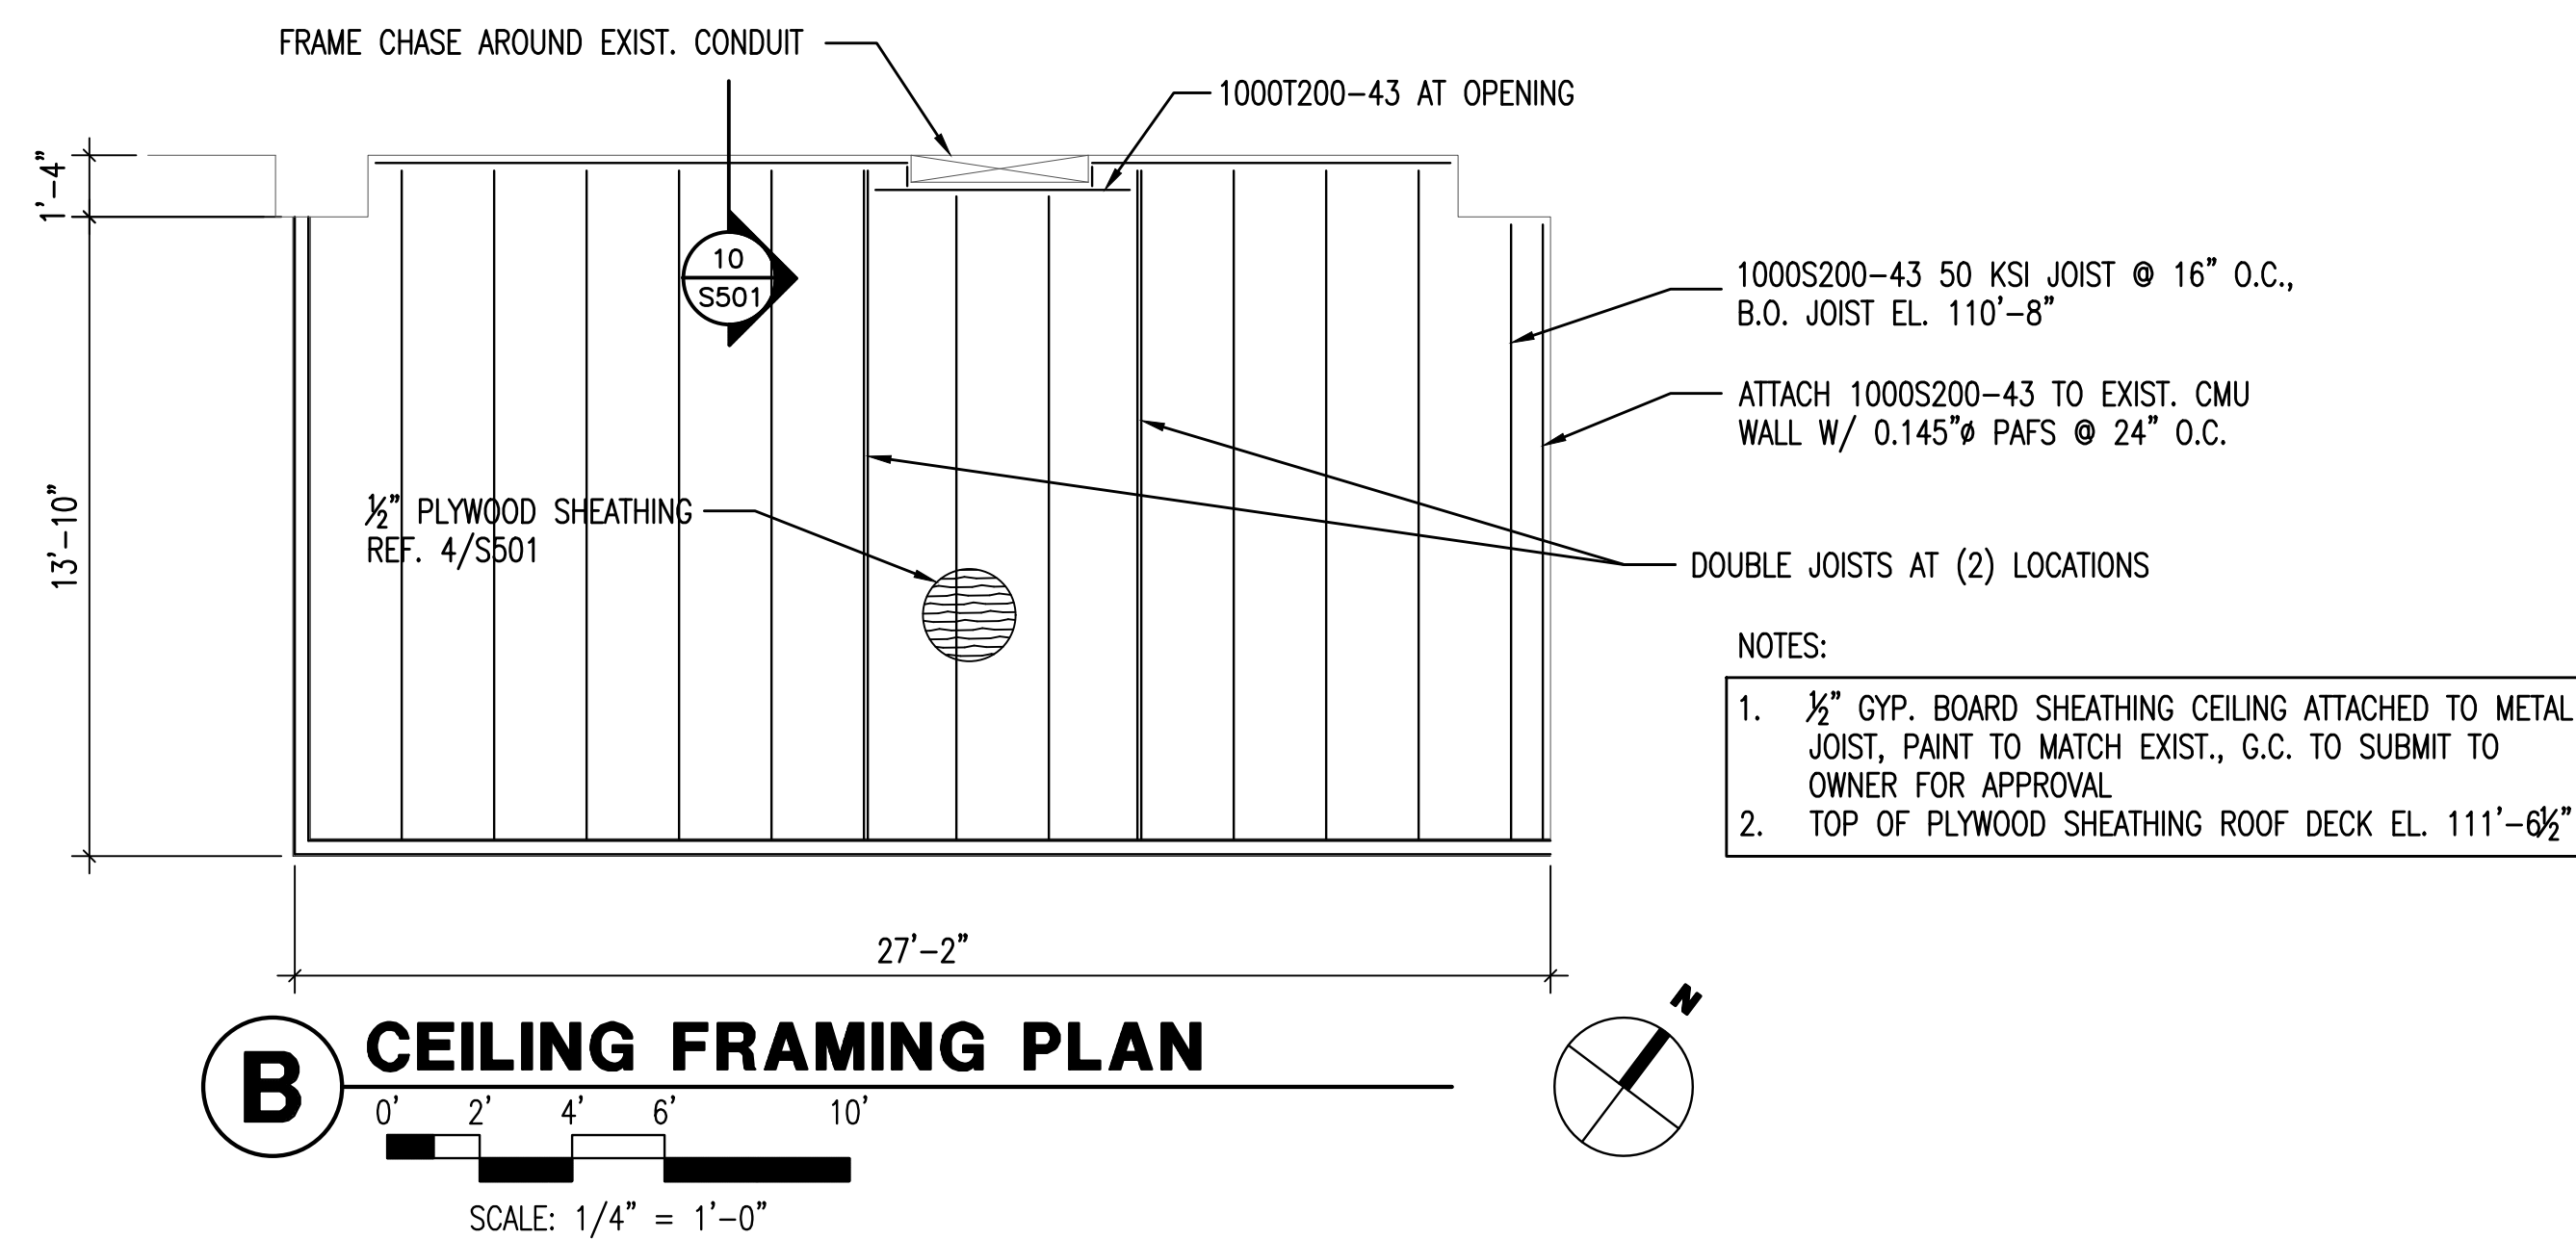

Saved: 03-04-2021 3:24:03 PM by DAVID.CARPENTER
 Plot Scale: 1:1 03-04-2021 3:36:03 PM by TYLER JACOBS
 U:\wchita-facil\2018\180537\000\Struct\Drawings\CD's\180537 - S101

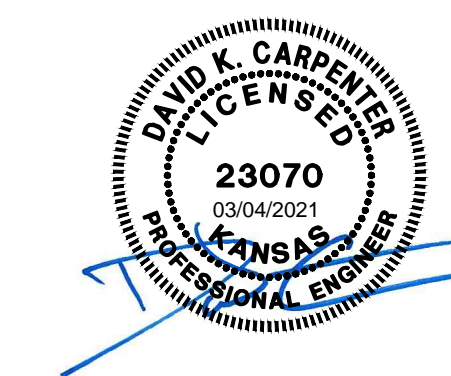

4			
3			
2			
1	CONSTRUCTION DOCUMENTS		03-04-21
No.	Revision	By	Date
CITY OF WICHITA, KANSAS			
FRAMING PLANS			
STANDBY POWER GENERATION - SOUTHEAST PUMP STATION			
Professional Engineering Consultants, P.A. 303 S. TOPEKA • WICHITA, KANSAS 67202 316-262-2691 • FAX 316-262-3003			
Designed by DKC	Job No. 180537-000	Dwg No. S101	
Drawn by TAJ	Checked by	Date MARCH 2021	