



FHWA REGION NO.	STATE	PROJECT NO.	FISCAL YEAR	SHEET NO.	TOTAL SHEETS
7	KANSAS	U-0639-01	2017	28	58

HSIP-N063(801)

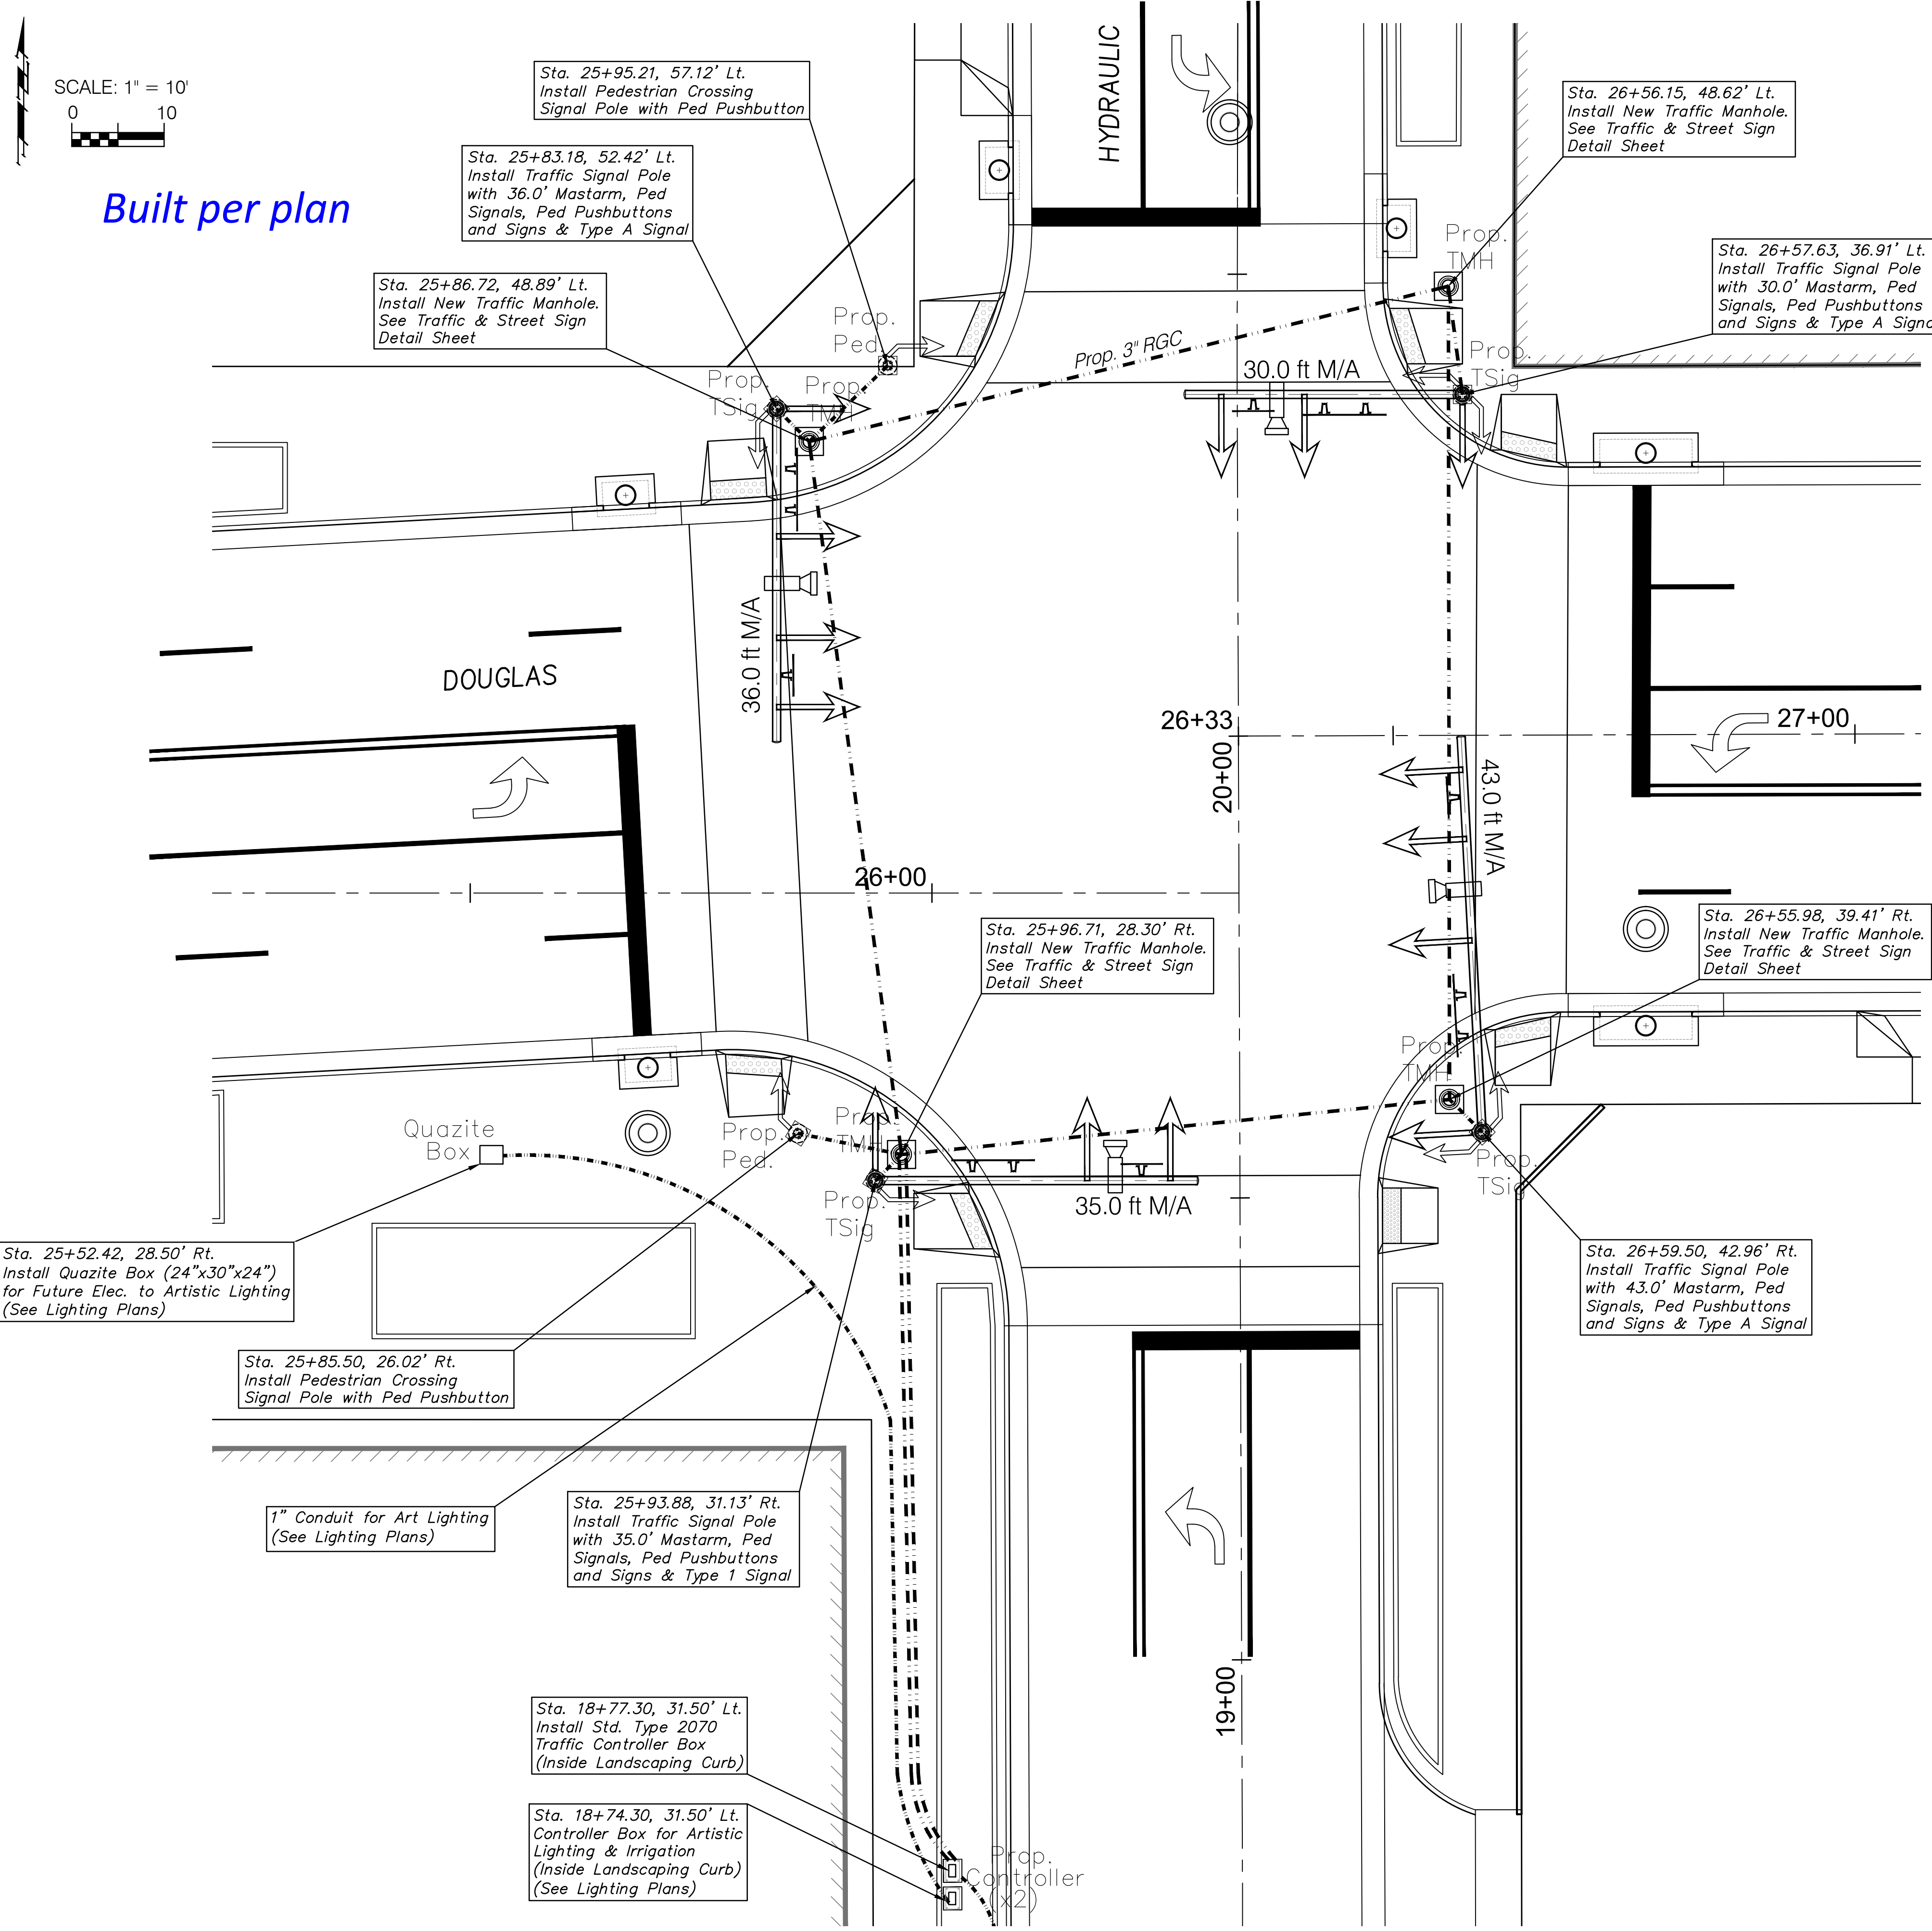

Built per plan

SCALE: 1" = 10'

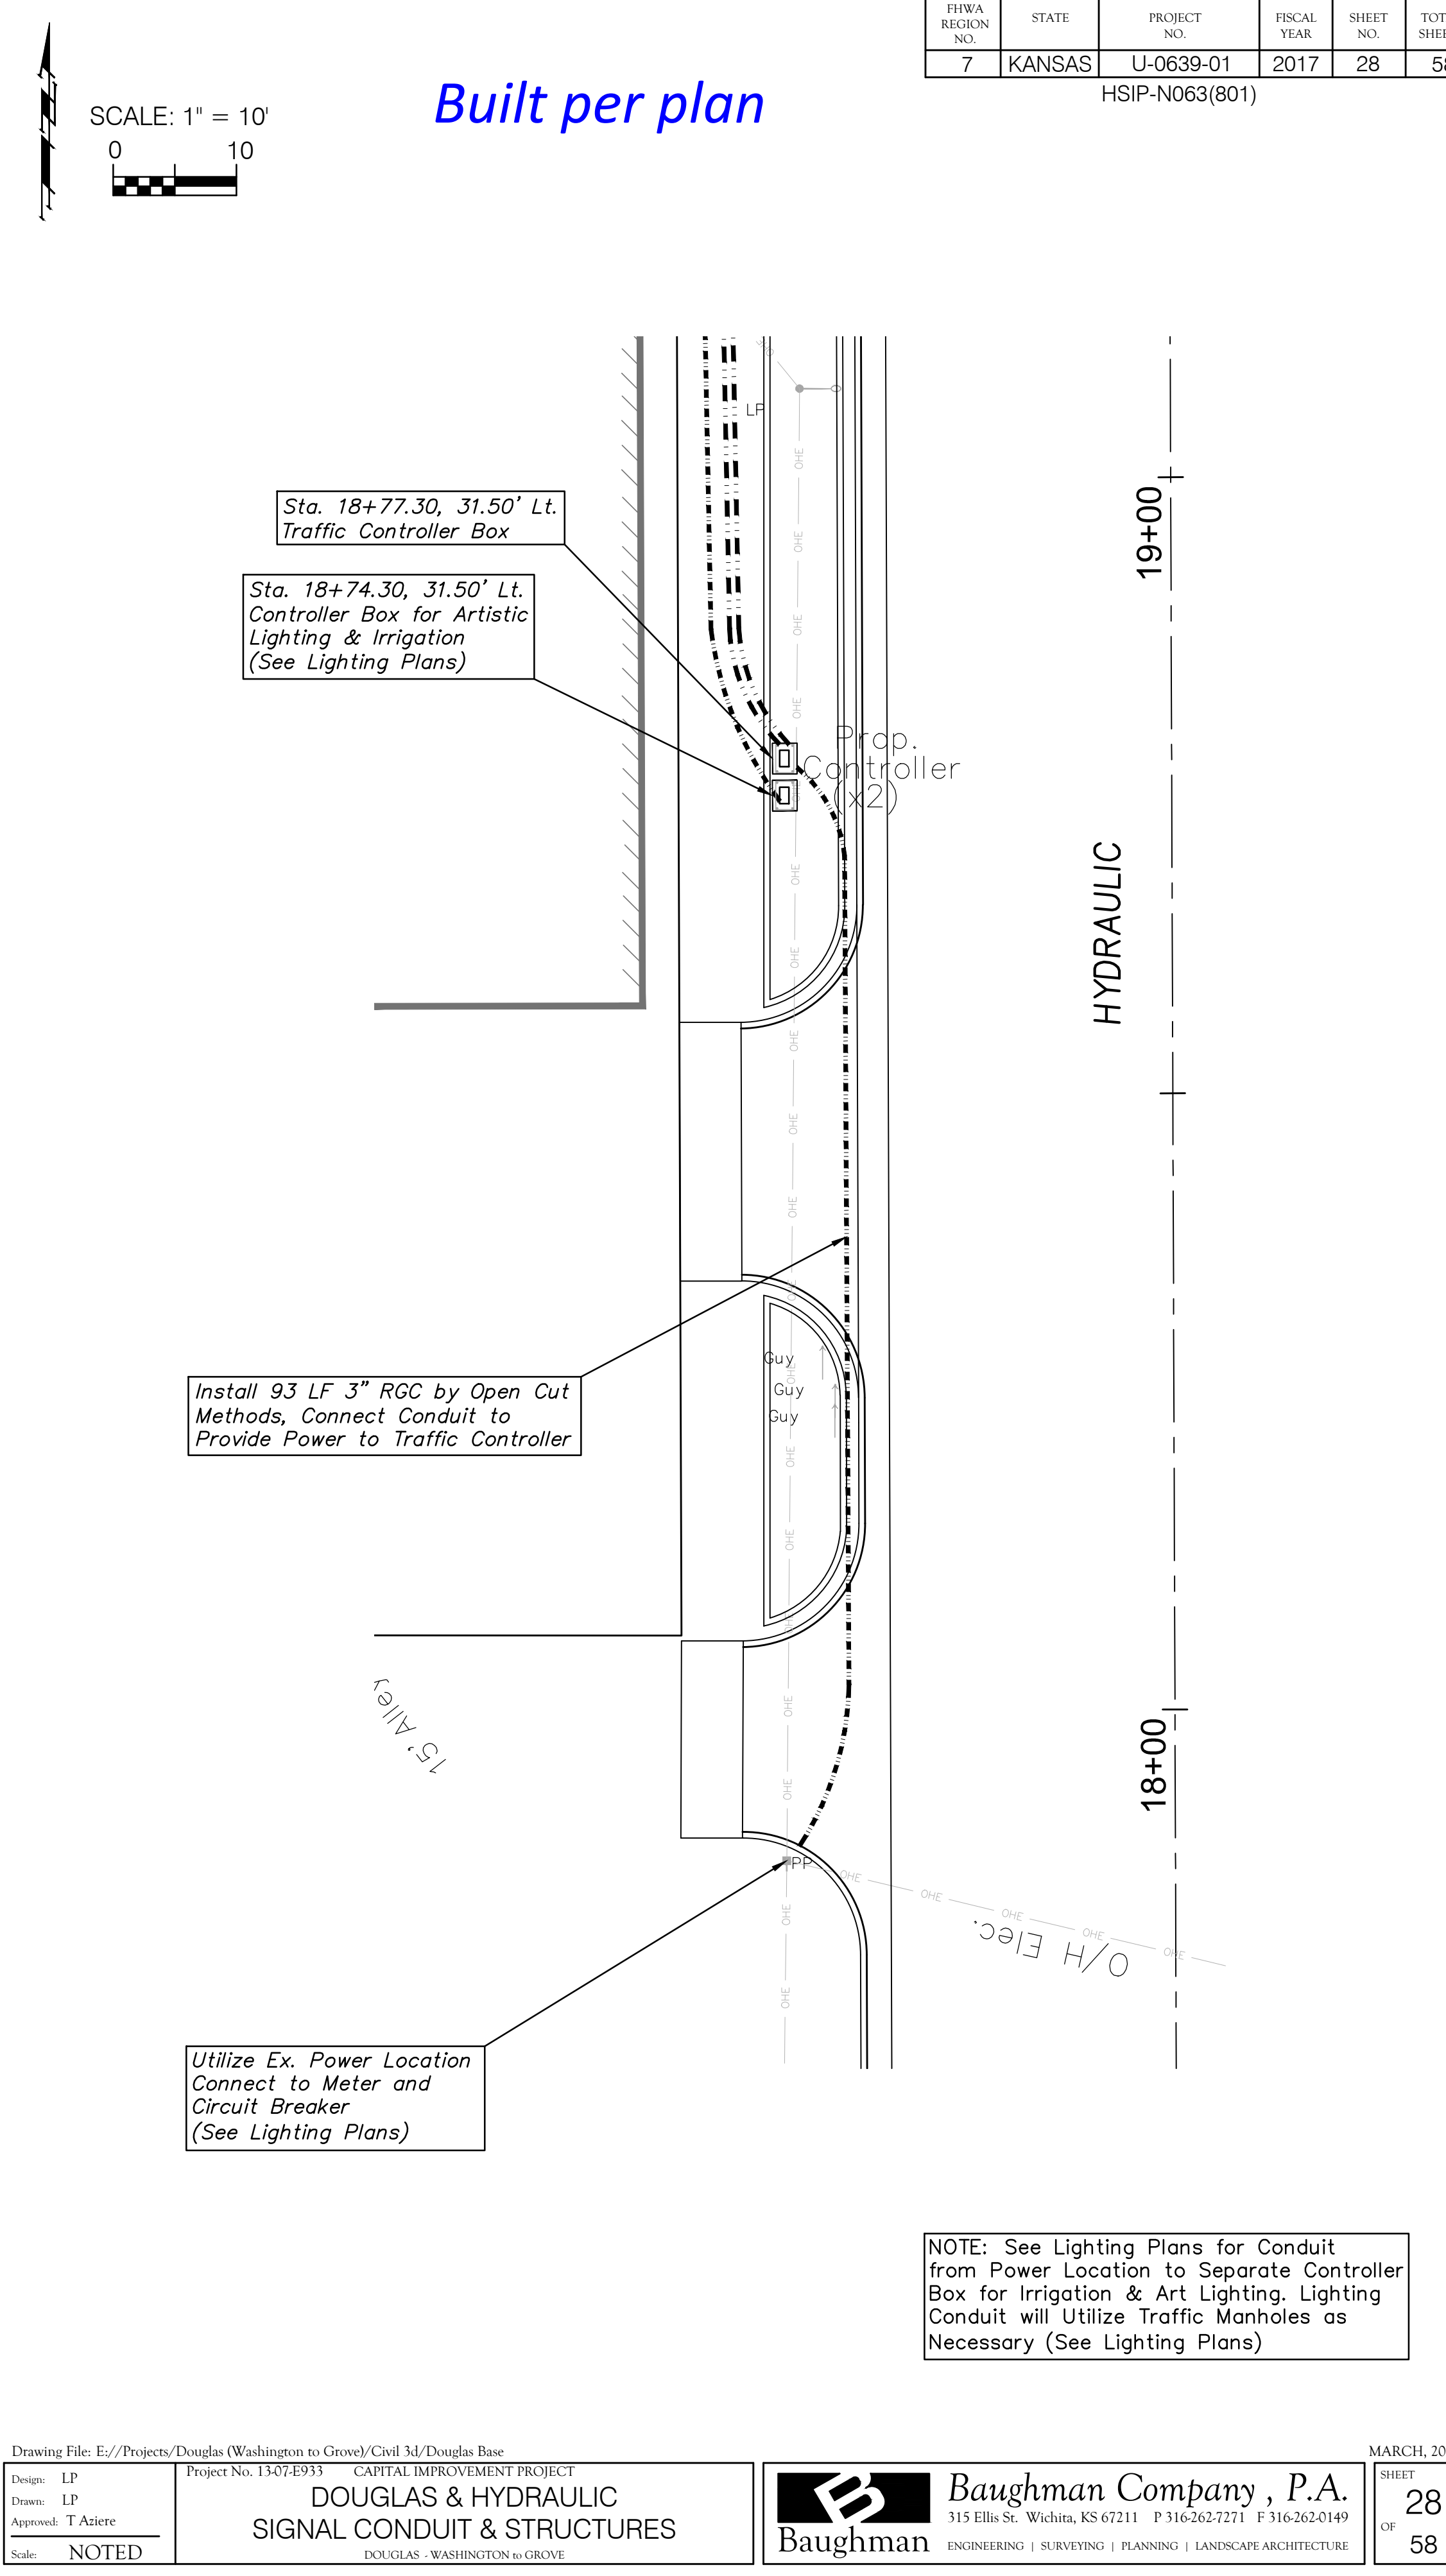

Built per plan

SCALE: 1" = 10'

NOTE: See Lighting Plans for Conduit from Power Location to Separate Controller Box for Irrigation & Art Lighting. Lighting Conduit will Utilize Traffic Manholes as Necessary (See Lighting Plans)