
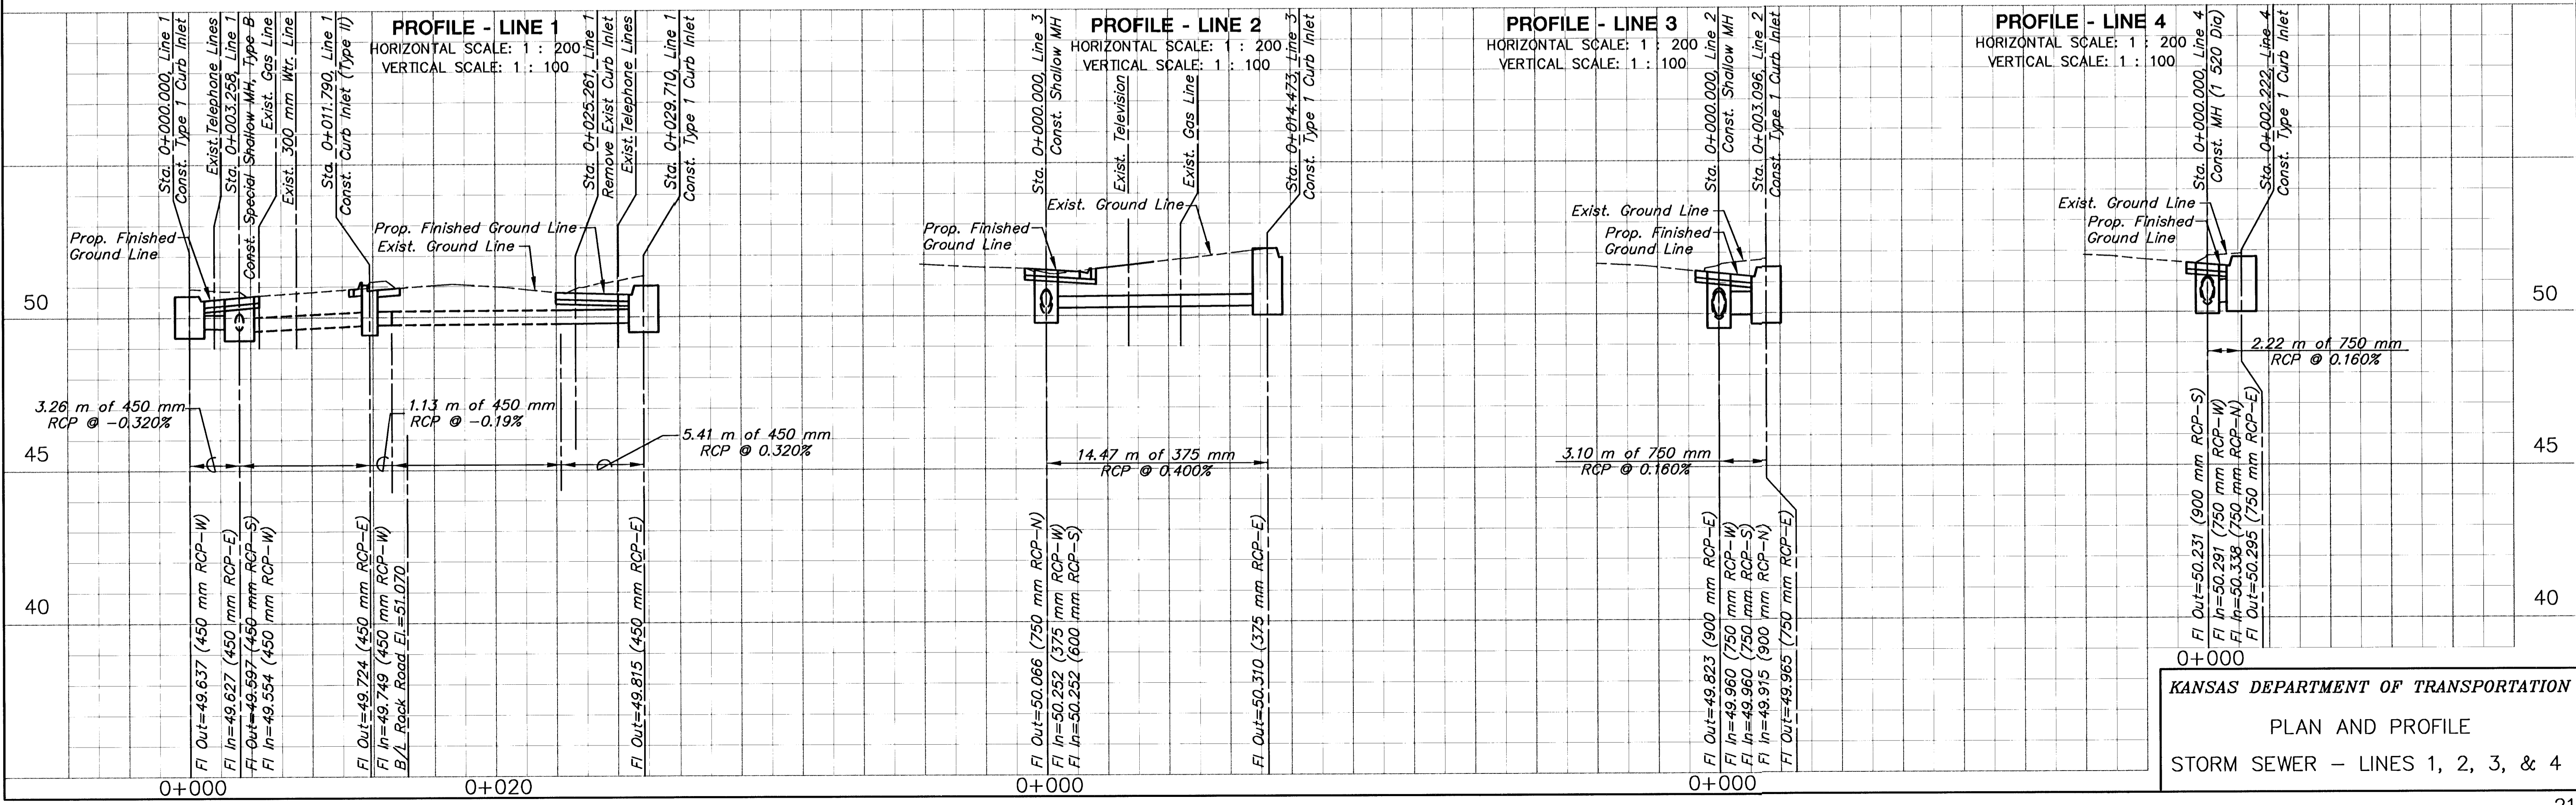


FHWA REG NO.	STATE	PROJECT NO.	YEAR	SHEET NO.	TOTAL SHEETS
7	KANSAS	87 N-0196-01	2001	21	55

BY	DATE

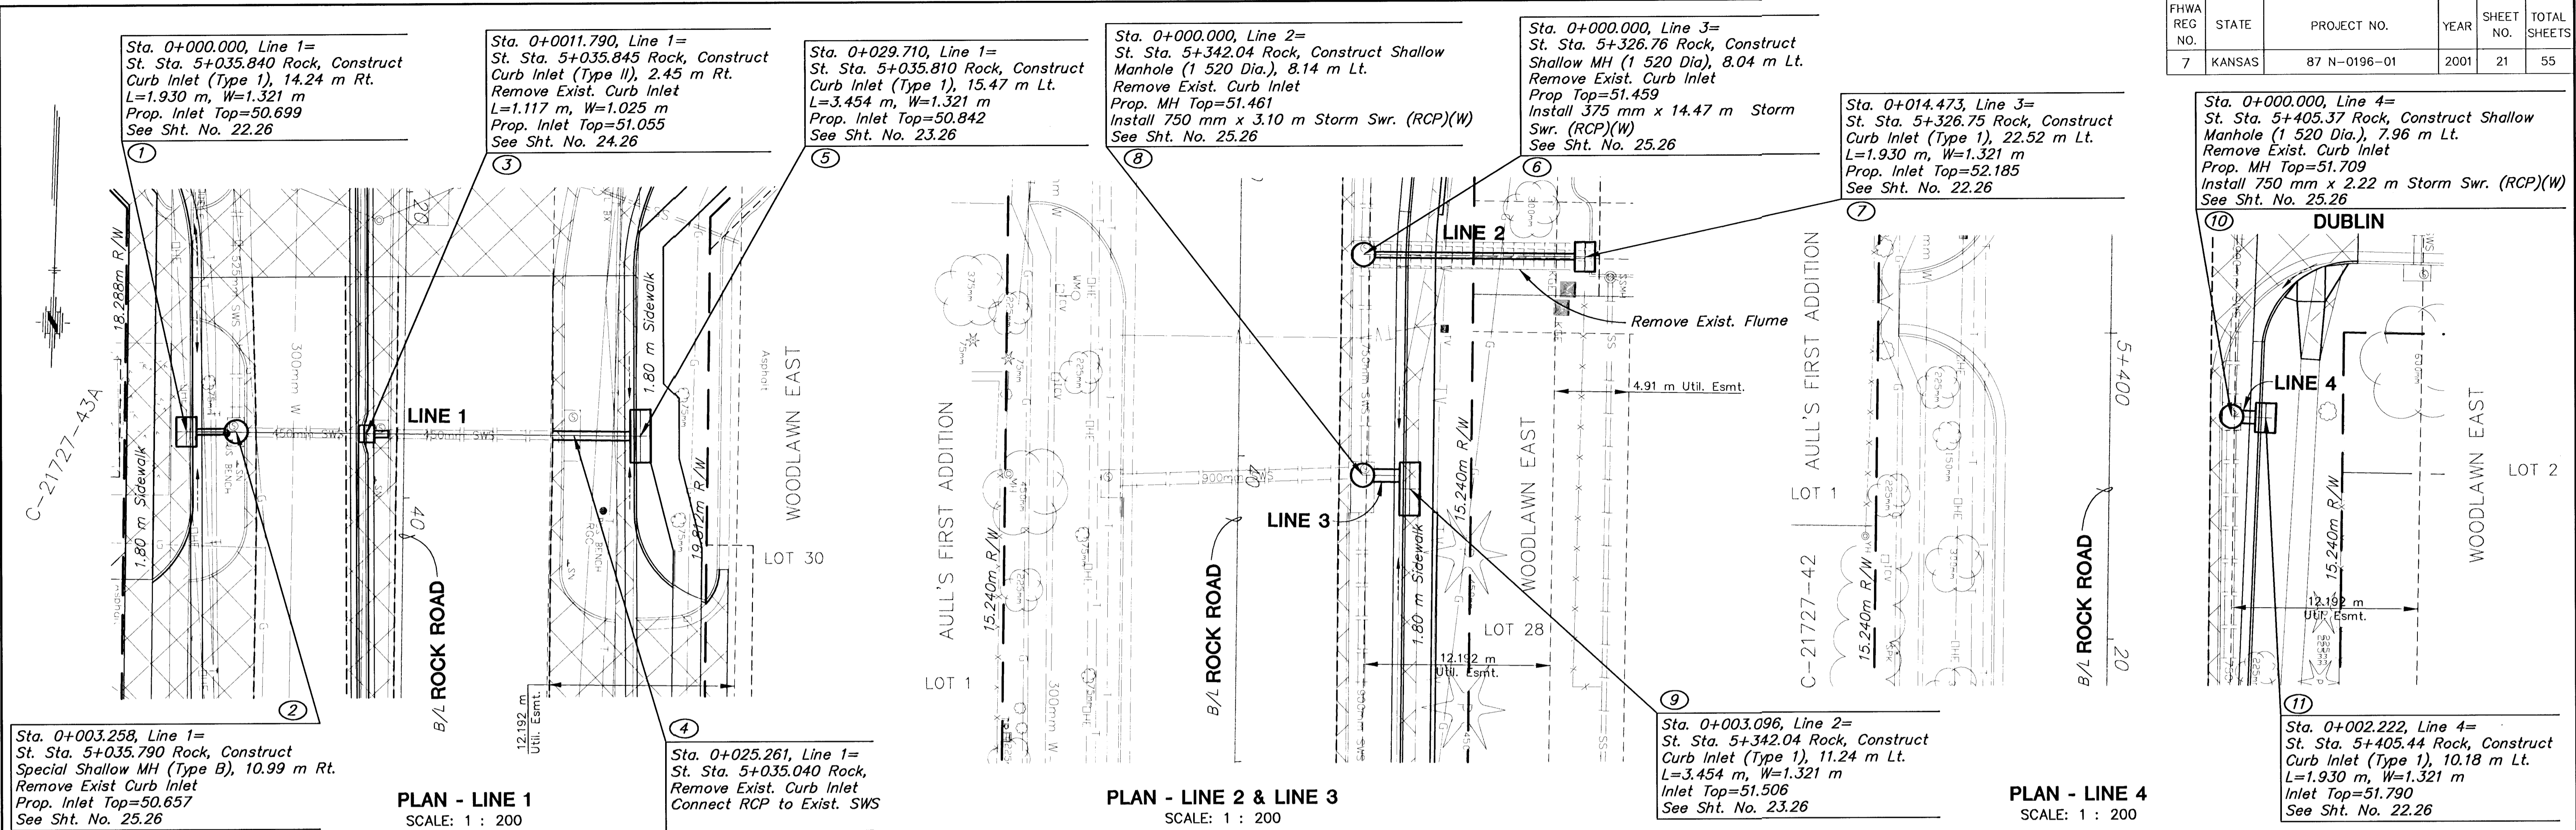

KANSAS DEPARTMENT OF TRANSPORTATION  
PLAN AND PROFILE  
STORM SEWER - LINES 1, 2, 3, & 4