




G:\CIVIL\98026\GRADE\PHASE3\GRADE2

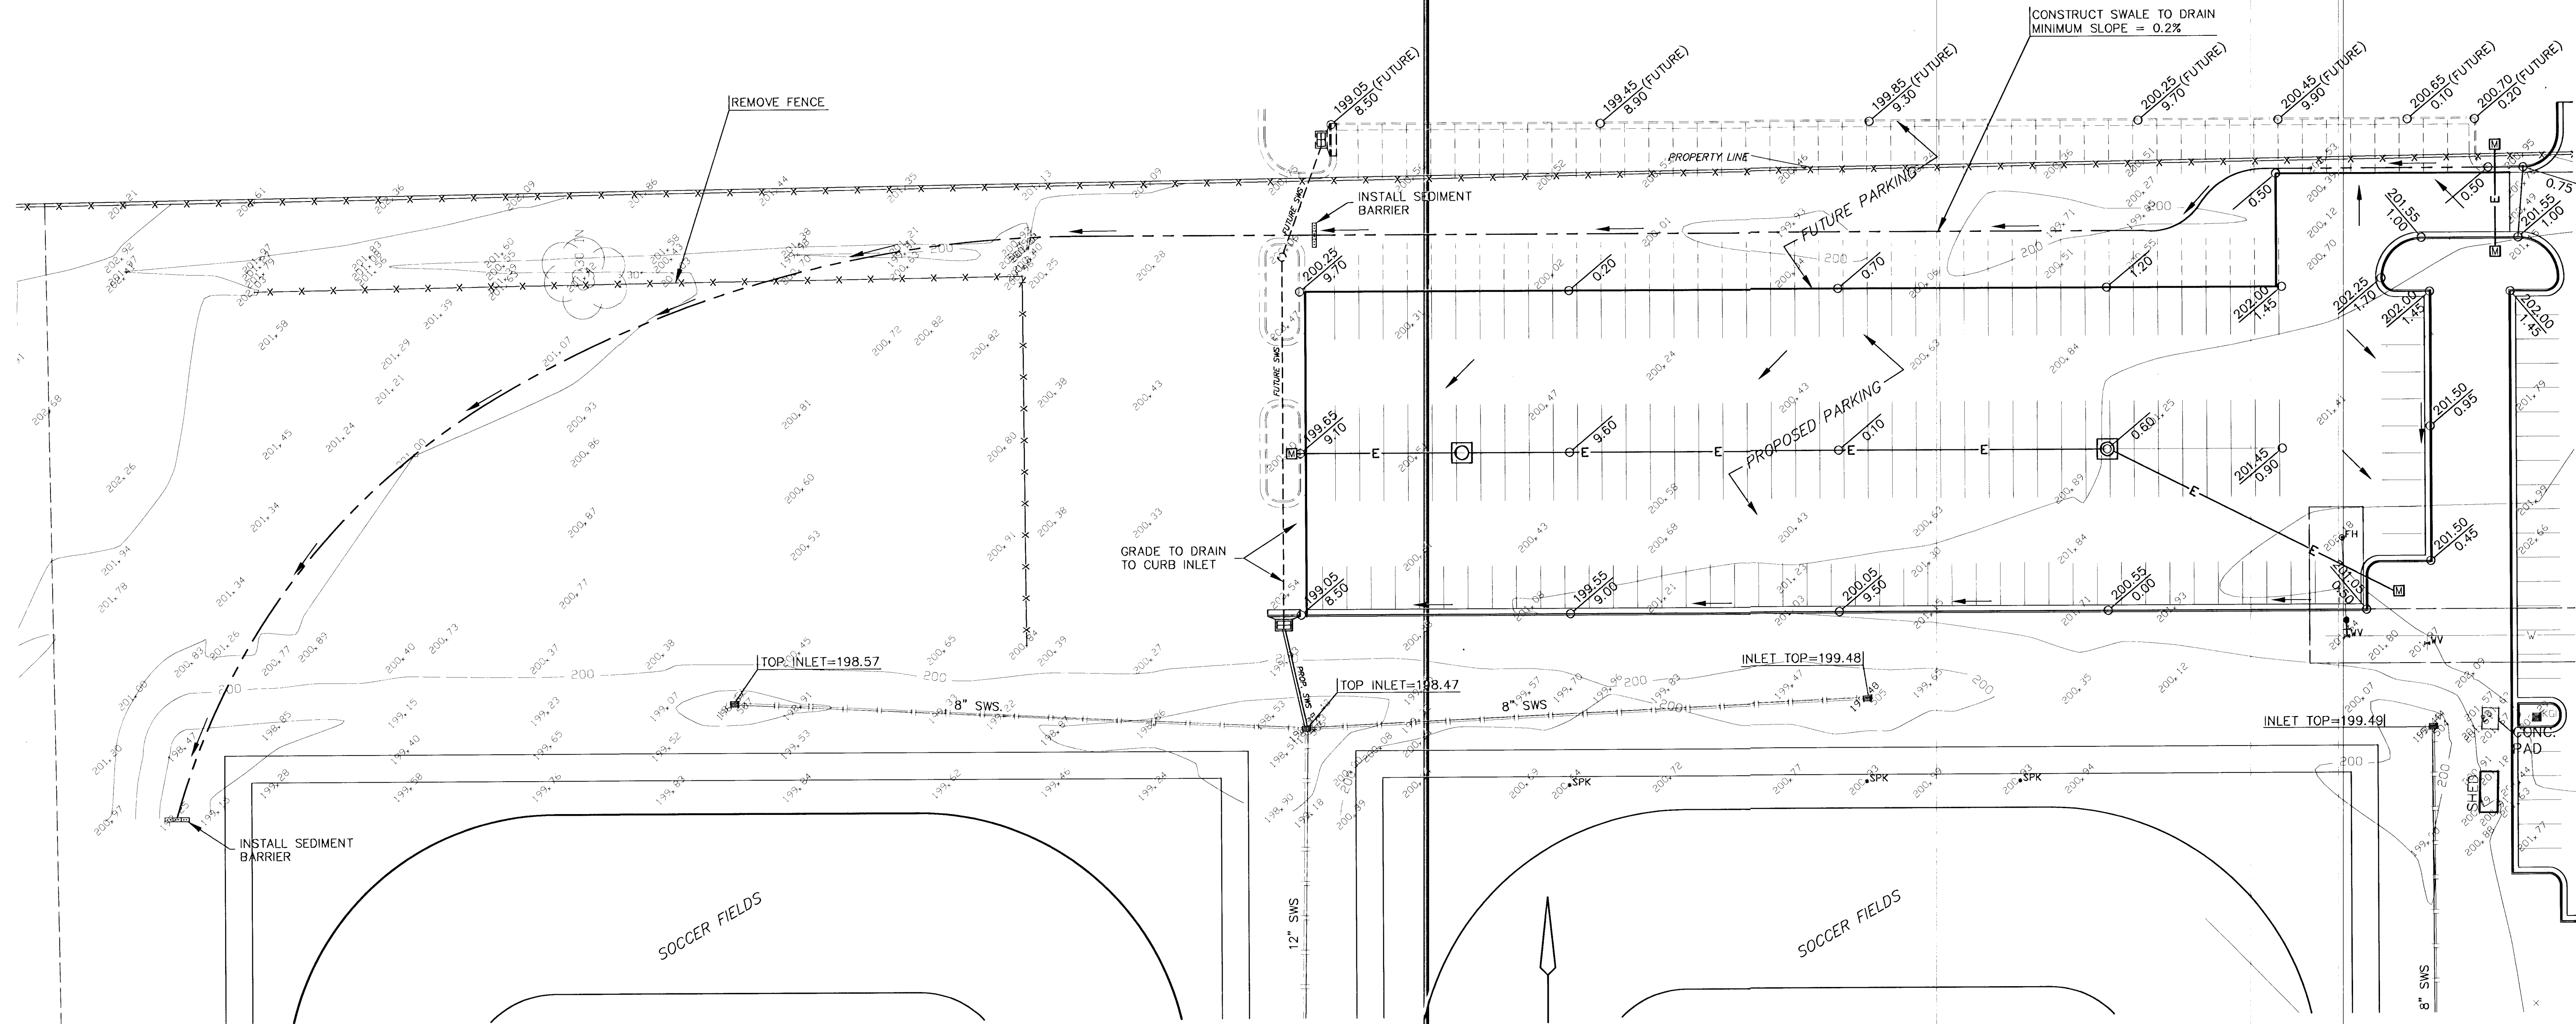

LEGEND

- GN - GAS METER
- *SIN - TREE AND DIAMETER
- △SIN - TREE AND DIAMETER
- △SN - SIGN
- IP - IRON BAR
- - BUSH
- PP-X - POWER POLE AND DEADMAN
- KGE - ELECTRIC BOX
- POLE - POLE
- TRAF. MH - TRAFFIC SIGNAL MANHOLE
- △ - SECTION CORNER
- LP - LIGHT POLE
- FH - FIRE HYDRANT
- WV - WATER VALVE
- WM - WATER METER
- ICV - IRRIGATION CONTROL VALVE
- TR

- EDGE OF TREES
- UNDERGROUND ELECTRIC LINE
- FENCE
- BENCHMARK
- STORM WATER MANHOLE
- SANITARY SEWER MANHOLE
- TELEPHONE RISER
- STORM SEWER PIPE
- WATER LINE
- SANITARY SEWER LINE
- GAS LINE
- TELEPHONE LINE
- INLET
- DIRECTION OF FLOW
- PROP. SPOT ELEVATION
- TOP # INDICATES TOP OF FULL CURB (WHERE APPLICABLE)
- BOTTOM # INDICATES FLOW LINE (WHERE APPLICABLE)

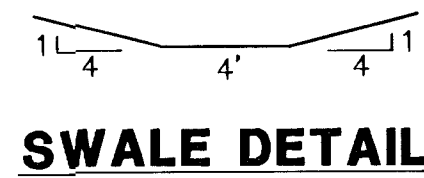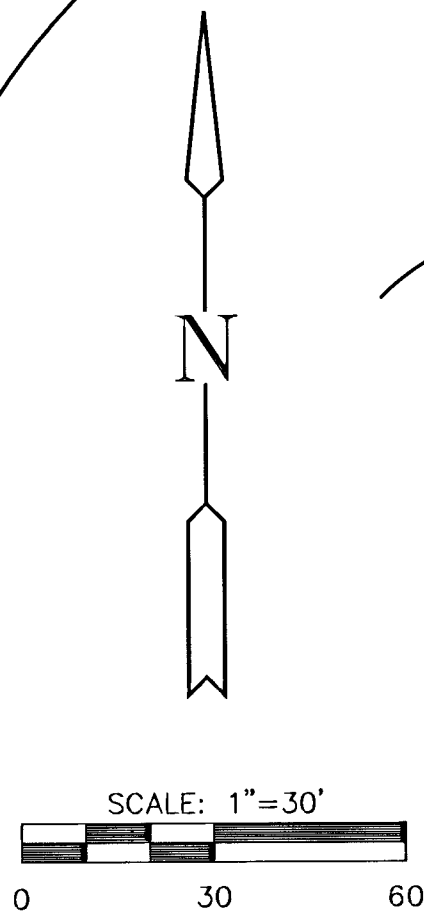

MID-KANSAS ENGINEERING CONSULTANTS, INC.
411 N. WEBB ROAD
WICHITA, KS. 67206
316-684-9600

NORTHEAST BASEBALL/SOCCER COMPLEX
PROJECT NAME

GRADING PLAN
SHEET TITLE

GJA DESIGN BY:	GJR DRAWN BY:	GJA CHECKED BY:
MARCH 2000 DATE	98026 JOB NO.	3 / 7 SHEET/OF