

G:\CIVIL\98026\PAVE\PHASE3\PAVE2.DWG Thu Jun 08 12:21:16 2000

G:\CIVIL\98026\PAVE\PHASE3\PAVE2

LEGEND

≡ ≡ ≡ ≡ (2) 6" PVC PIPE SLEEVES



≡ ≡ ≡ ≡ (2) 4" PVC PIPE SLEEVES

5" ASPHALT P.V.M.T.
(TRUCK ROUTE)

◻ CONDUIT MARKER SEE DETAIL B ON SHEET 7

○ 24"Ø 12'-6" PIER SEE DETAIL A ON SHEET 7

-E-E- SCHEDULE 40 PVC CONDUIT
SEE DETAIL C ON SHEET 7

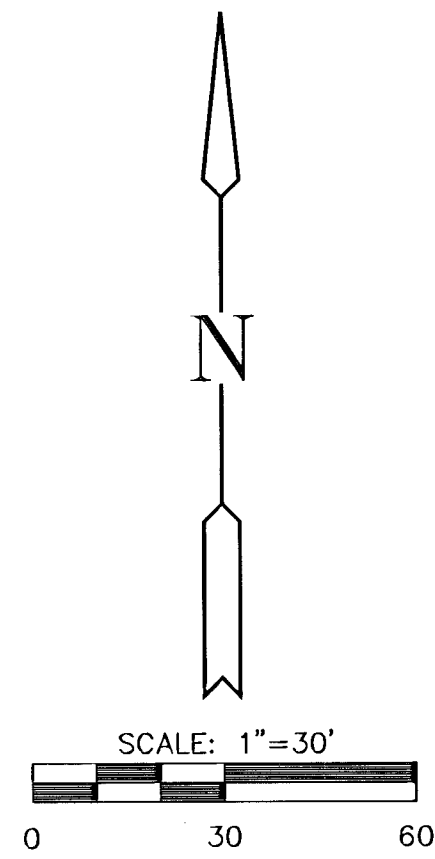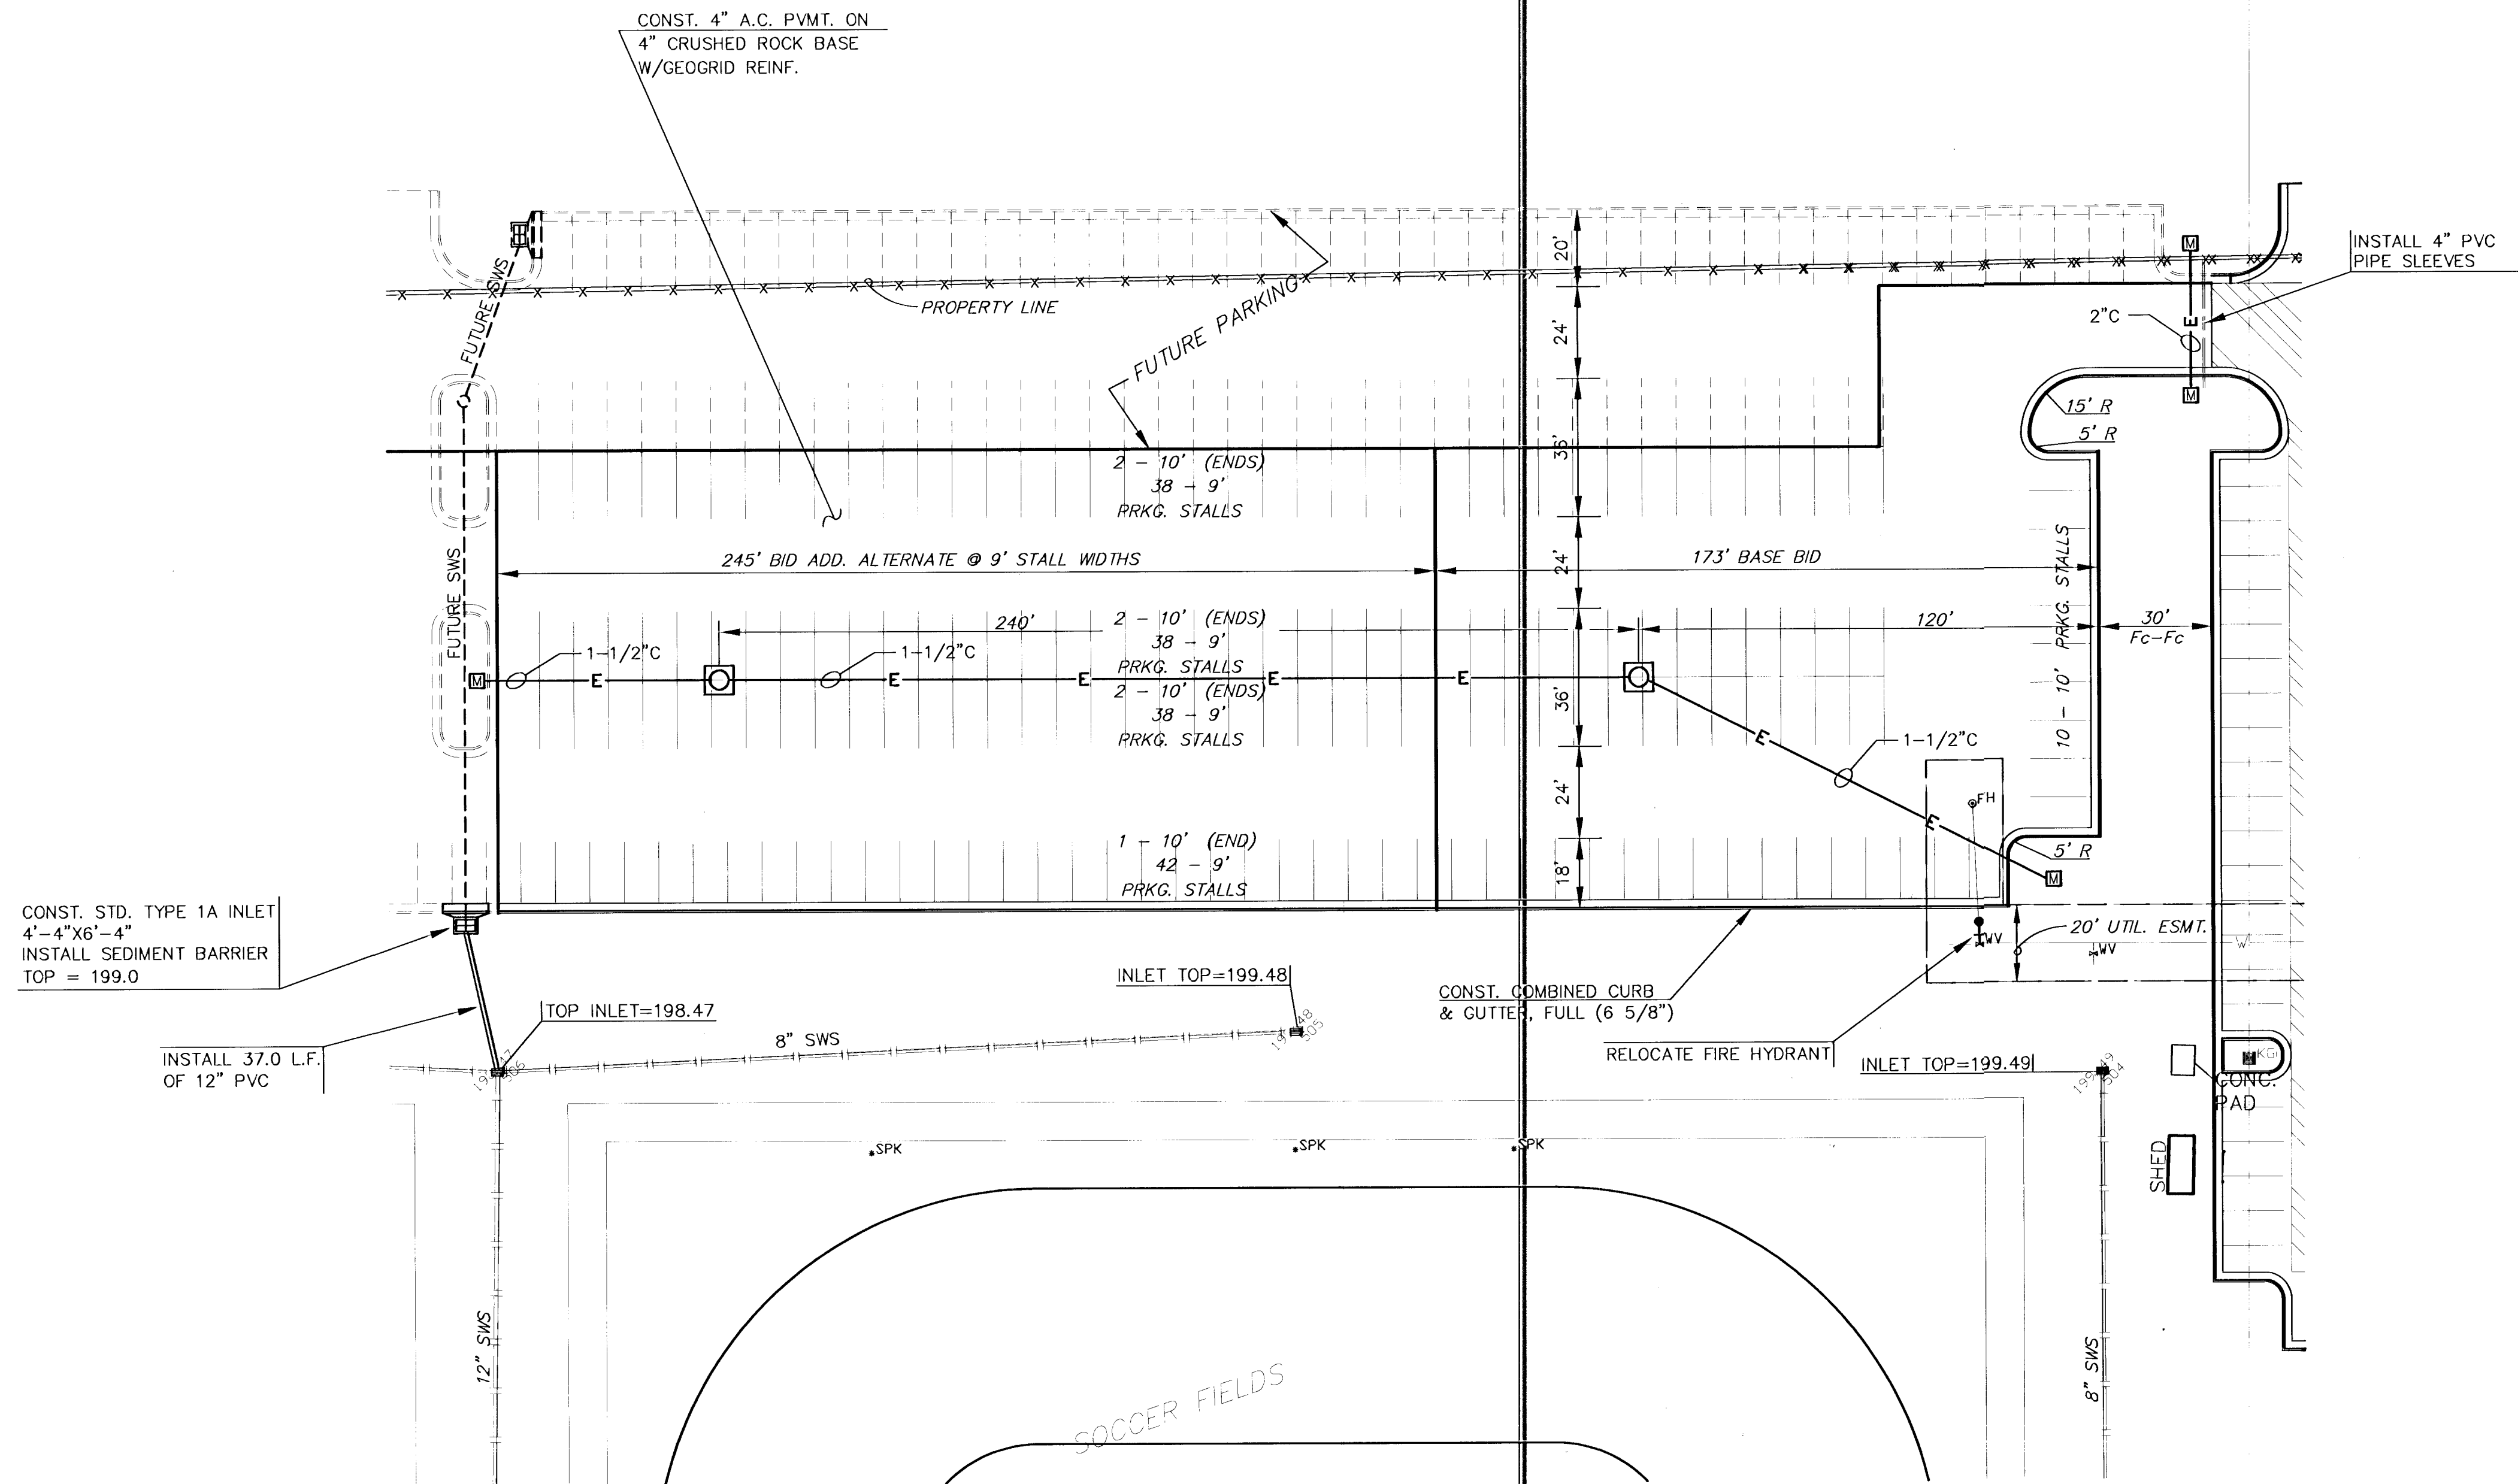

NOTE: DIMENSIONS ARE FROM FACE TO FACE
OF CURB UNLESS INDICATED OTHERWISE.

NORTHEAST BASEBALL/SOCCER COMPLEX
PROJECT NAME

PAVING PLAN
SHEET TITLE

**MID-KANSAS ENGINEERING
CONSULTANTS, INC.**
411 N. WEBB ROAD
WICHITA, KS. 67206
316-684-9600

GJA
DESIGN BY:

GJR
DRAWN BY:

GJA
CHECKED BY:

MARCH 2000
DATE

98026
JOB NO.

4 / 7
SHEET/OF