


THE WICHITA AIRPORT AUTHORITY  
WICHITA, KANSAS

# COLONEL JAMES JABARA AIRPORT

PLANS FOR

## SOUTHWEST AREA SITE DEVELOPMENT UTILITY IMPROVEMENTS

CITY OF WICHITA PROJECT NO. 461050

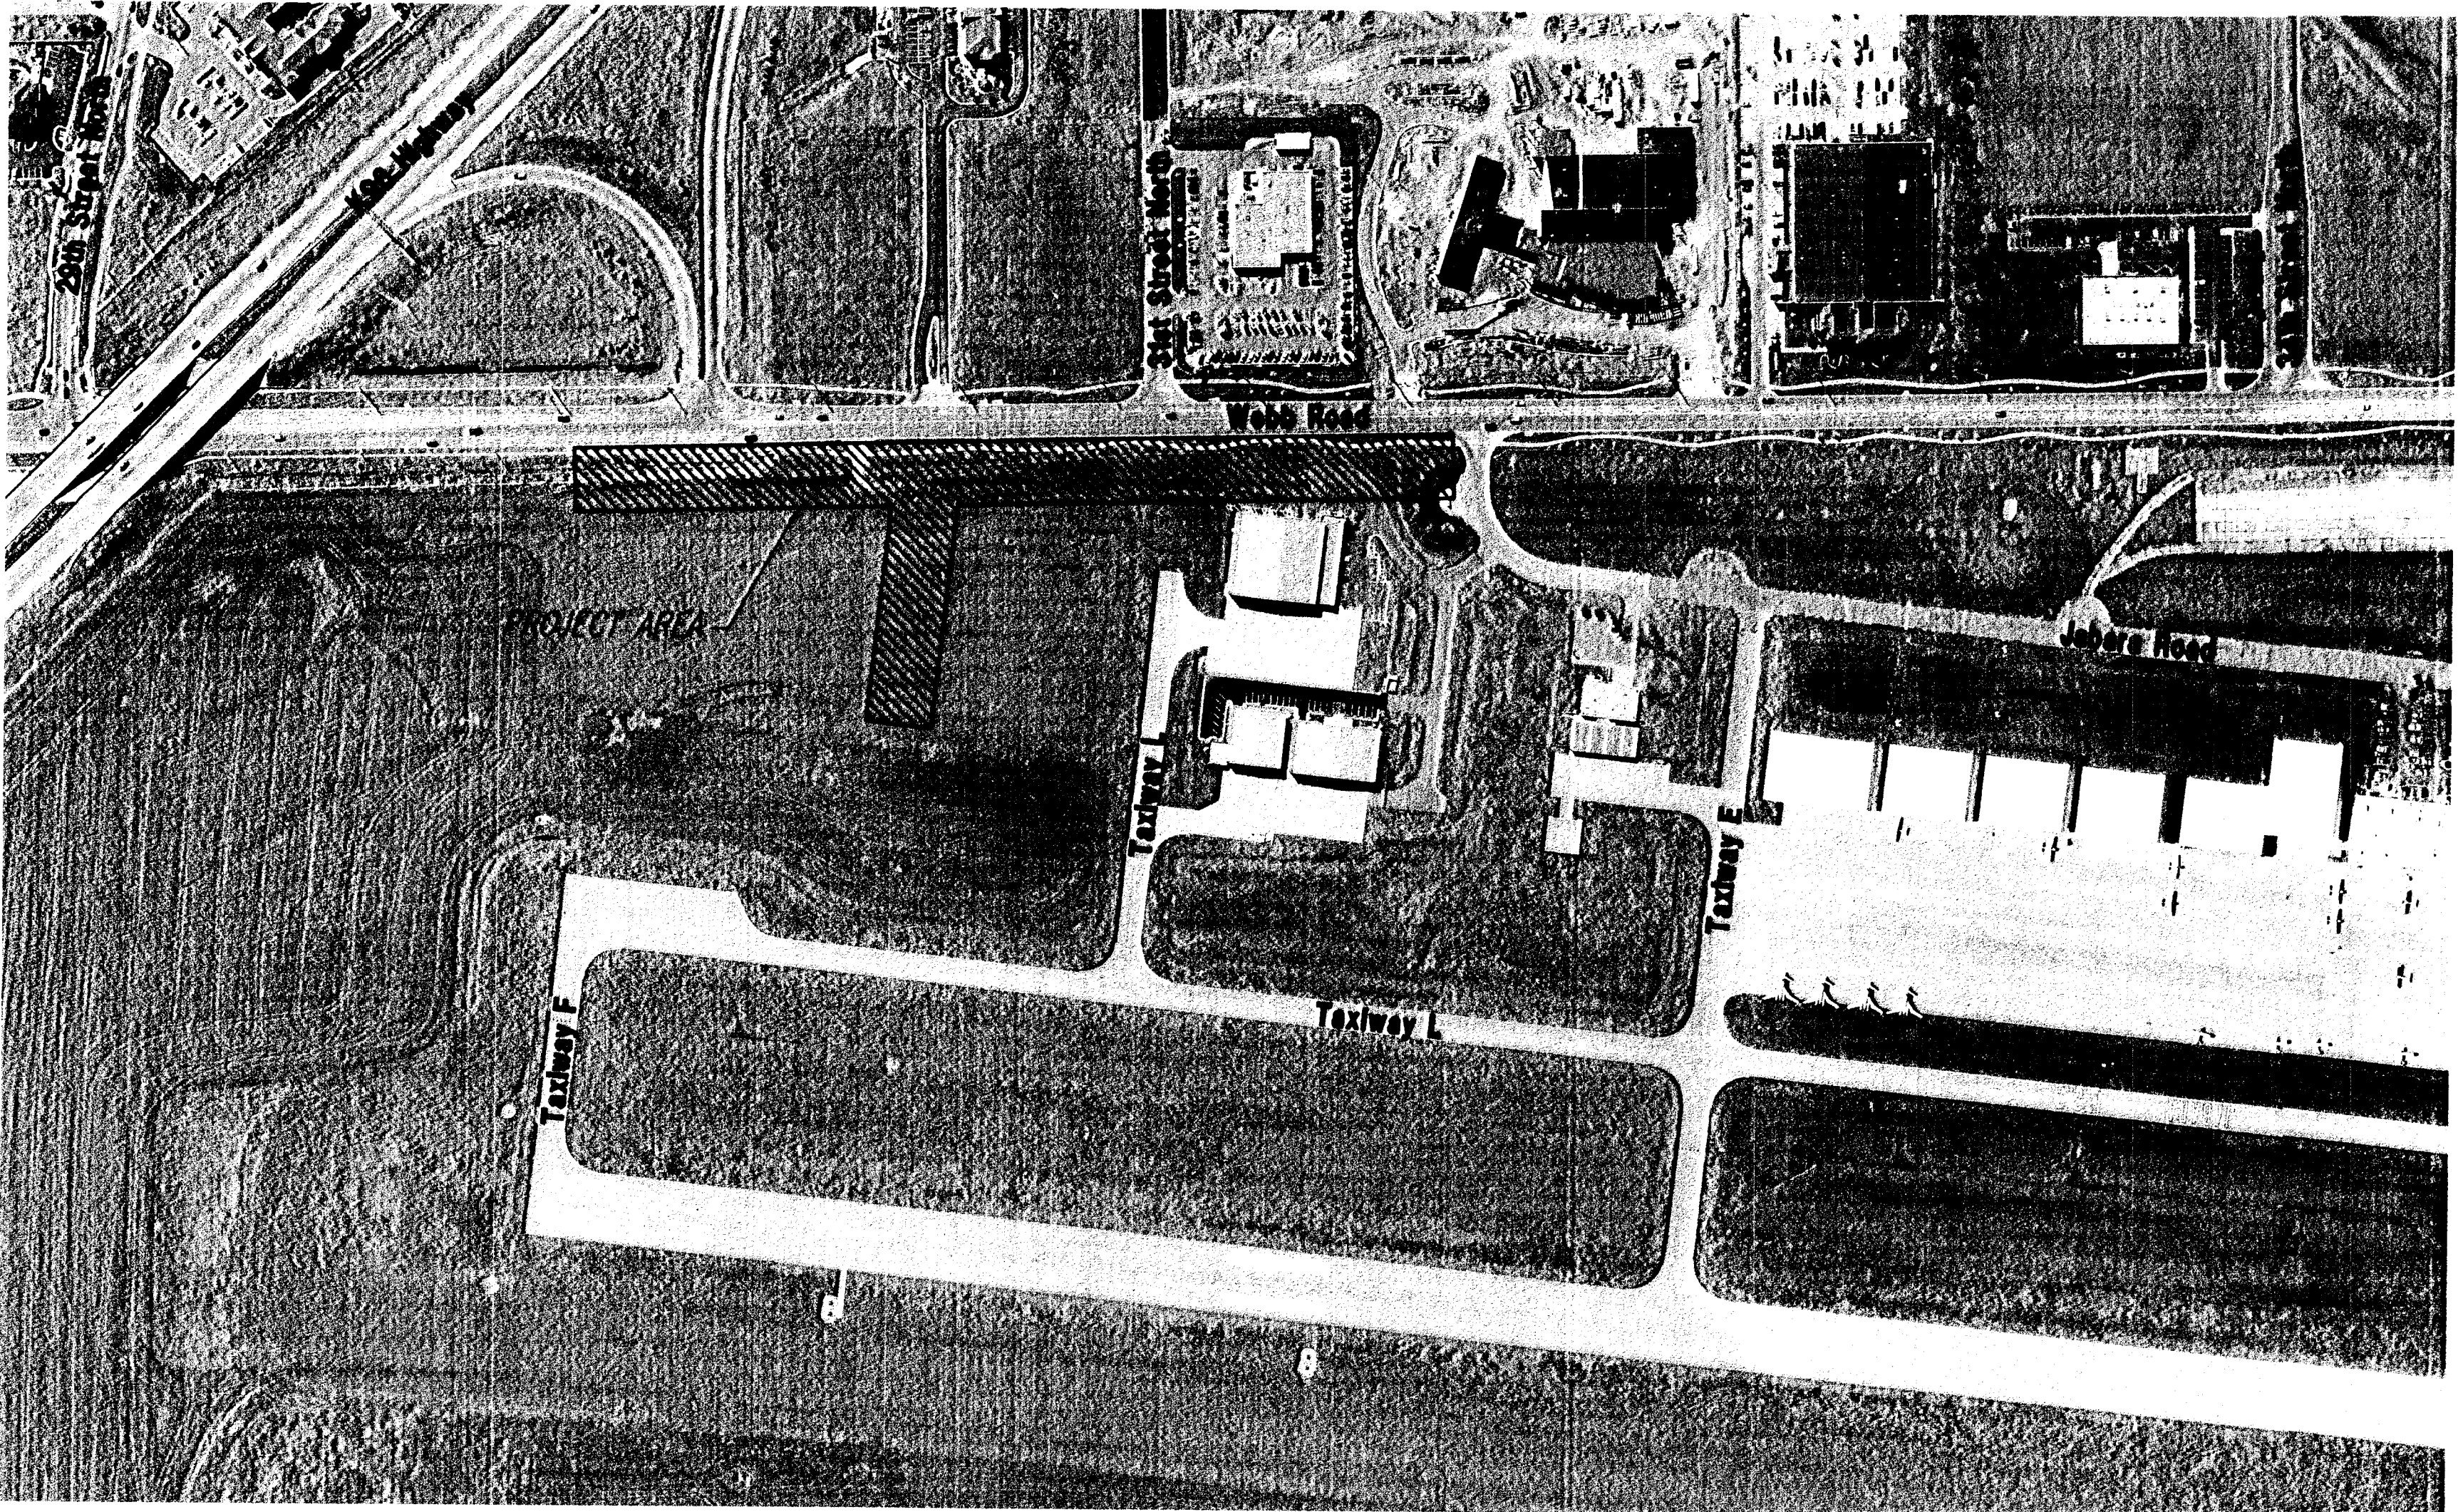

SCALE: 1"=200'

INDEX OF SHEETS


| Sheet No. C1.0      | Title Sheet                                             |
|---------------------|---------------------------------------------------------|
| Sheet No. CS1.0     | Sanitary Sewer Title Sheet                              |
| Sheet No. CS1.1     | Sanitary Sewer Key Map and General Notes                |
| Sheet No. CS1.2     | 4" Force Main Plan/Profile                              |
| Sheet No. CS1.3-1.4 | Sanitary Sewer Plan/Profile                             |
| Sheet No. CS1.5     | Lift Station and Mechanical Details                     |
| Sheet No. CS1.6     | Standard Type "P" Manhole Details                       |
| Sheet No. CS1.7     | Manhole Frame & Cover Details                           |
| Sheet No. CS1.8     | Vertical Riser Details                                  |
| Sheet No. E1.1      | Electrical Symbols, General Notes, Schedules, & Details |
| Sheet No. E1.2      | Electrical Details                                      |
| Sheet No. E1.3      | Electrical Site Plan                                    |
| Sheet No. S1.1      | Concrete Wall Details                                   |
| Sheet No. CF1.0     | Fencing Plan                                            |
| Sheet No. CF1.1     | Fence Details                                           |
| Sheet No. CS0-5.3   | Soil Erosion BMP Details                                |
| Sheet No. CW1.0     | Waterline Title Sheet                                   |
| Sheet No. CW1.1     | Waterline Key Map and General Notes                     |
| Sheet No. CW1.2     | Standard Water Assembly Details                         |
| Sheet No. CW1.3-1.5 | Waterline Plan/Profile                                  |
| Sheet No. CS0-5.3   | Soil Erosion BMP Details                                |
| Sheet No. CG1.0     | Site Grading Plan                                       |
| Sheet No. CU1.0     | Site Utility Plan 2" Gas Line                           |
| Sheet No. CU1.1     | Site Utility Plan Communication Line                    |

AIRPORT REFERENCE CODE (ARC) D - IX

|                                            |
|--------------------------------------------|
| APPROVED                                   |
| THE WICHITA AIRPORT AUTHORITY              |
| DIRECTOR OF AIRPORTS                       |
| AIRPORT ENGINEERING AND PLANNING MANAGER   |
| PLANS PREPARED BY                          |
| Professional Engineering Consultants, P.A. |
| 303 S. TOPEKA • WICHITA, KANSAS 67202      |
| 316-262-2691 • FAX 316-262-3003            |

JULY 2006

RECORD DRAWING

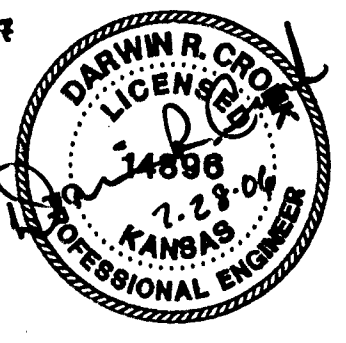

Printed 07-28-2006 9:16:06 AM by RT  
Plot Scale 1:200 07-28-2006 10:16:30 AM by RT  
C:\Users\jld\Documents\461050-00-C-CombinedSheet

Sanitary Sewer:  
Dondlinger & Sons Construction Co., Inc.- Contractor  
Rogers- PEC -Inspector  
Released 5/29/07  
Riser & Stubs  
.pdf by JDL 6/19/07