


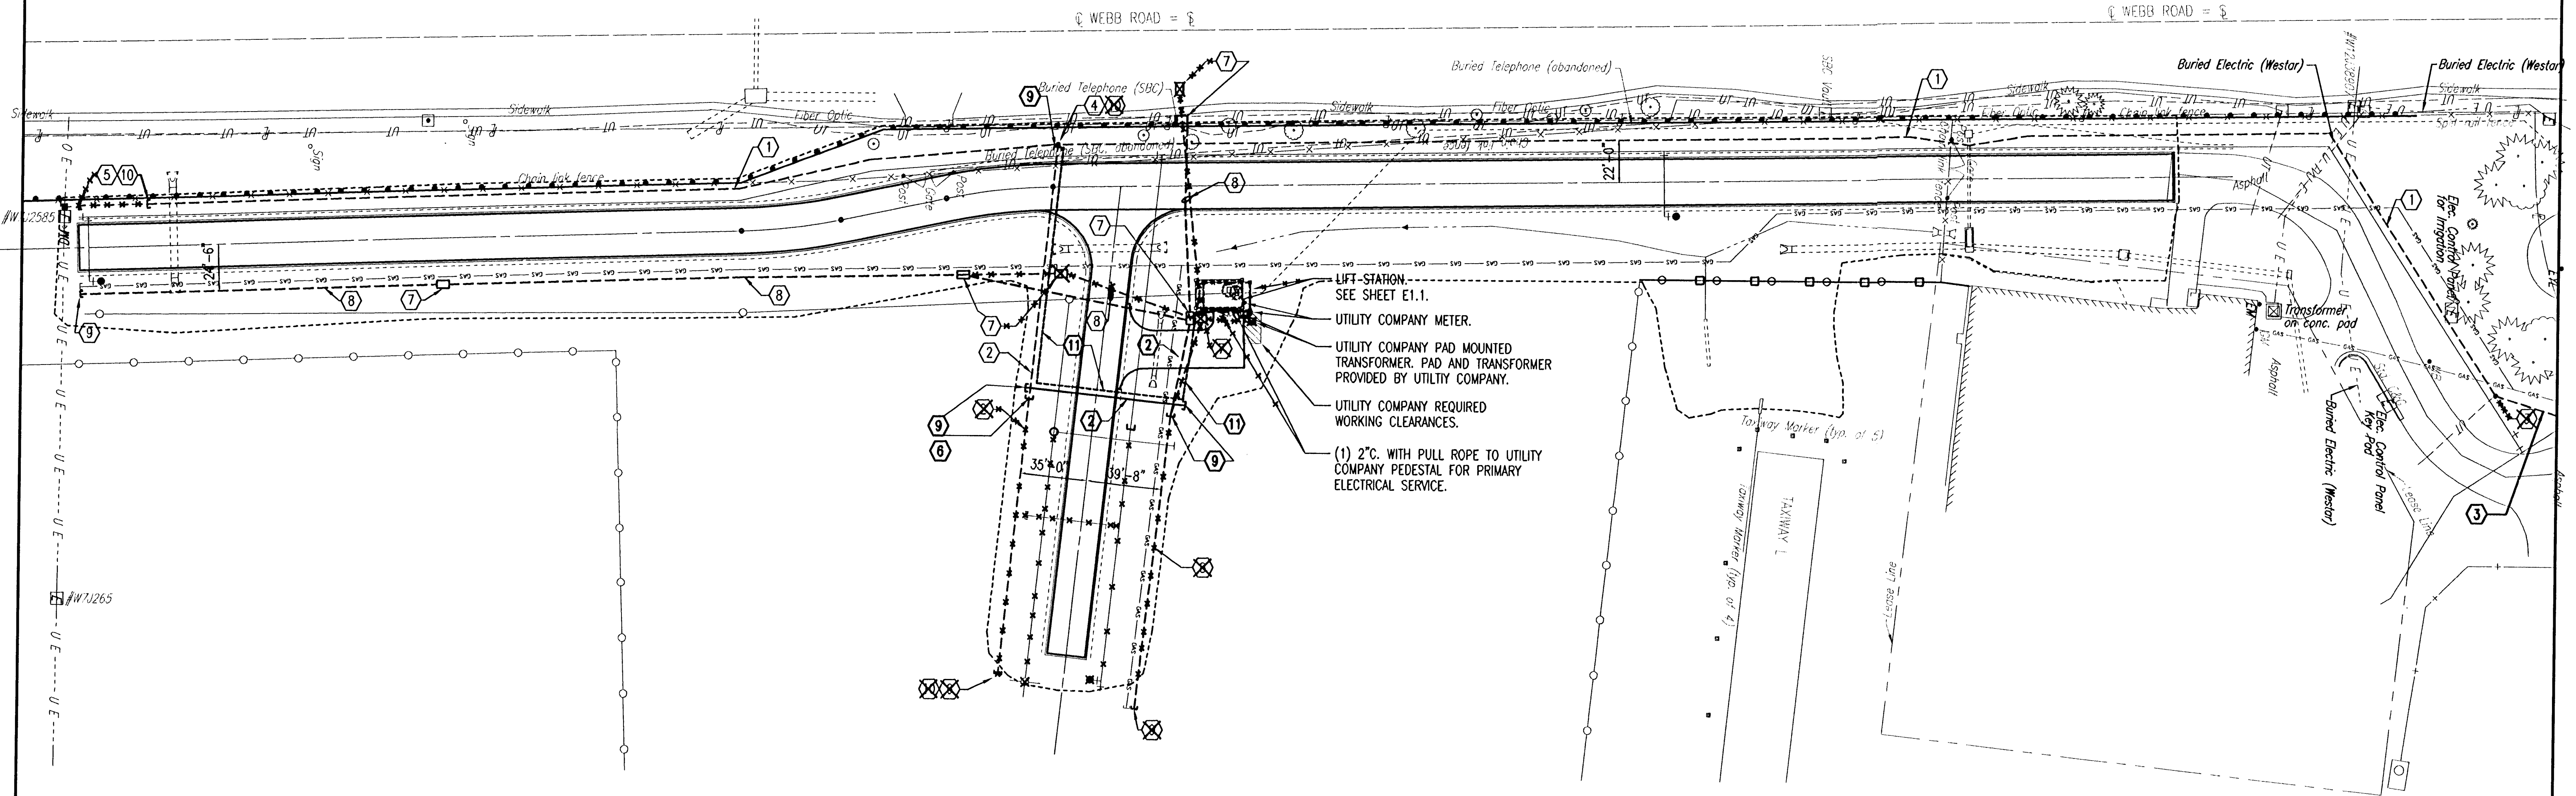

A ELECTRICAL SITE PLAN
SCALE: 1" = 40'-0"

PLAN NOTES:

1. FIELD VERIFY EXISTING CONDITIONS AND DIMENSIONS PRIOR TO TRENCHING.
2. COORDINATE ALL WORK WITH OTHER TRADES.
3. COORDINATE ALL CONNECTIONS AND REQUIREMENTS WITH WICHITA AIRPORT AUTHORITY.
4. TELEPHONE CABLES SHALL BE CATEGORY 3, GEL FILLED, DIRECT BURIED, 22 AWG, GOPHER PROOF OUTSIDE PLANT RATED.
5. PROVIDE UTILITY MARKER AT ALL DIRECT BURIED SPlice ENCLOSURE LOCATIONS AND AT ENDS OF CAPPED CONDUITS. SEE DETAIL 4/E1.2.
6. COORDINATE ELECTRICAL SERVICE REQUIREMENTS WITH WESTAR. CONTACT SHANE PRICE AT (316) 261-6315.
7. INSTALL UTILITIES PARALLEL TO EACH OTHER AND THE FUTURE ROAD CENTERLINE.

ADD. #3 (CORRECTED ADD. #3 FROM NOTE 3 TO NOTE 4)
TELEPHONE CABLES SHALL BE CATEGORY 3, GEL FILLED, DIRECT BURIED, 22 AWG, GOPHER PROOF OUTSIDE PLANT RATED.

KEYED PLAN NOTES:

1. 400 PAIR, CATEGORY 3, DIRECT BURIED TELEPHONE CABLE. **DELIVER CABLE TO OWNER. 4" C WITH PULL ROPE AND CAPS.**
2. 100 PAIR, CATEGORY 3, DIRECT BURIED TELEPHONE CABLE.
3. PROVIDE 400 PAIR, DIRECT BURIED SPlice ENCLOSURE. SPlice 400 PAIR TELEPHONE CABLE TO EXISTING 400 PAIR TELEPHONE CABLE.
4. PROVIDE 400 PAIR, DIRECT BURIED SPlice ENCLOSURE. **DO NOT INSTALL. DELIVER TO OWNER.**
5. PROVIDE 400 PAIR, DIRECT BURIED SPlice ENCLOSURE.
6. PROVIDE 100 PAIR, DIRECT BURIED SPlice ENCLOSURE. **DO NOT INSTALL. DELIVER TO OWNER.**
7. UTILITY COMPANY 3 PHASE PRIMARY PEDESTAL. FIELD VERIFY EXACT LOCATION.
8. 4" C. WITH PULL ROPE FOR UTILITY COMPANY PRIMARY ELECTRICAL SERVICE PER UTILITY COMPANY REQUIREMENTS. PROVIDE 36" RADIUS PVC COATED RGS SWEEPS.
9. CAP CONDUIT AND PROVIDE UTILITY MARKER TO MARK END OF CONDUIT. **ONE MARKER WHERE CONDUITS MEET.**
10. PROVIDE UTILITY MARKER TO MARK DIRECT BURIED SPlice ENCLOSURE LOCATION. PLACE DIRECTLY ABOVE SPlice ENCLOSURE.
11. 2" C WITH PULL ROPE.

NOTE:
SEE SHEET CU1.1 FOR DIRECT BURIED TELEPHONE CABLE COORDINATE LAYOUT.

RECORD DRAWING
26 JAN 07

ADDENDUM #3

THE WICHITA AIRPORT AUTHORITY
COLONEL JAMES JABARA AIRPORT

ELECTRICAL SITE PLAN

SANITARY SEWER AND WATER DISTRIBUTION SYSTEM
SOUTHWEST AREA SITE DEVELOPMENT IMPROVEMENTS

Professional Engineering Consultants, P.A.
303 S. TOPEKA • WICHITA, KANSAS 67202
316-262-2691 • FAX 316-262-3003

Date: SEPTEMBER 2005 Job No. 05471-019