



11/23/2021 9:16:28 AM  
 B:\1100\1088R21003\_StrykerRemoval\1088R21003\_A\_StrykerAddition\_V01.rvt



©2021 MKEC Engineering All Rights Reserved. www.mkec.com  
 These drawings and their contents, including, but not limited to, all concepts, designs, & data are the exclusive property of MKEC Engineering (MKEC), and may not be used or reproduced in any way without the express consent of MKEC.

**CODE SITE PLAN**

PROJECT NO.	01088R21003	
DATE	11/23/2021	
SCALE	AS NOTED	
DESIGNED	DRAWN	CHECKED
MH	SS	MH
ISSUED FOR CONSTRUCTION	11-24-21	
NO.	REVISION	DATE
SHEET NO.		
G0.3		

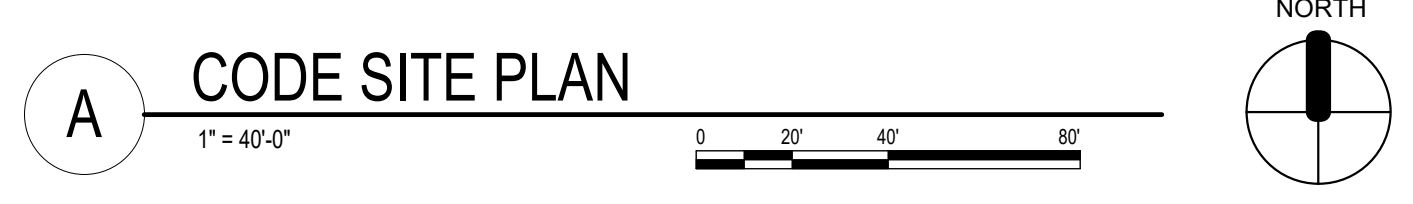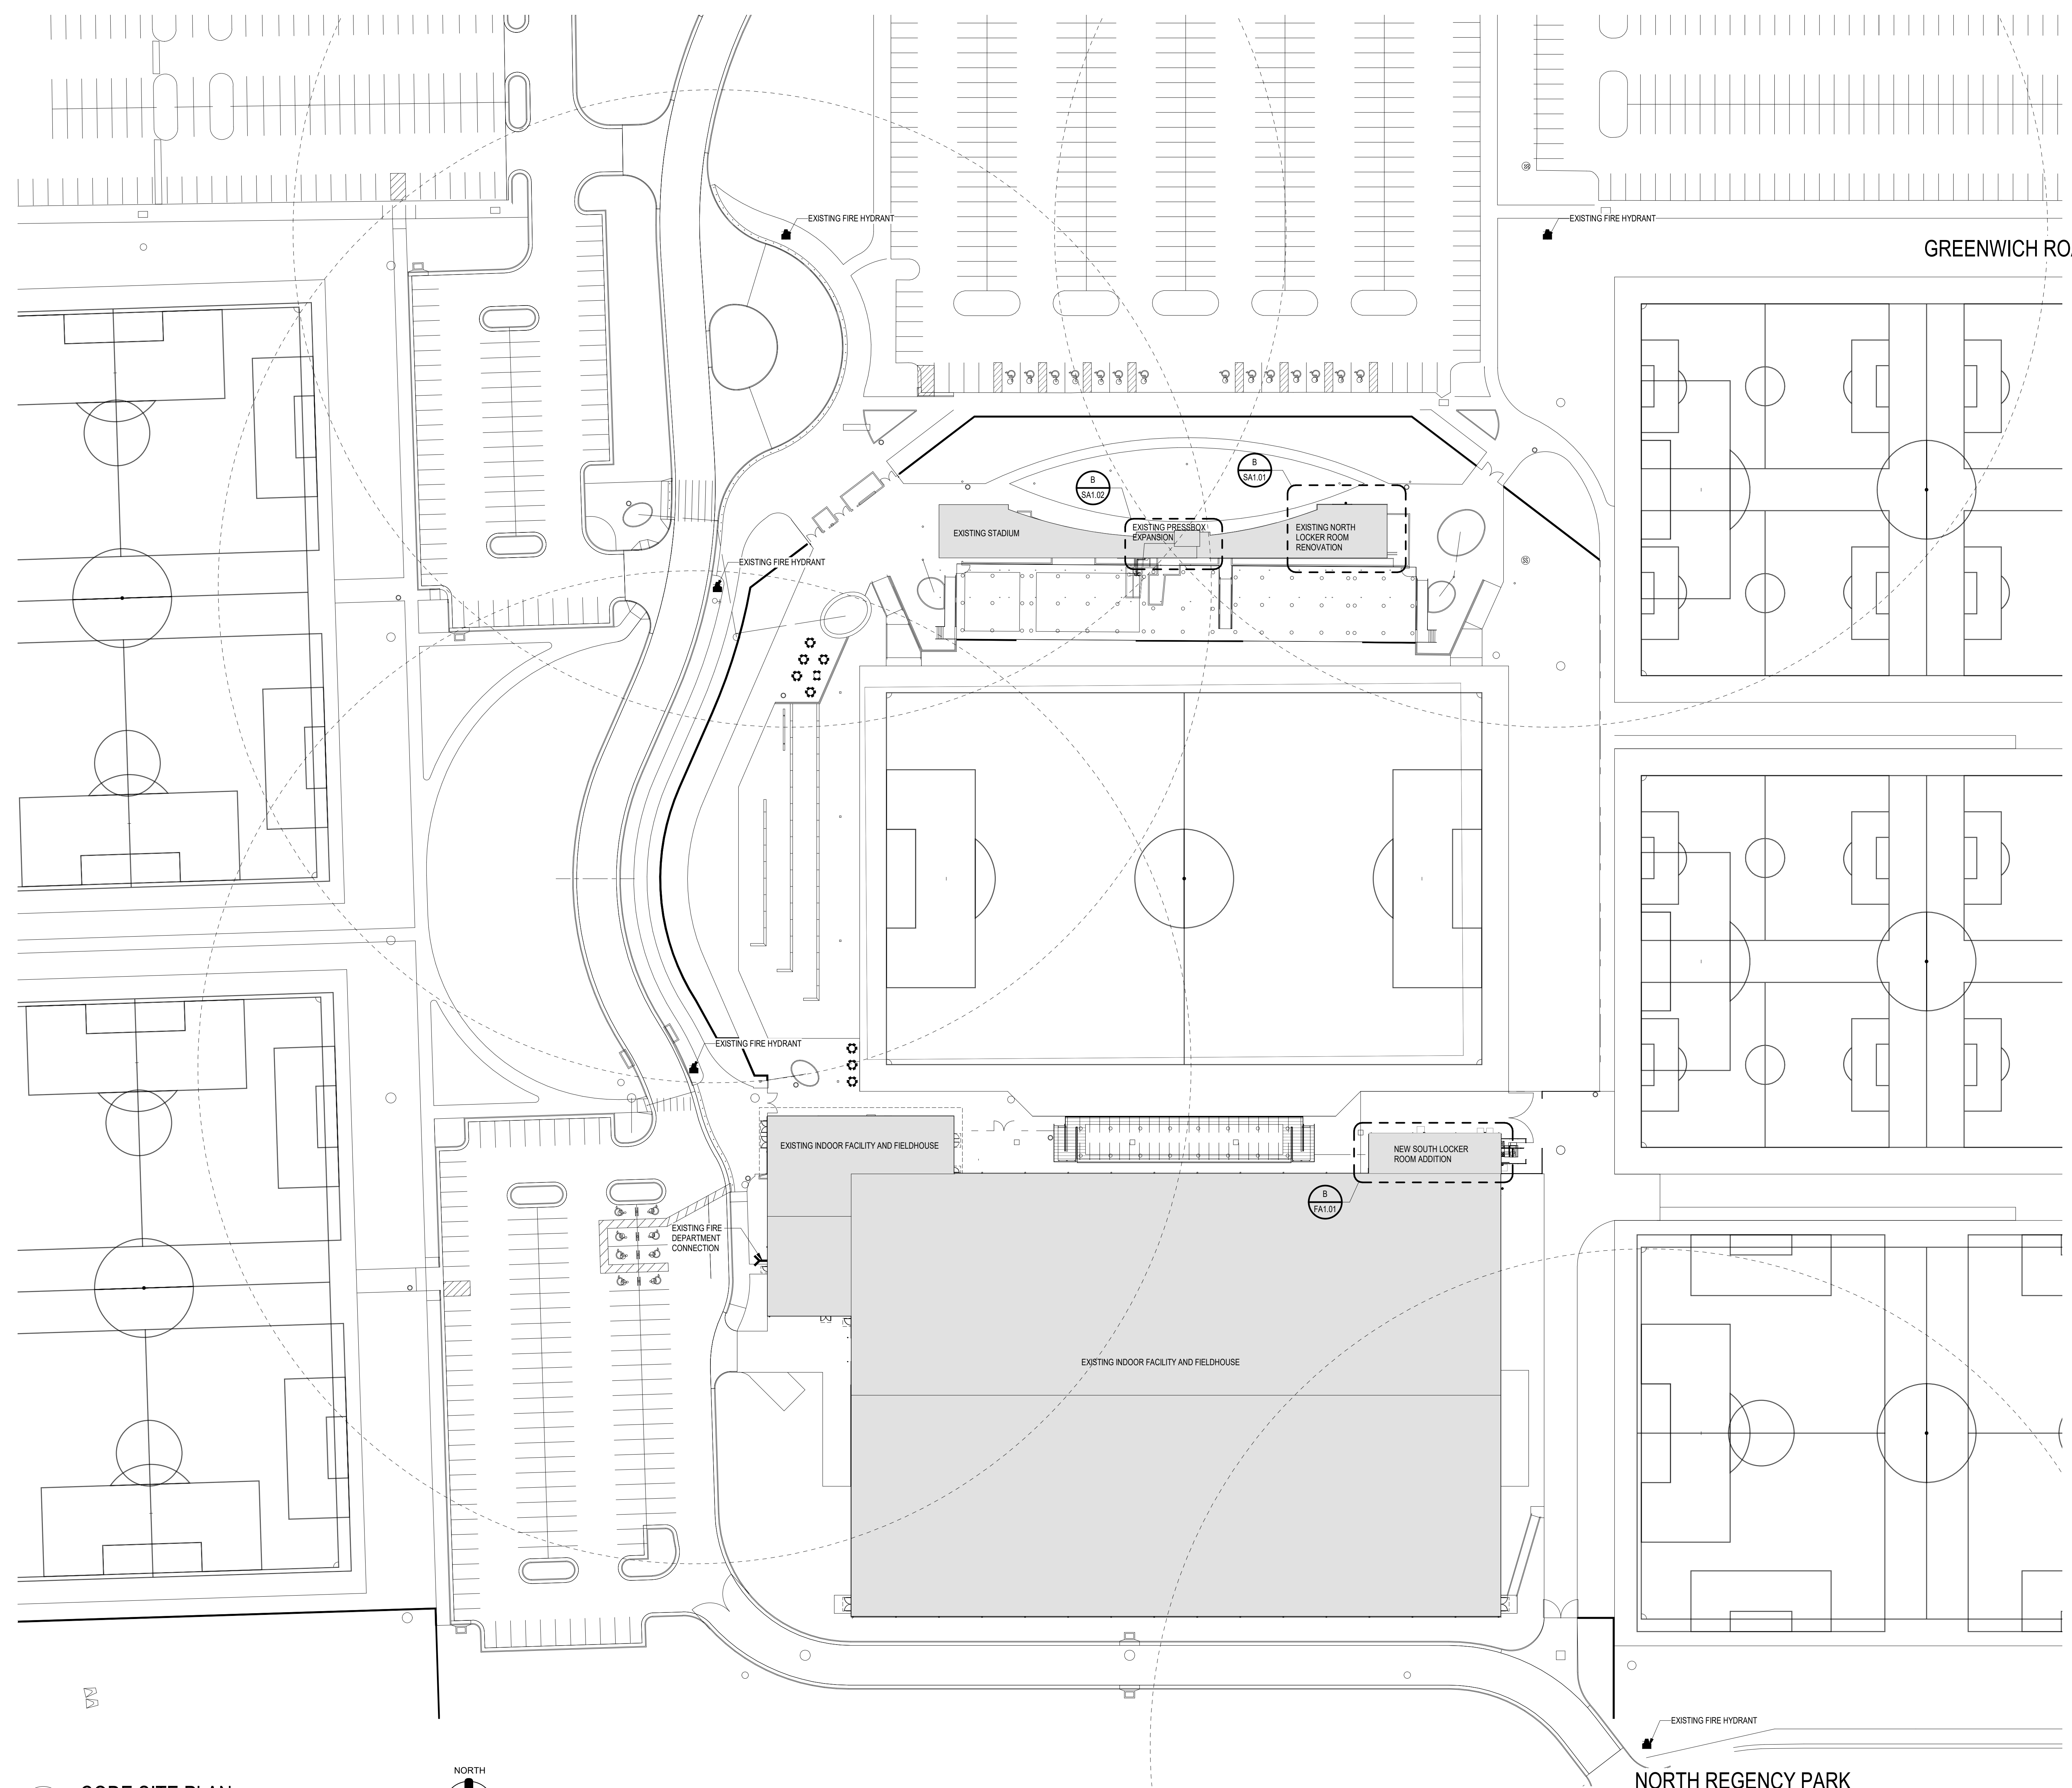

**CODE SITE PLAN GRAPHIC LEGEND**

	FIRE ALARM CONTROL PANEL (REF. PLANS)
	FIRE ALARM ANUNCIATOR PANEL (REF. PLANS)
	FIRE DEPARTMENT CONNECTION (FDC)
	PUBLIC FIRE HYDRANT (ALL EXISTING ON COMPLEX)

