


11/23/2021 8:17:00 AM

B:\11-23-21\0108821003_StrykerRemodel\0108821003_A_Stryker_Architect_V01.rvt



Wichita, KS • 316.684.9600

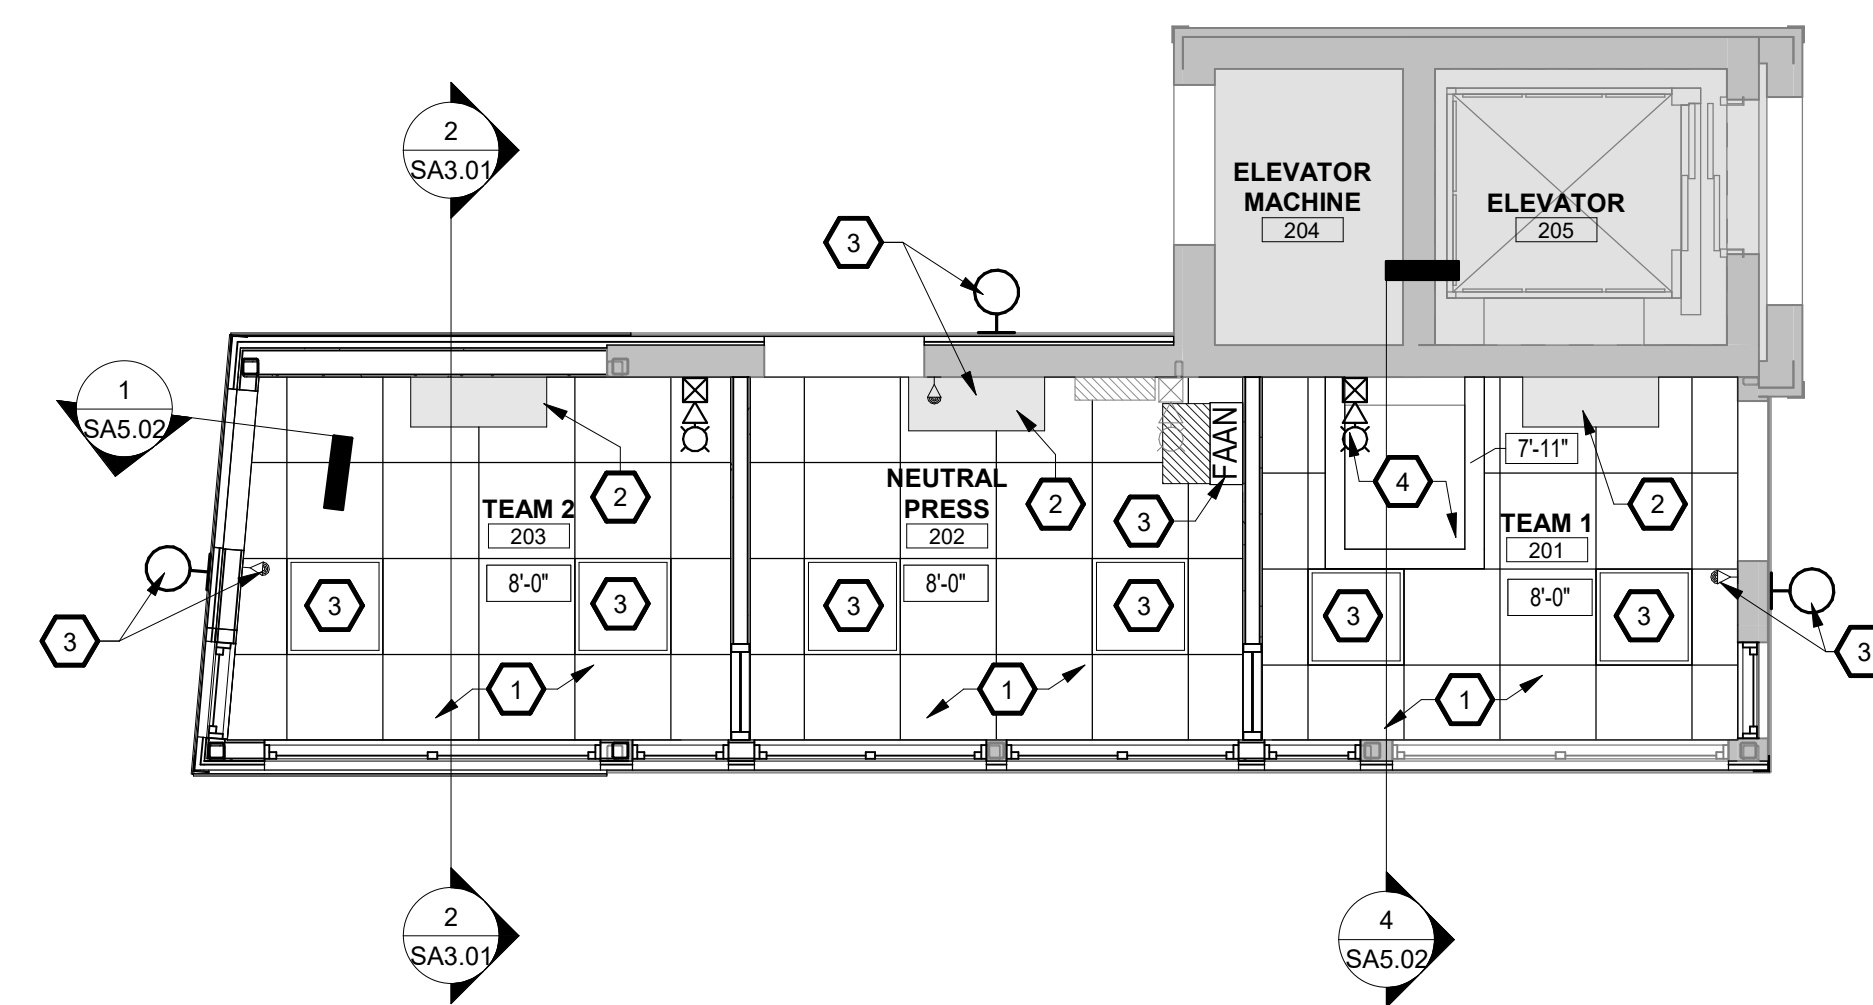

PRESSBOX RCP KEYNOTES	
KEYNOTE NUMBER	DESCRIPTION
1	NEW SUSPENDED 2X2 CEILING GRID - REF SPEC
2	NEW MECHANICAL UNIT - REF MECH
3	NEW ELECTRICAL LIGHT FIXTURE OR DEVICE - REF ELEC
4	NEW GYP AND STUD BULKHEAD AROUND EXISTING ROOF HATCH

A PRESSBOX - REFLECTED CEILING PLAN
 1/4" = 1'-0"
 0 2 4 6 8
 NORTH

PHASE 8 INDOOR FACILITY & STADIUM IMPROVEMENTS
STRYKER SPORTS
 WICHITA, KANSAS



©2021
 MKEC Engineering
 All Rights Reserved.
 www.mkec.com
 These drawings and their contents, including, but not limited to, all concepts, designs, & ideas are the exclusive property of MKEC Engineering (MKEC), and may not be used or reproduced in any way without the express consent of MKEC.

PRESSBOX RCP

PROJECT NO.	0108821003	
DATE	11/23/2021	
SCALE	AS NOTED	
DESIGNED	DRAWN	CHECKED
MH	SS	MH

ISSUED FOR CONSTRUCTION	11-24-21	
NO.	REVISION	DATE

SHEET NO. SA1.05

