


11/24/2021 9:17:06 AM

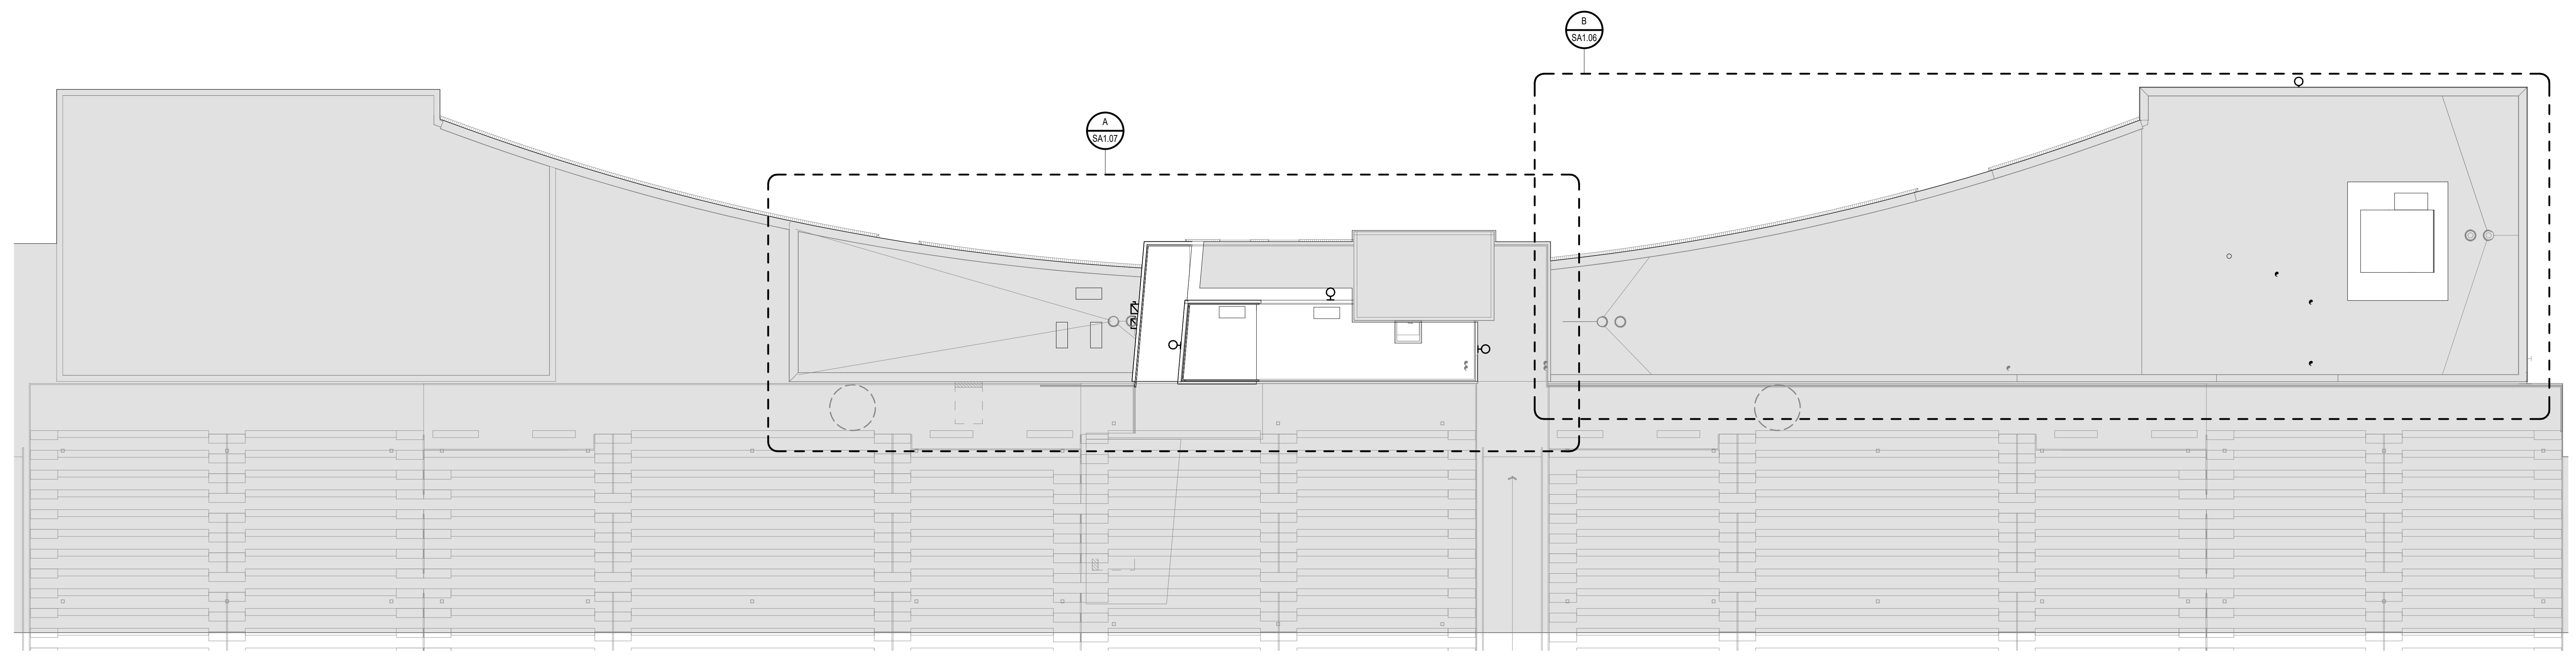

A PRESSBOX ROOF - PROPOSED
1/8" = 1'-0"
0 4 8 16
NORTH

NORTH LOCKER ROOF PLAN KEYNOTES	
KEYNOTE NUMBER	DESCRIPTION
1	NEW RTU & CURB - REF MECH
2	APPROXIMATE EXTENT OF NEW TPO & FLASHING ON EXISTING ROOF
3	EXISTING ROOF CONSTRUCTION TO REMAIN
4	NEW PIPE PENETRATION - REF PLUMBING



B NORTH LOCKER - ROOF PLAN
1/4" = 1'-0"
0 2 4 8
NORTH



©2021 MKEC Engineering All Rights Reserved. www.mkec.com These drawings and their contents, including, but not limited to, all concepts, designs, & data are the exclusive property of MKEC Engineering (MKEC), and may not be used or reproduced in any way without the express consent of MKEC.

STADIUM & ENLARGED N. LOCKER ROOF PLANS

PROJECT NO.	01088R21003	
DATE	11/23/2021	
SCALE	AS NOTED	
DESIGNED	DRAWN	CHECKED
MH	SS	MH
0	ISSUED FOR CONSTRUCTION	11-24-21
NO.	REVISION	DATE
SHEET NO.		
SA1.06		



B:\11-23-21\01088R21003_Stryker\01088R21003_A_Stryker_Architect_V01.rvt