


MECHANICAL DETAILS


PROJECT NO.	1701010567	
DATE	11-24-2021	
SCALE	AS NOTED	
DESIGNED	DRAWN	CHECKED
RLB	JAC	RLB

0	ISSUED FOR CONSTRUCTION	11-24-21
NO.	REVISION	DATE


SHEET NO.
SM3.1

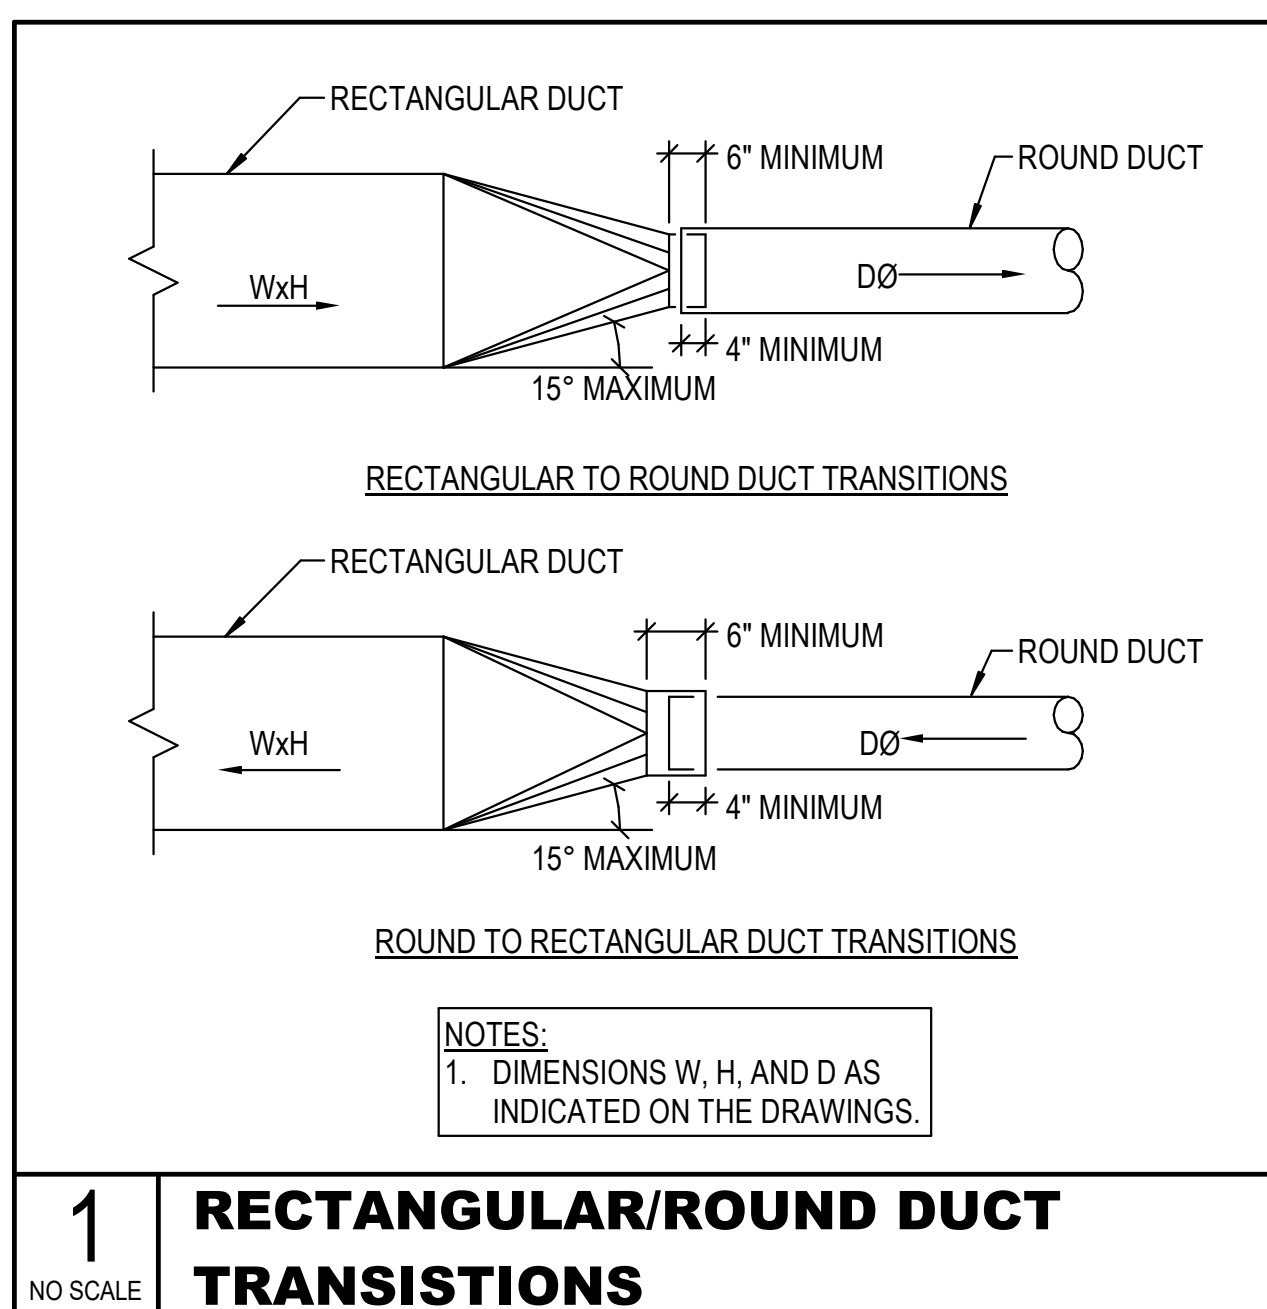


1 RECTANGULAR/ROUND DUCT TRANSITIONS
NO SCALE

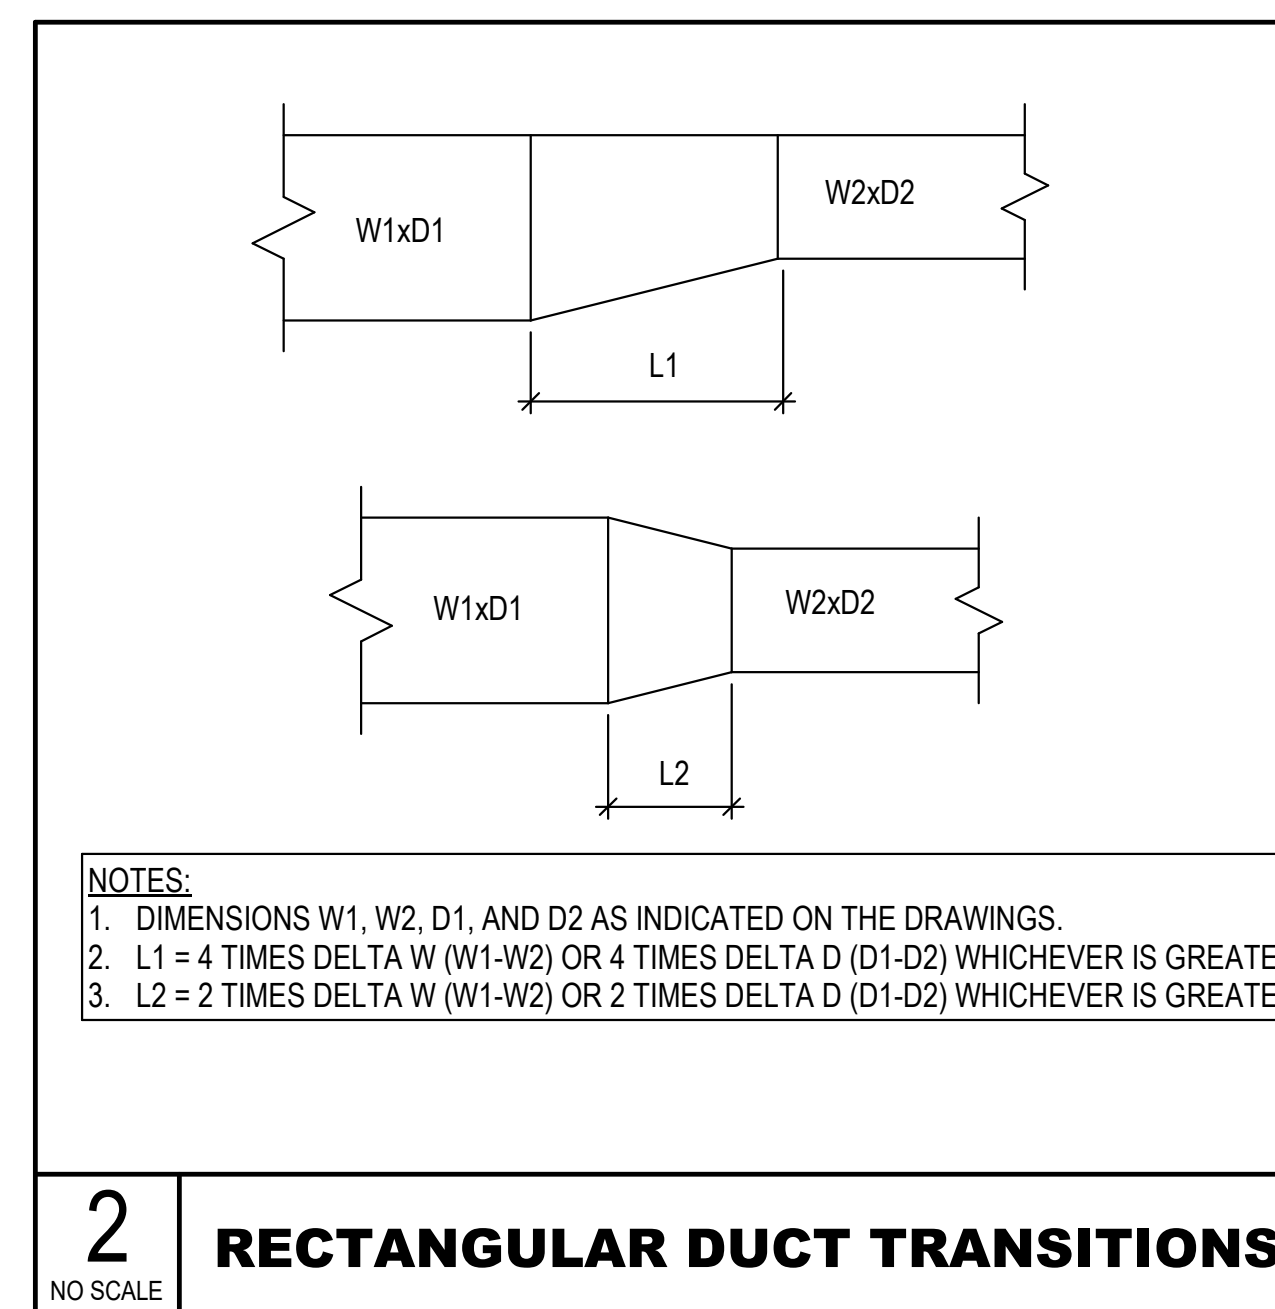


2 RECTANGULAR DUCT TRANSITIONS
NO SCALE

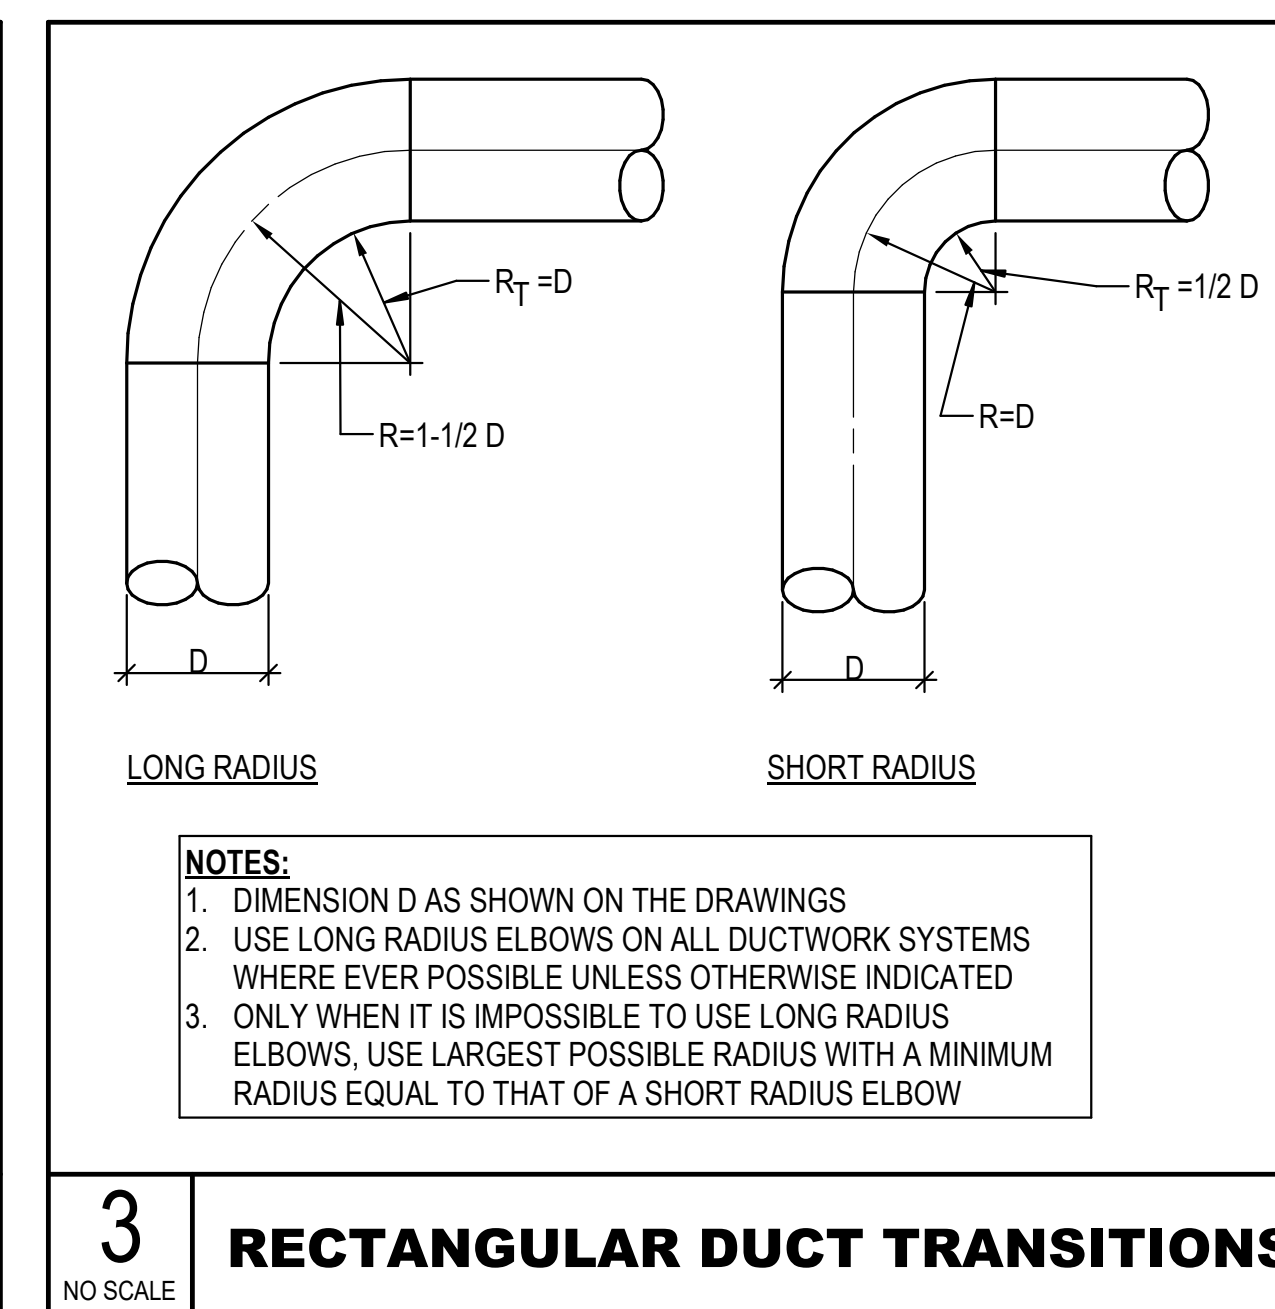


3 RECTANGULAR DUCT TRANSITIONS
NO SCALE

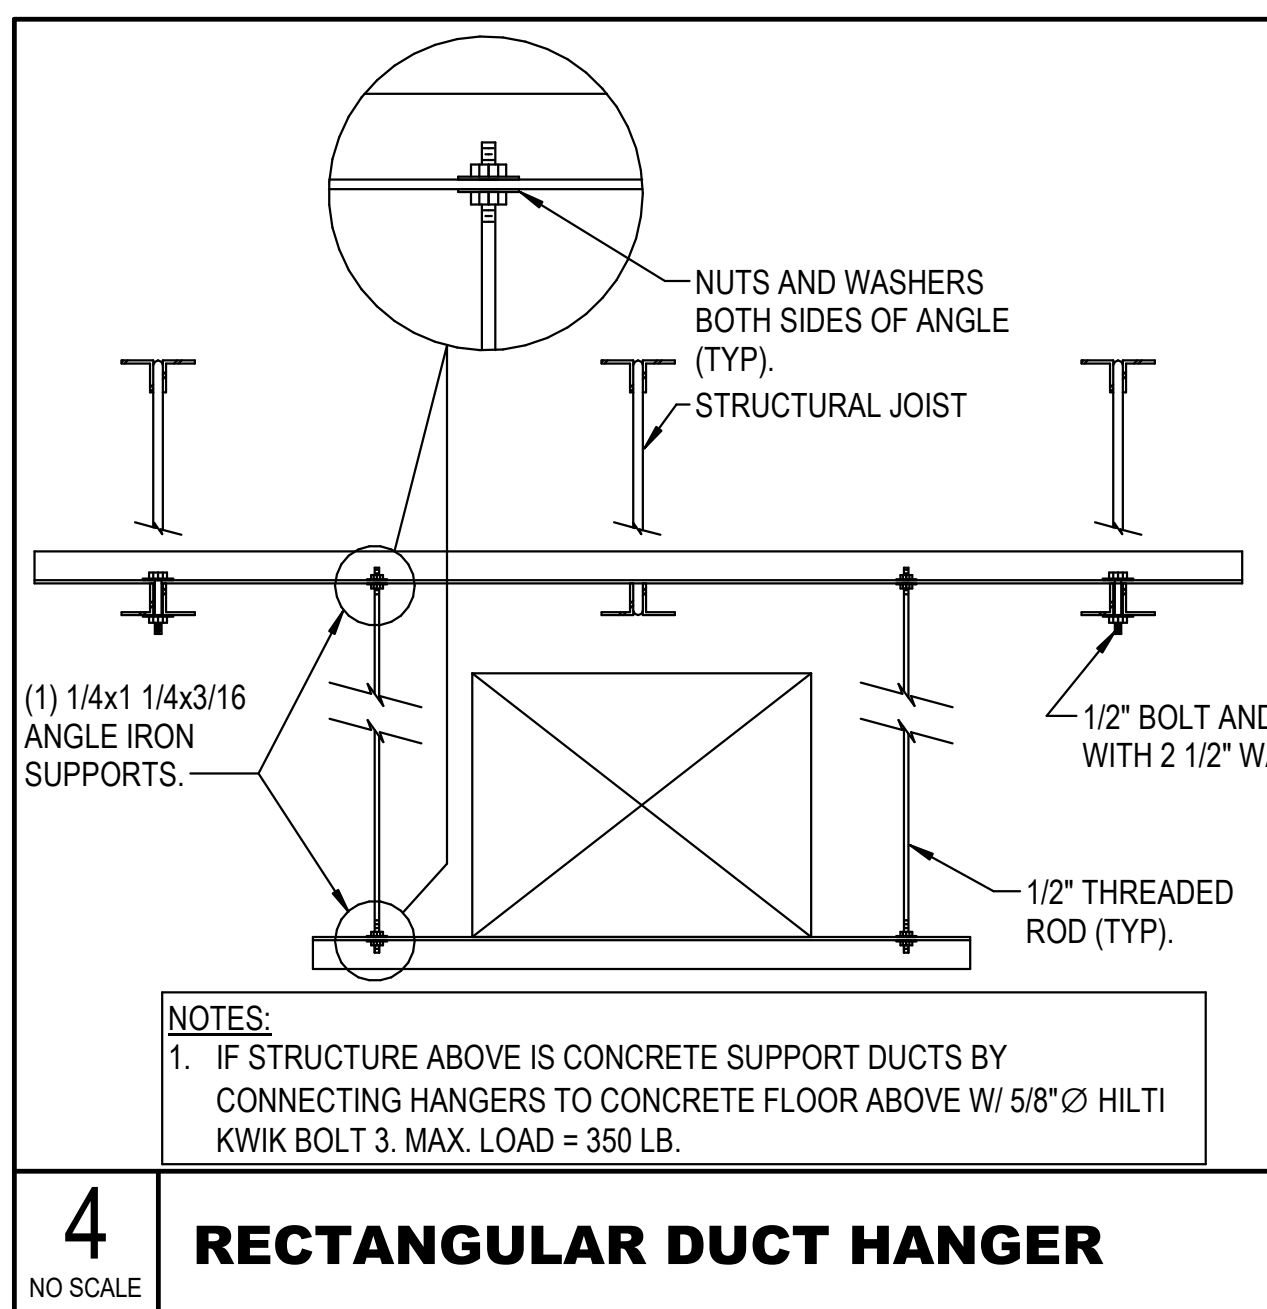


4 RECTANGULAR DUCT HANGER
NO SCALE

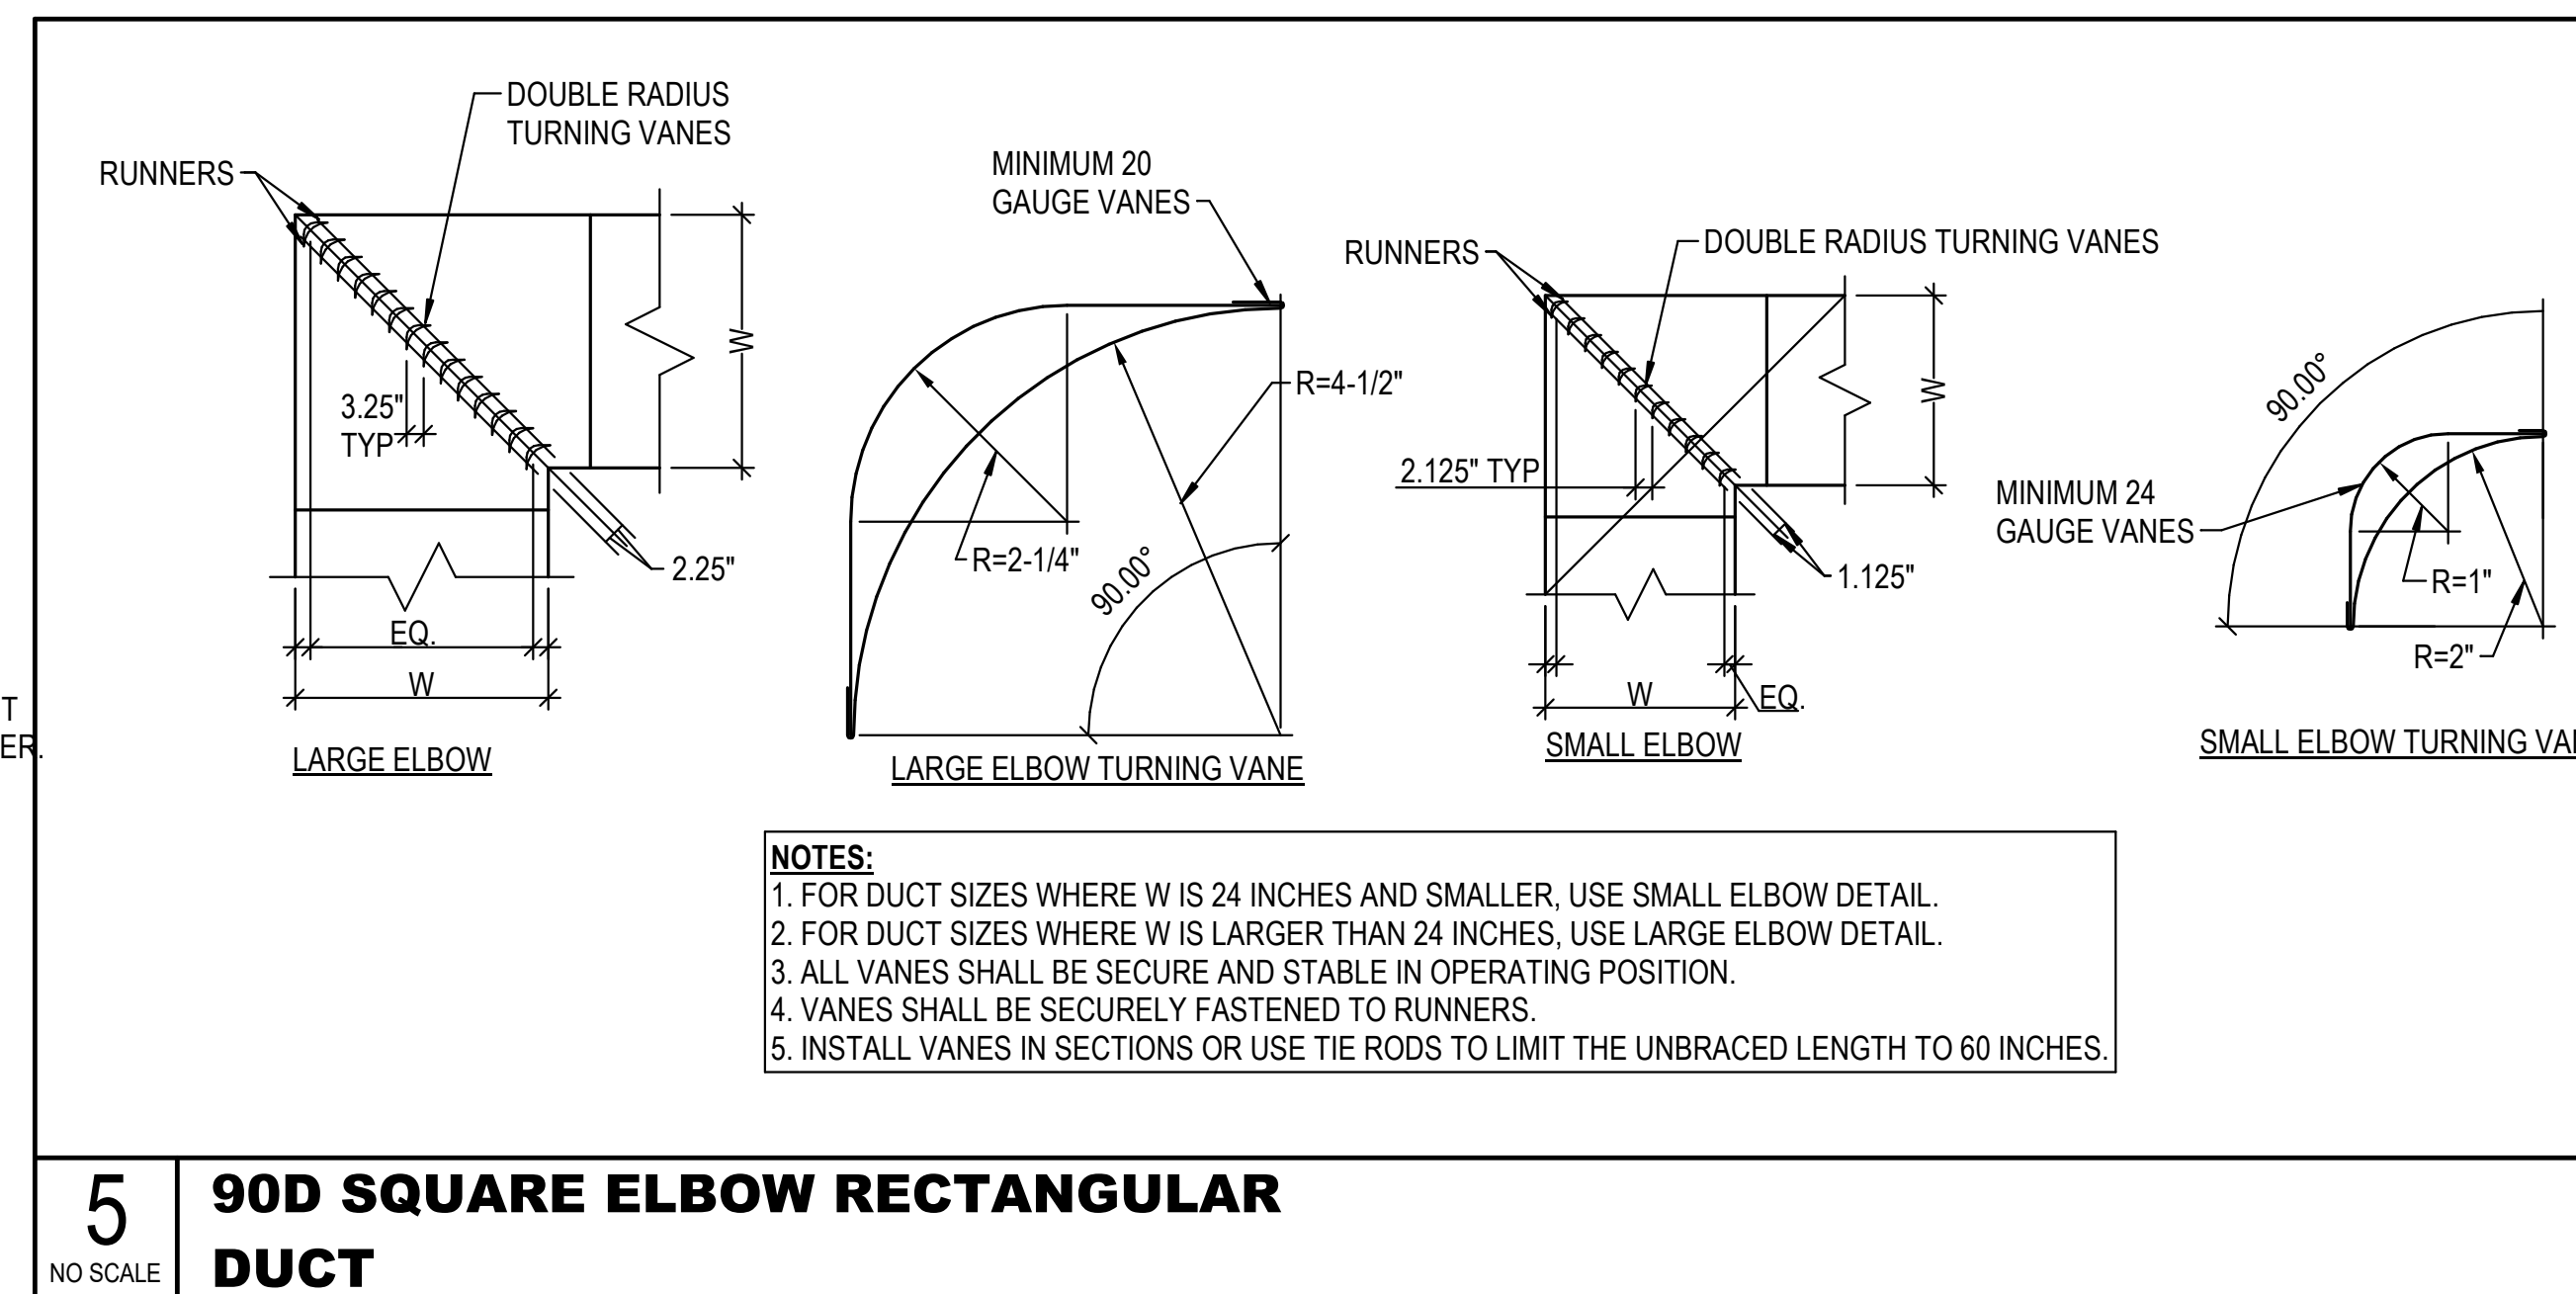


5 90D SQUARE ELBOW RECTANGULAR DUCT
NO SCALE

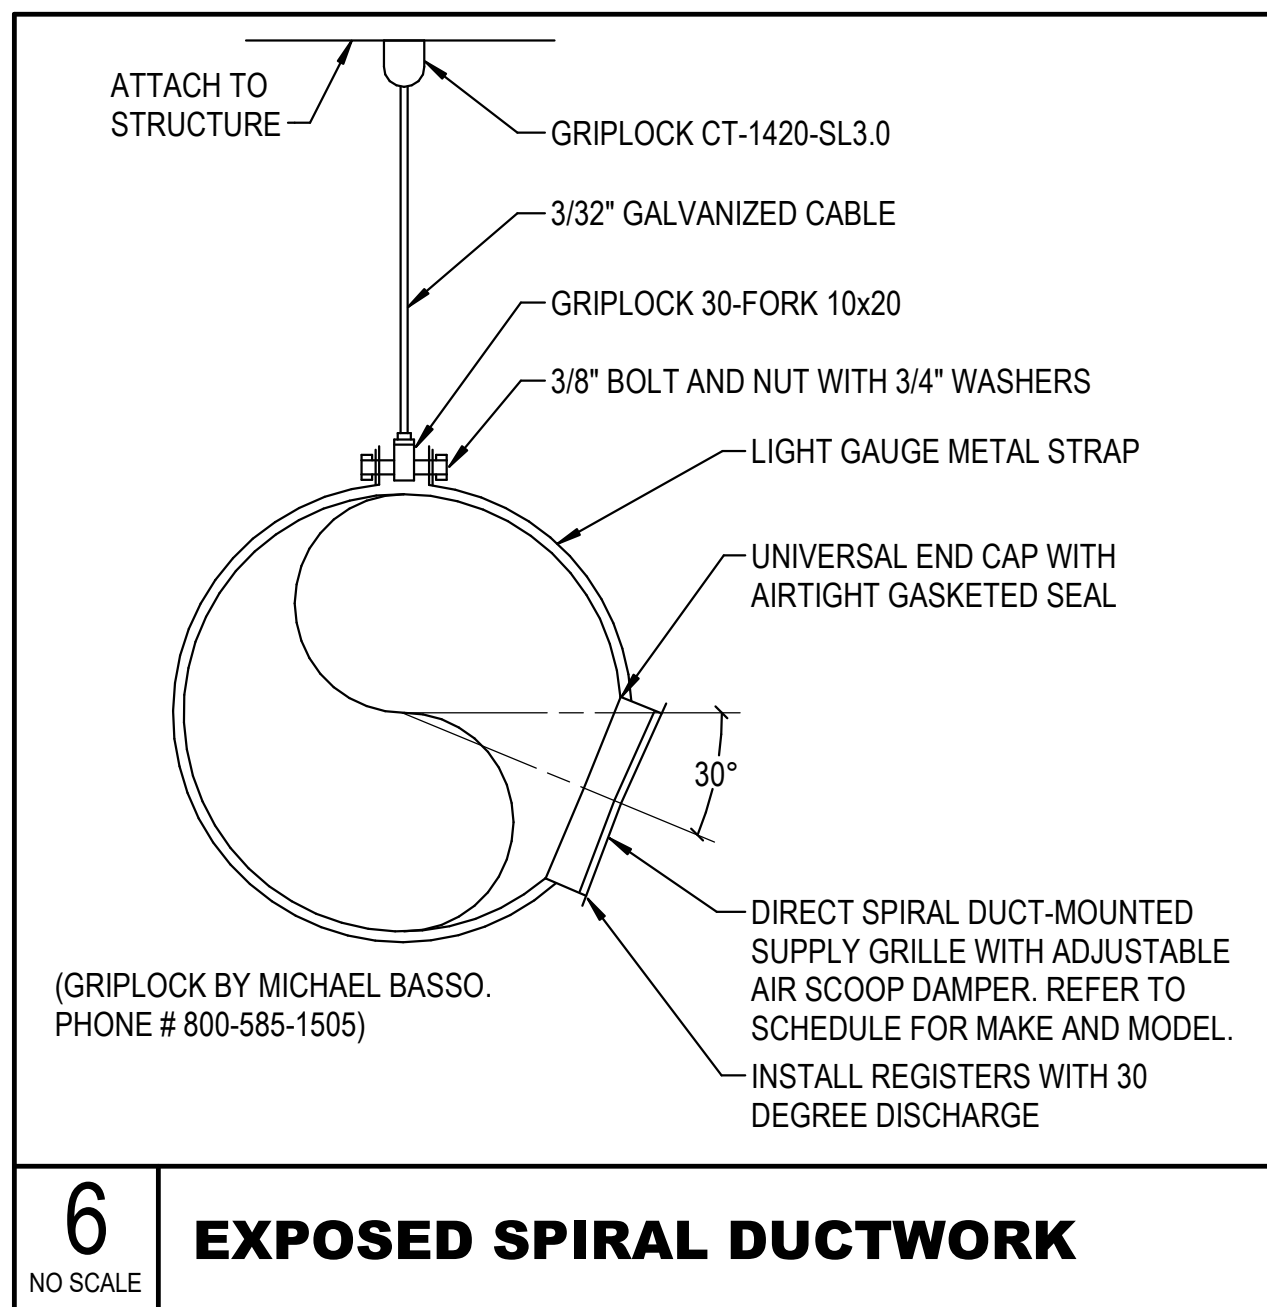

6 EXPOSED SPIRAL DUCTWORK
NO SCALE

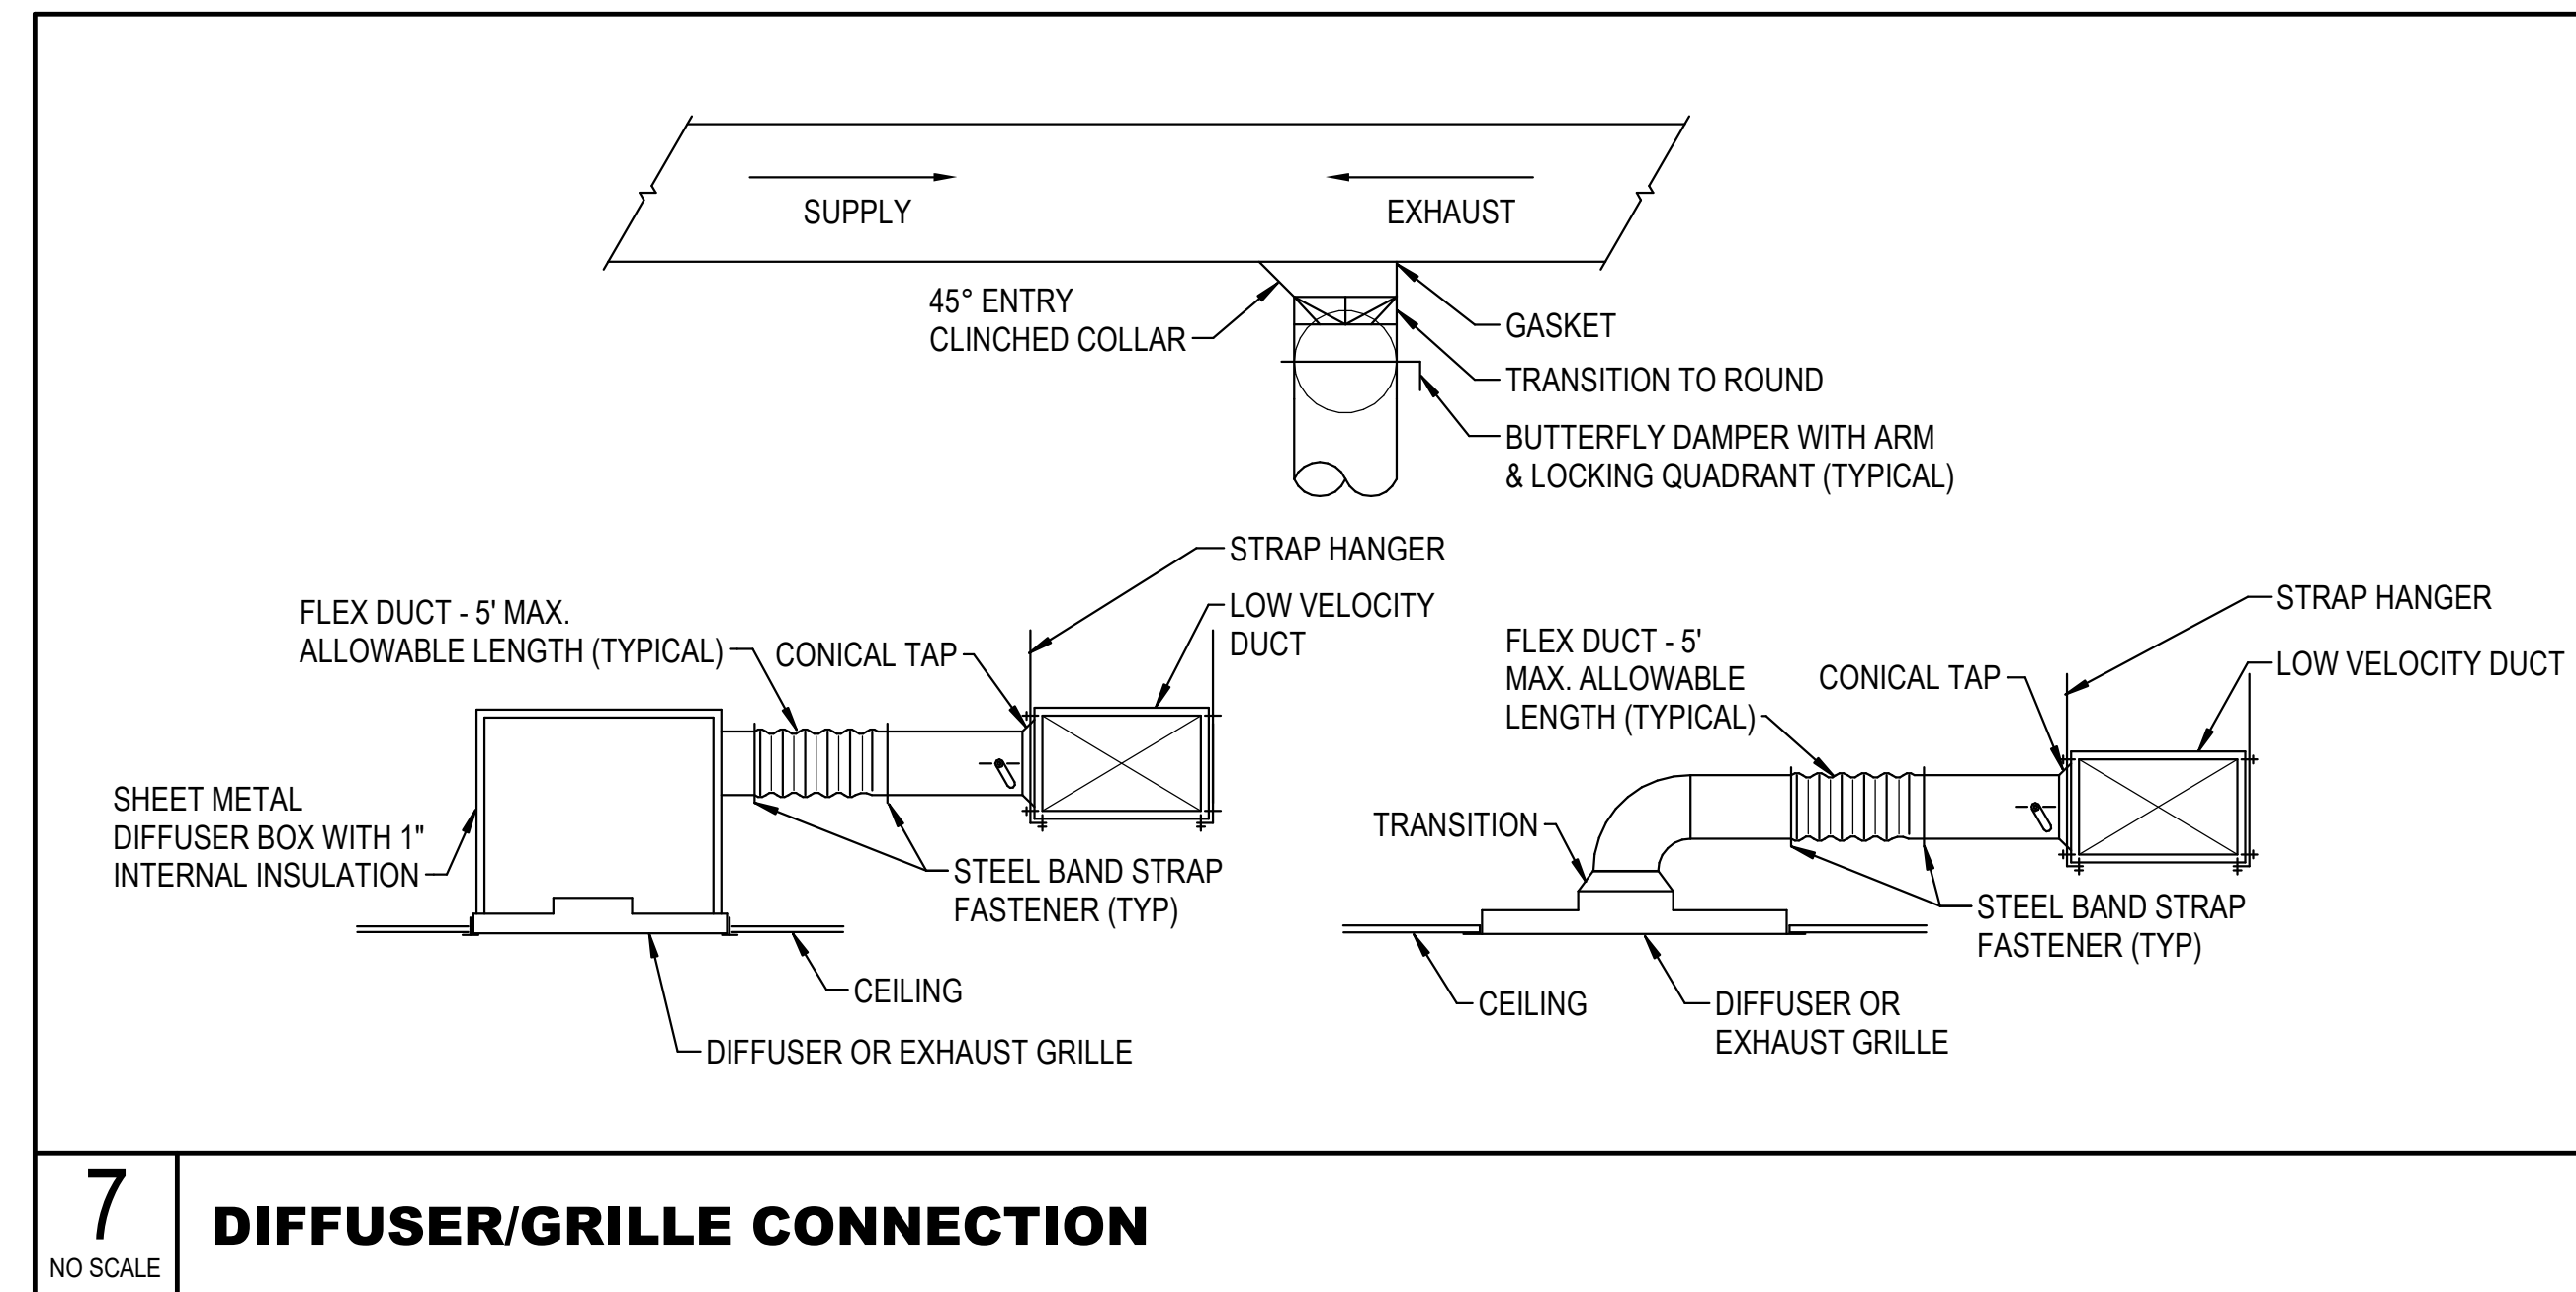

7 DIFFUSER/GRILLE CONNECTION
NO SCALE

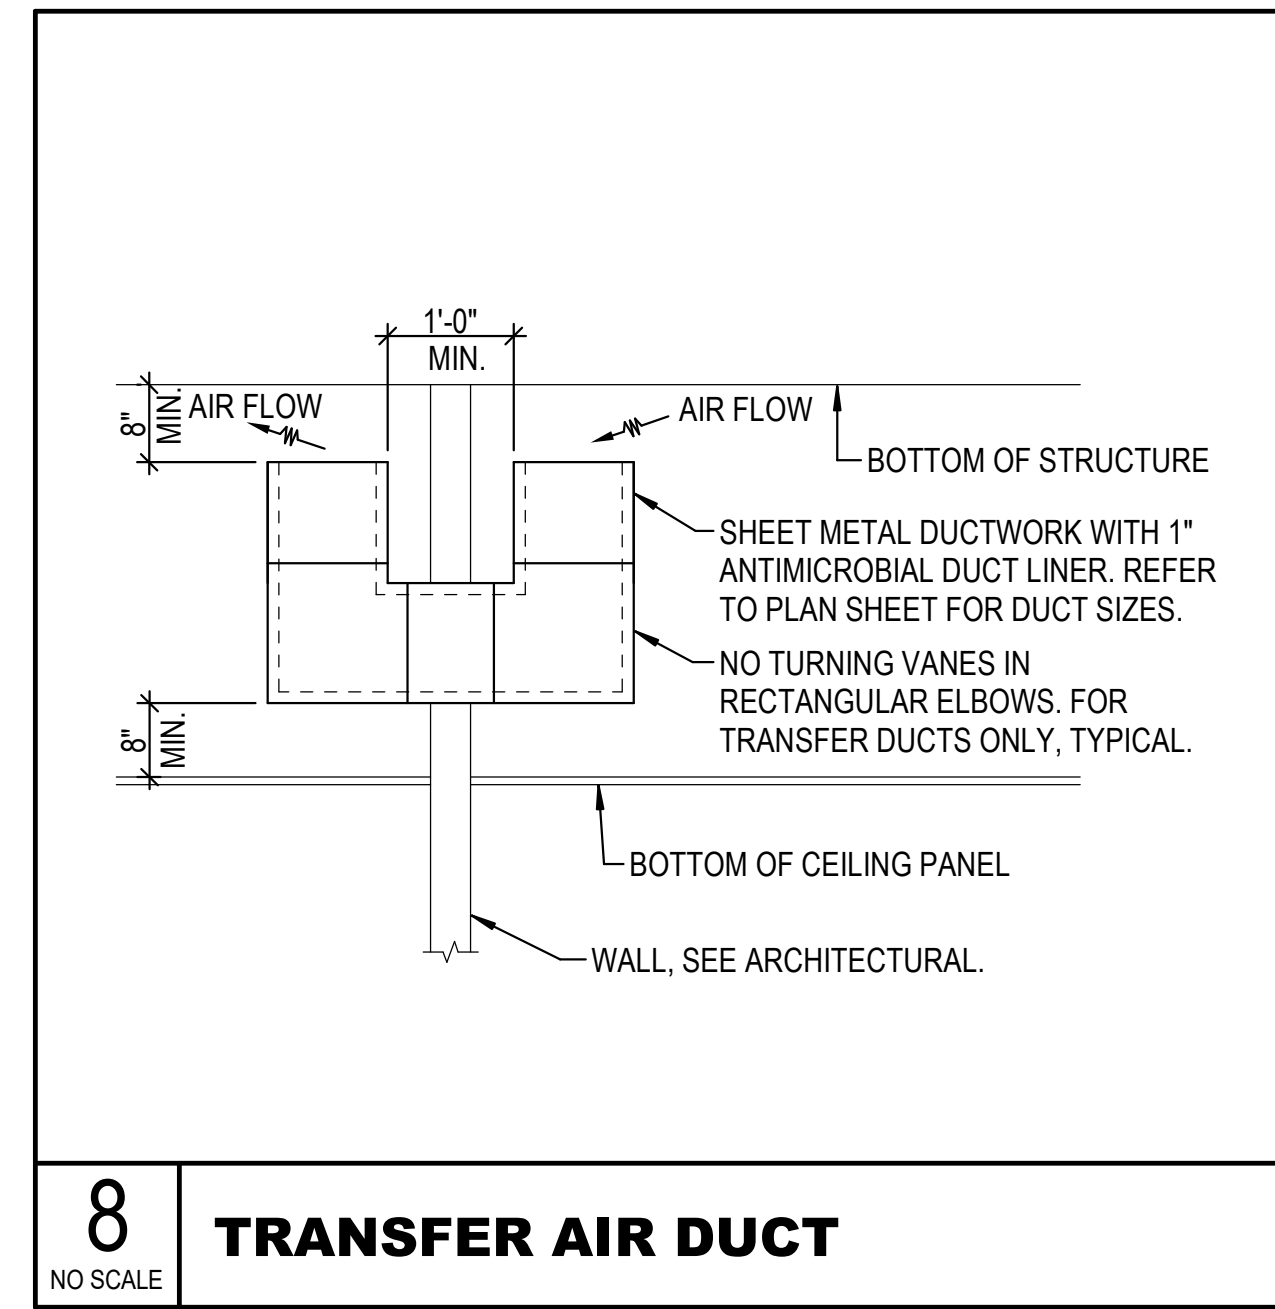

8 TRANSFER AIR DUCT
NO SCALE