


PLOTTED: Friday, November 11, 2022 @ 07:39AM

J:\PROJECTS\2022\01\10706_SCHROEDER_127TH AND PAWNEE\00_20706_CAD\SHS\05_CIVIL\GRD\20706_GRD_EXIST.CONDITIONS.DWG



!!WARNING!!
 HIGH PRESSURE PIPELINE
 NO EXCAVATION OR CONSTRUCTION
 IN THIS AREA WITHOUT ONE-CALL
 AND WITHOUT CONTACTING PHILLIPS
 66 PIPELINE LLC (PSSPL) AT
 316-761-1621.

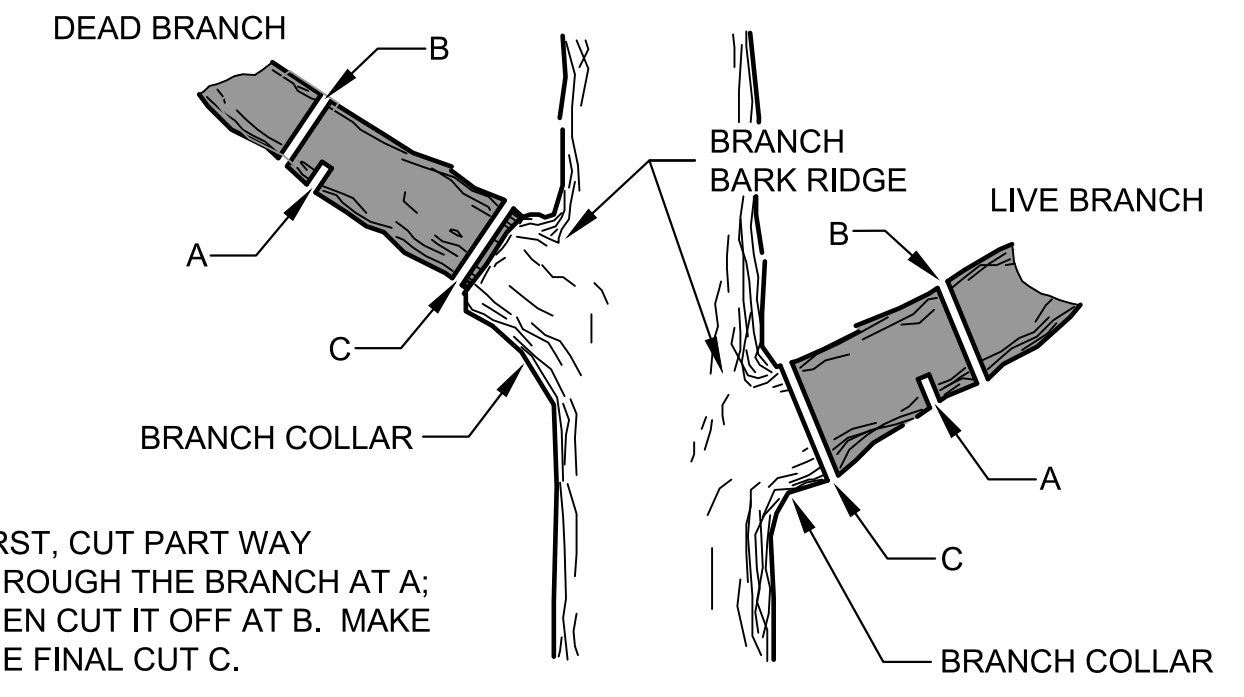


1 TREE TRIMMING DETAIL
 SCALE: NTS

TRIM BRANCHES AS NEEDED FOR
 UTILITY INSTALLATION. CONTRACTOR
 SHALL NOT REMOVE ANY TREES
 WITHOUT NOTIFYING OWNER AND
 ENGINEER PRIOR TO REMOVAL.

LEGEND

- - - 1250 - - - EXISTING CONTOUR
- W — EXISTING WATER
- S — EXISTING SANITARY SEWER
- S — EXISTING STORMWATER SEWER
- UGT — EXISTING UNDERGROUND TELEPHONE
- UGE — EXISTING UNDERGROUND ELECTRICAL
- OHE — EXISTING OVERHEAD ELECTRICAL
- G — EXISTING UNDERGROUND GAS

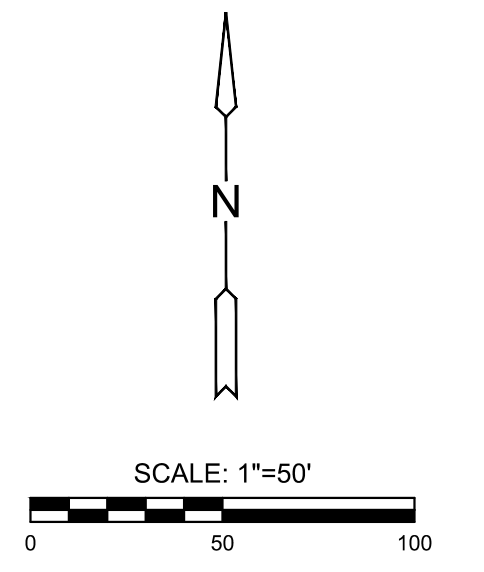

GRADING PLANS FOR
BUFFALO GROVE ADDITION
 WICHITA, KANSAS

©2022
 MKEC Engineering
 All Rights Reserved
 www.mkec.com
 These drawings and their contents,
 including, but not limited to, all concepts,
 designs, & ideas are the exclusive
 property of MKEC Engineering (MKEC),
 and may not be used or reproduced in any
 way without the express consent of MKEC.

**EXISTING
 CONDITIONS &
 DEMOLITION PLAN**

PROJECT NO.	458-2022-085514	
DATE	NOV 2022	
SCALE	1" = 50'	
DESIGNED	DRAWN	CHECKED
KPG	MKEC	KPG
NO.	REVISION	DATE