
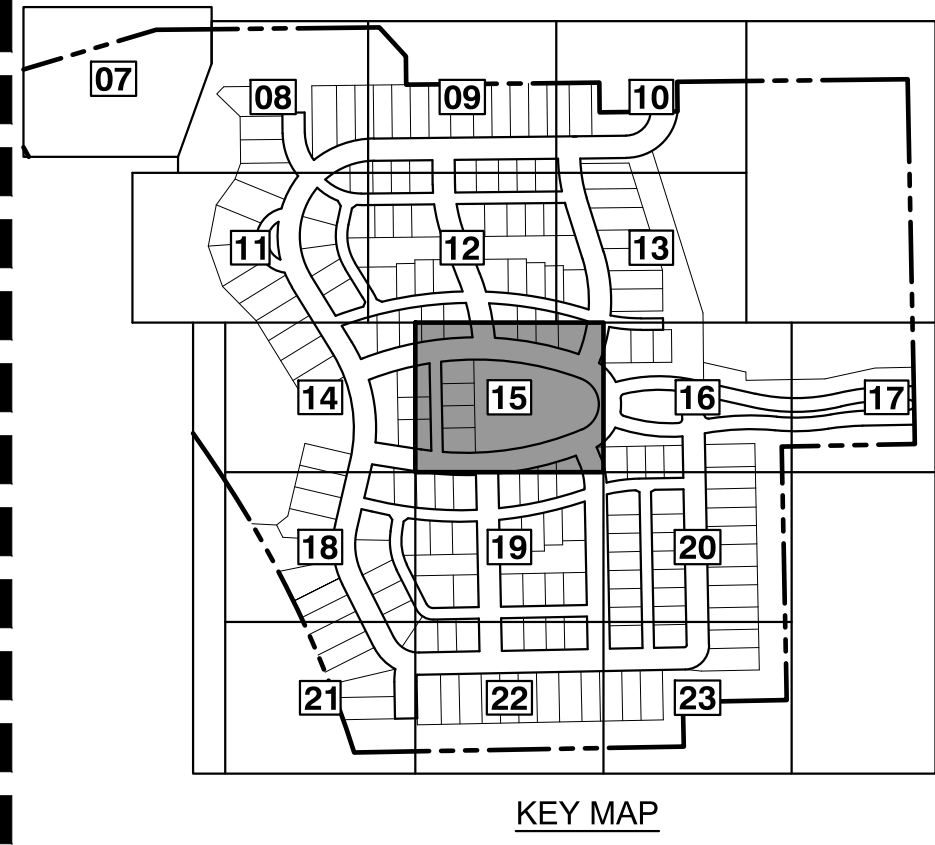



J:\PROJECTS\2022\121010427_PERFECTION_COURTYARDS AT MOORINGS\DWG\210427 CAD\SHOTS\05 CIVIL\GRD\PH121427-05-1210.DWG
 PLOTTED: Monday, January 09, 2023 @ 08:30AM

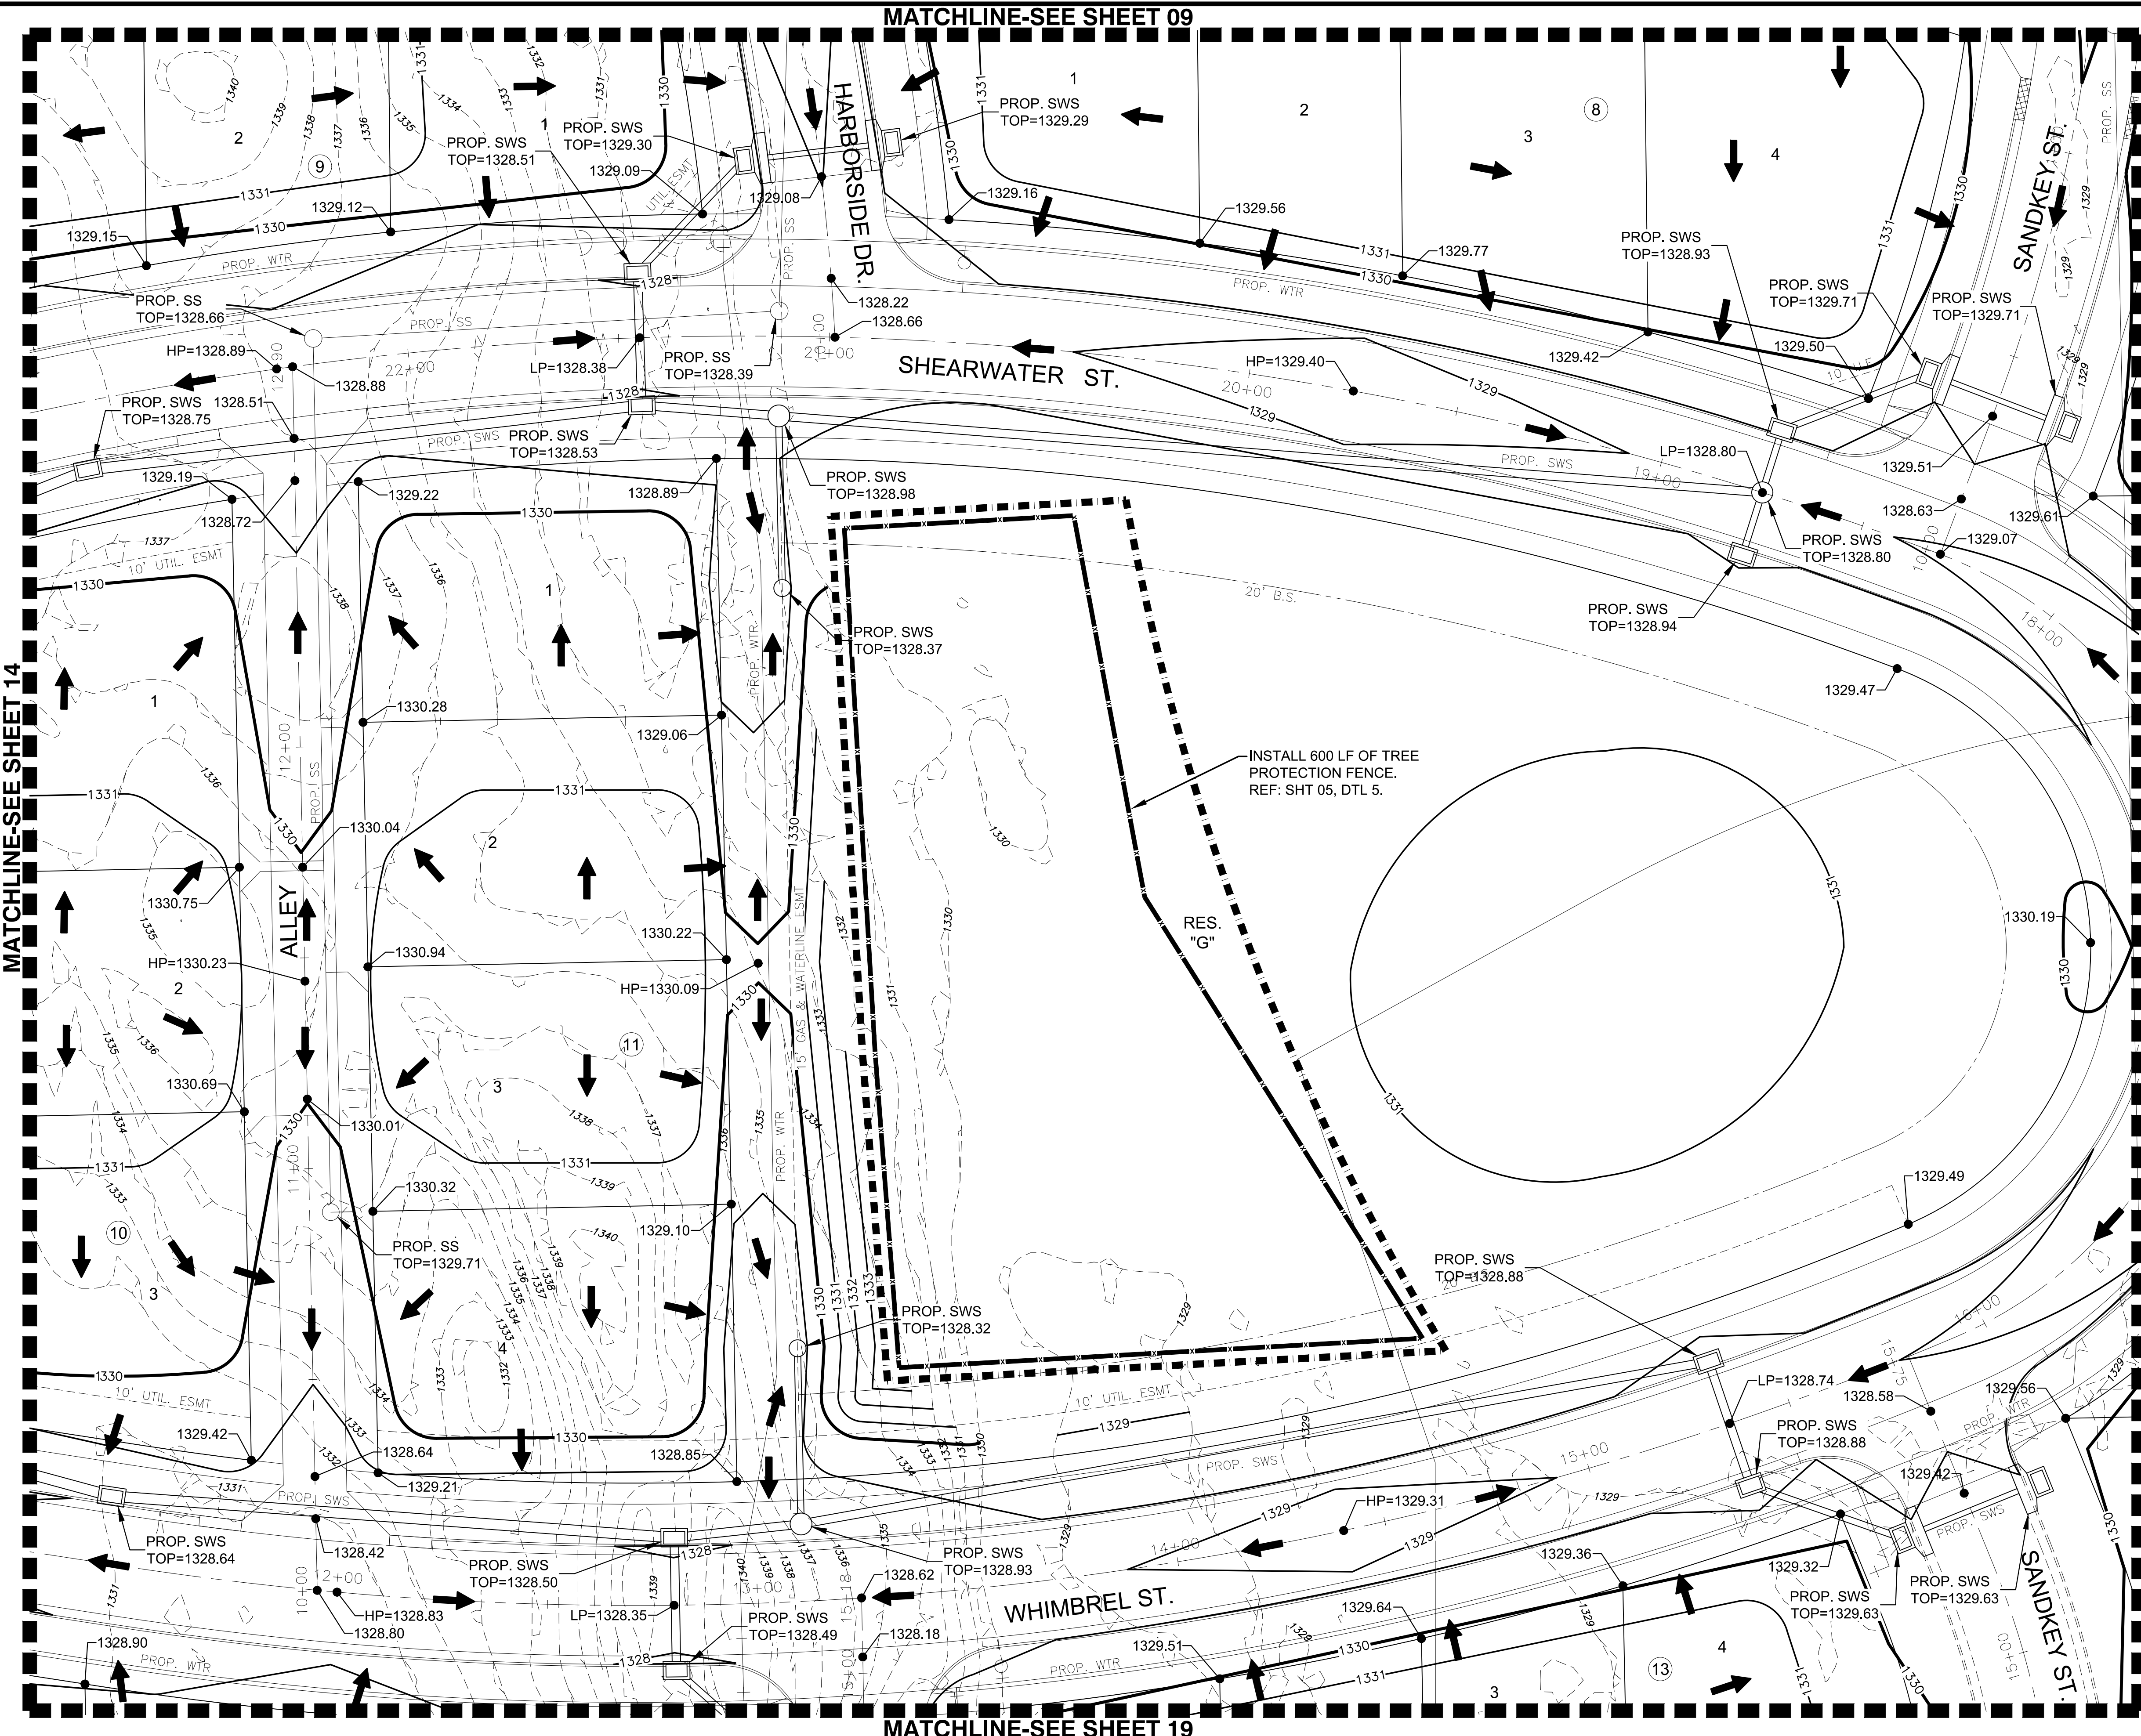

NOTES:
VERTICAL DATUM USED IS NAVD88.

LEGEND

	1250	EXISTING CONTOUR
	1250	PROPOSED CONTOUR
	W	PROP. WATERLINE
		PROP. STORMWATER SEWER
		PROP. SANITARY SEWER
	W	EXIST. STORMWATER SEWER
		EXIST. STORMWATER SEWER
		EXIST. SANITARY SEWER
	UGT	EXIST. UNDERGROUND TELEPHONE
	UGE	EXIST. UNDERGROUND ELECTRICAL
	OHE	EXIST. OVERHEAD ELECTRICAL
		LIMITS OF GRADING
	1329.86	SPOT ELEVATIONS
		TREE PROTECTION

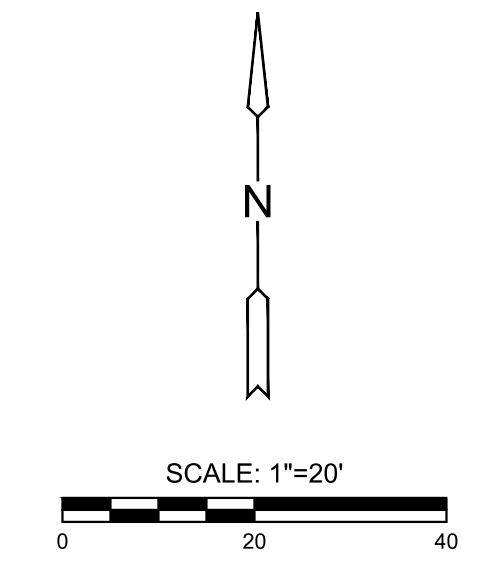

MASS GRADING PLANS FOR
COURTYARDS AT THE MOORINGS
 WICHITA, KS

©2023
 MKEC Engineering
 All Rights Reserved
 www.mkec.com
 These drawings and their contents, including, but not limited to, all concepts, designs, & ideas are the exclusive property of MKEC Engineering (MKEC), and may not be used or reproduced in any way without the express consent of MKEC.

GRADING PLAN

PROJECT NO.	458-2022-085511	
DATE	JAN. 2023	
SCALE	1" = 20'	
DESIGNED	DML	
DRAWN	CJL	
CHECKED	SPE	
NO.	REVISION	DATE
SHEET NO. 15 OF 43		