
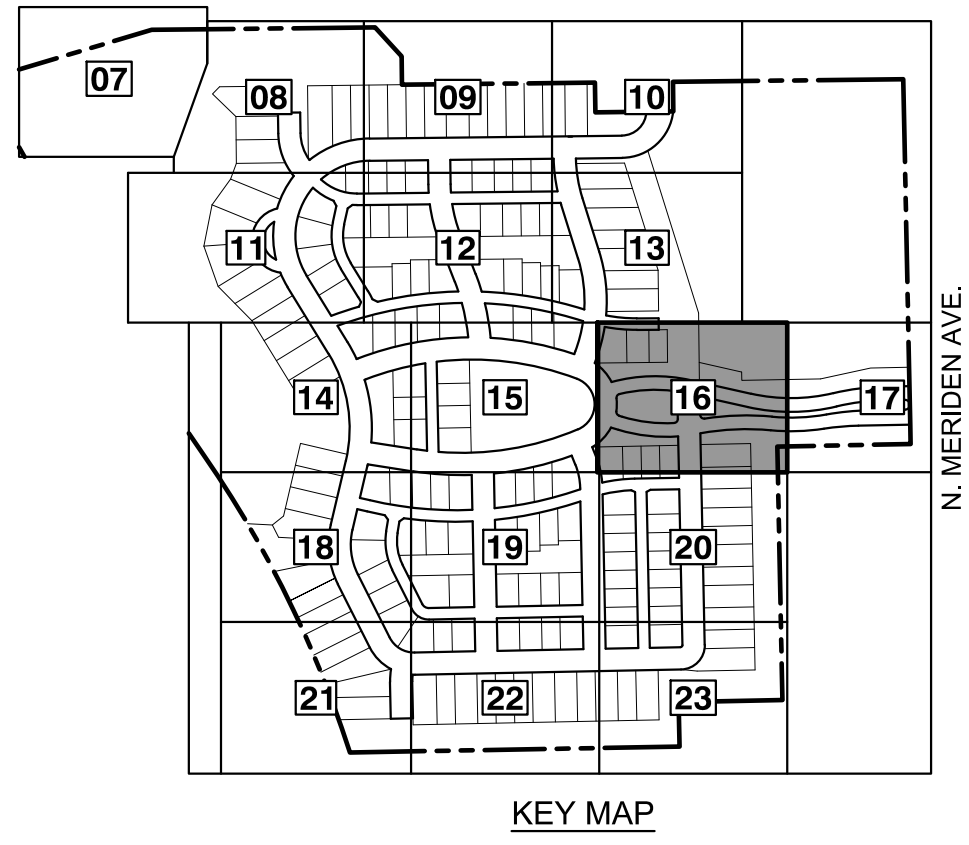



J:\PROJECTS\2022\12\10\10427_PERFECTION_COURTYARDS_AT_MOORINGS\DWG\210427_CAD\SH1\516_CIVIL\GRD\PH12\1227-05-1211.DWG
 PLOTTED: Monday, January 09, 2023 @ 08:32AM

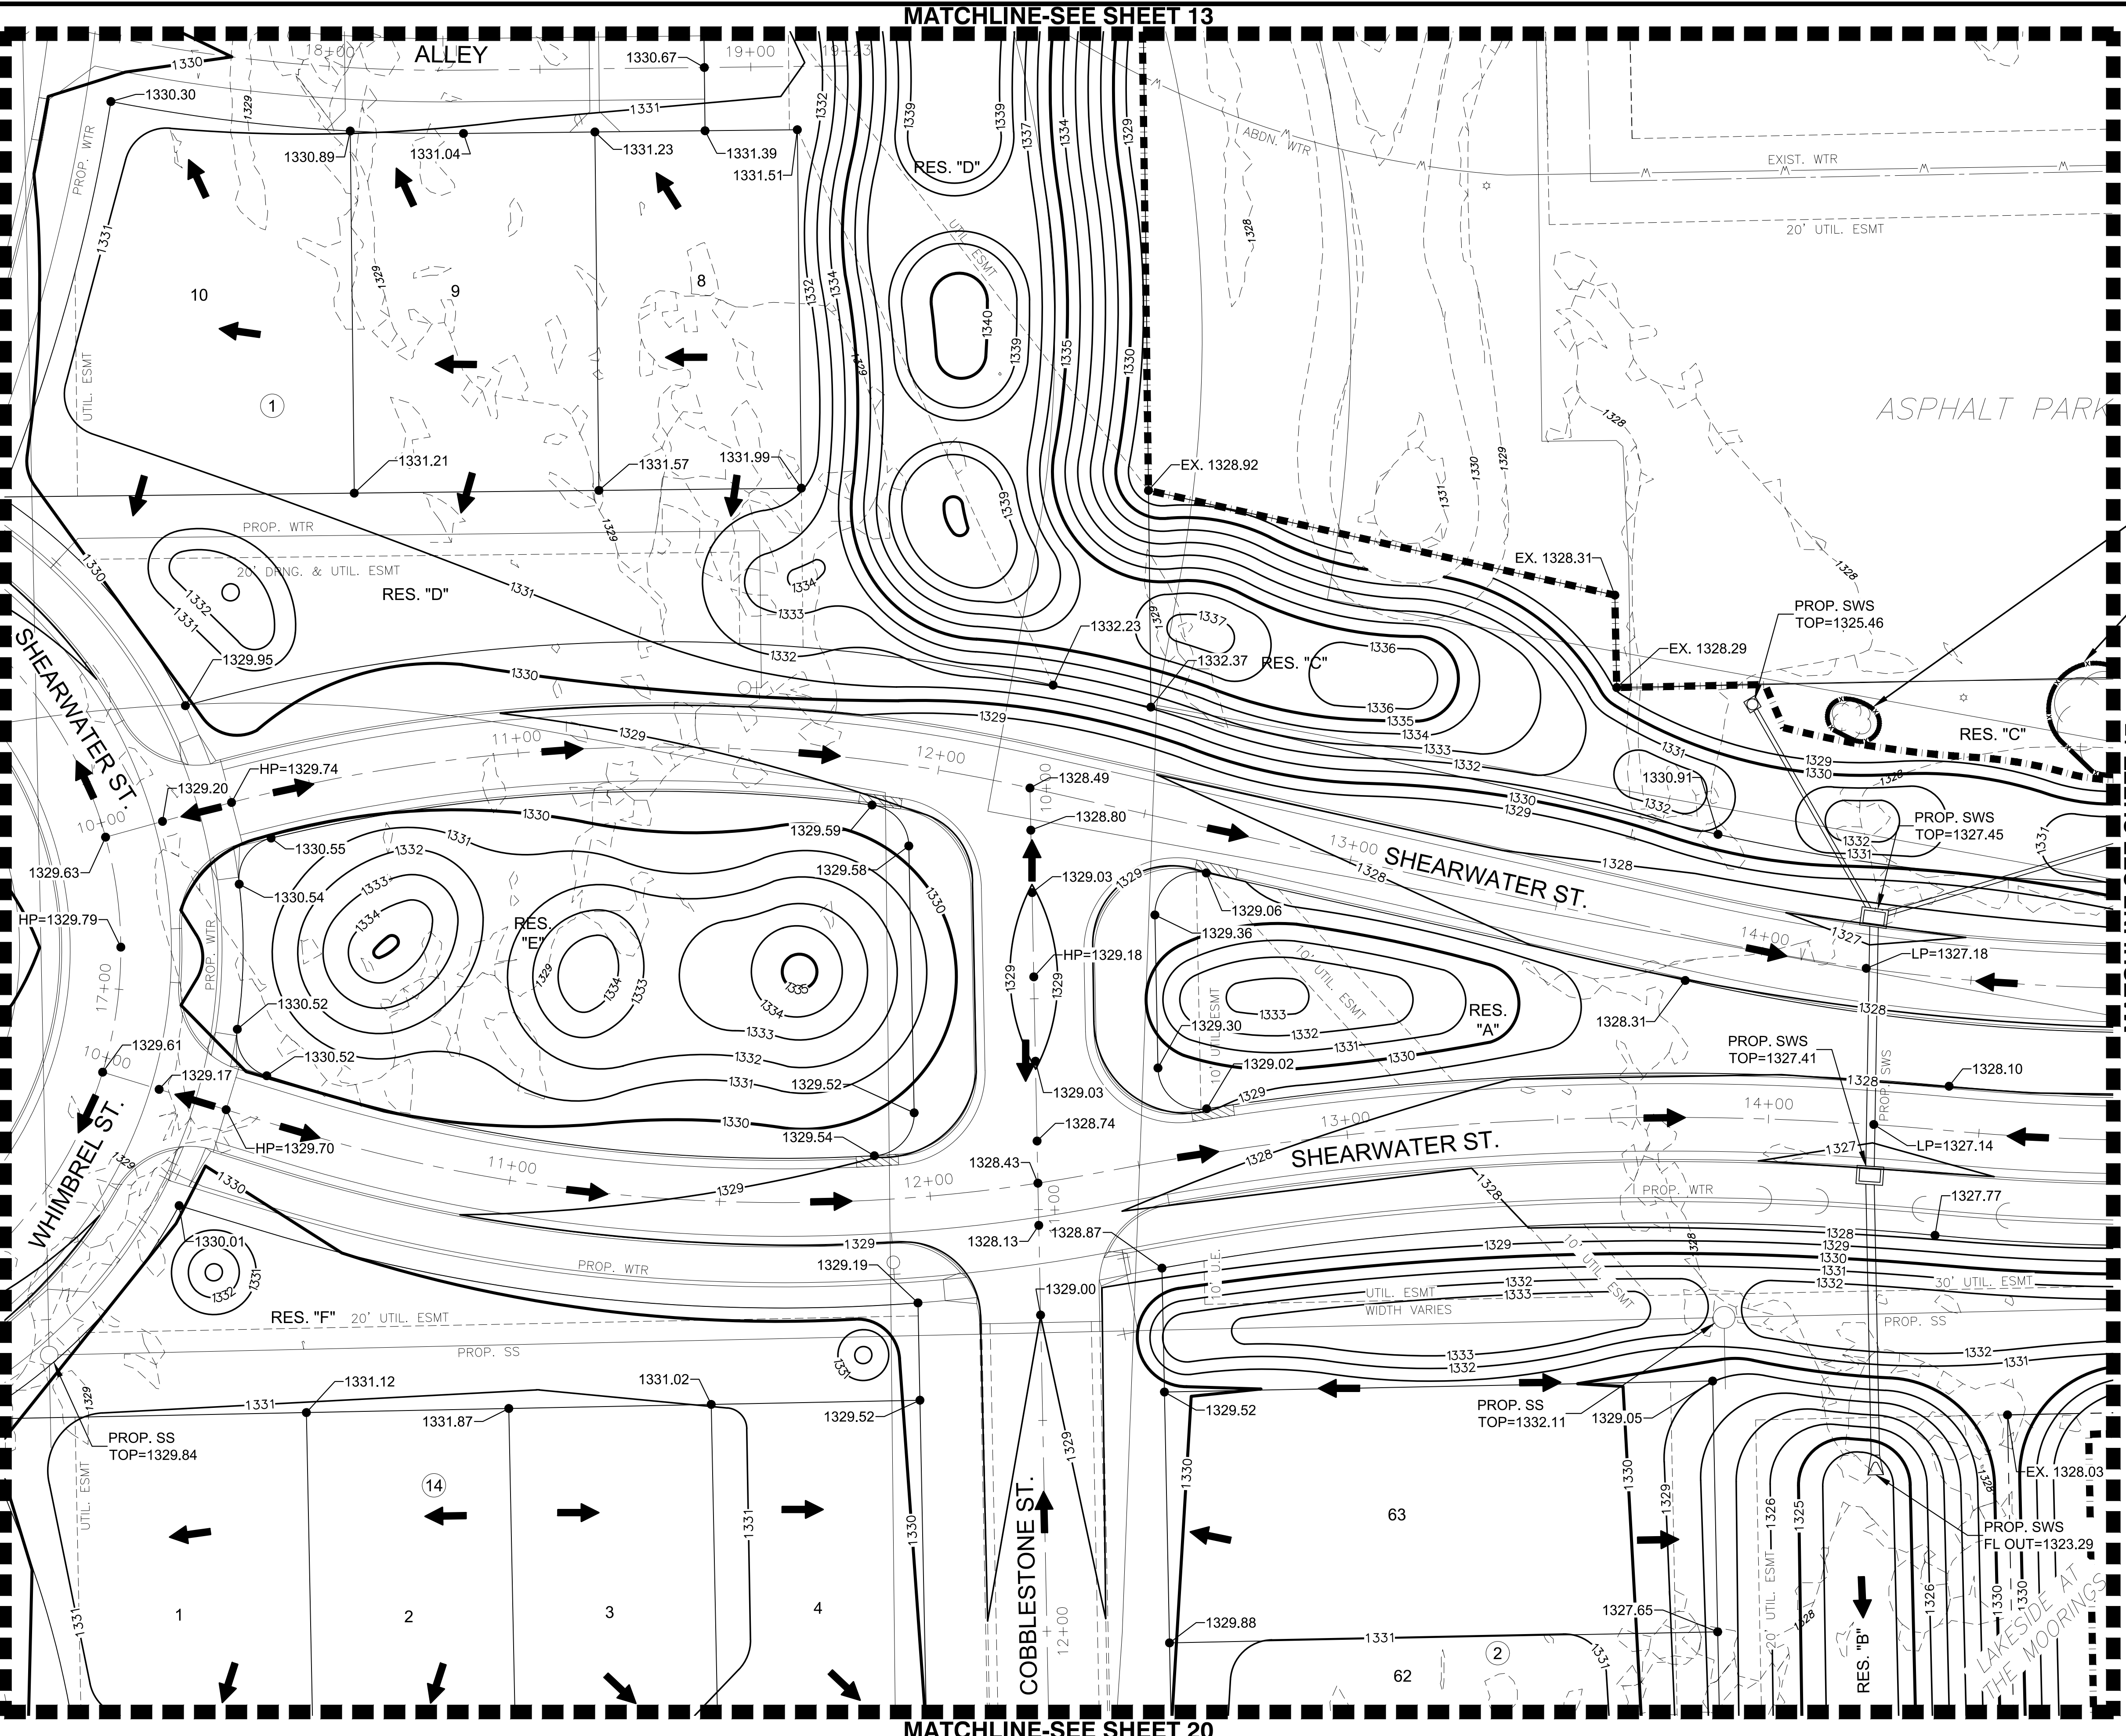

INSTALL 35 LF OF TREE PROTECTION FENCE. REF: SHT 05, DTL 4.
 INSTALL 85 LF OF TREE PROTECTION FENCE. REF: SHT 05, DTL 4.
 NOTES:
 VERTICAL DATUM USED IS NAVD88.

LEGEND

	EXISTING CONTOUR
	PROPOSED CONTOUR
	PROP. WATERLINE
	PROP. STORMWATER SEWER
	PROP. SANITARY SEWER
	EXIST. STORMWATER SEWER
	EXIST. SANITARY SEWER
	EXIST. UNDERGROUND TELEPHONE
	EXIST. UNDERGROUND ELECTRICAL
	EXIST. OVERHEAD ELECTRICAL
	LIMITS OF GRADING
	SPOT ELEVATIONS
	TREE PROTECTION

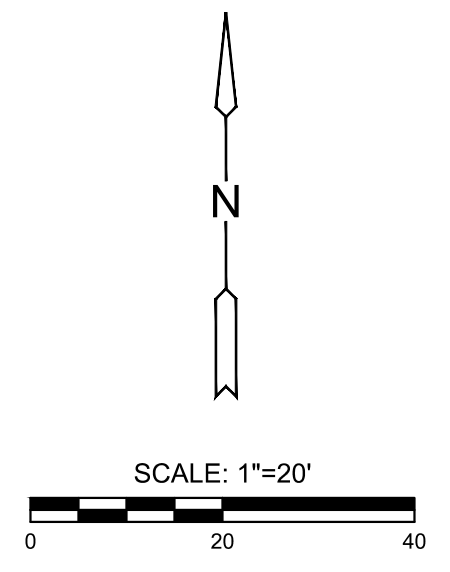

MASS GRADING PLANS FOR
COURTYARDS AT THE MOORINGS
 WICHITA, KS

©2023
 MKEC Engineering
 All Rights Reserved
 www.mkec.com
 These drawings and their contents, including, but not limited to, all concepts, designs, & ideas are the exclusive property of MKEC Engineering (MKEC), and may not be used or reproduced in any way without the express consent of MKEC.

GRADING PLAN

PROJECT NO.	458-2022-085511	
DATE	JAN. 2023	
SCALE	1" = 20'	
DESIGNED	DML	
DRAWN	C-JL	
CHECKED	SPE	
NO.	REVISION	DATE
SHEET NO.		
16 OF 43		