

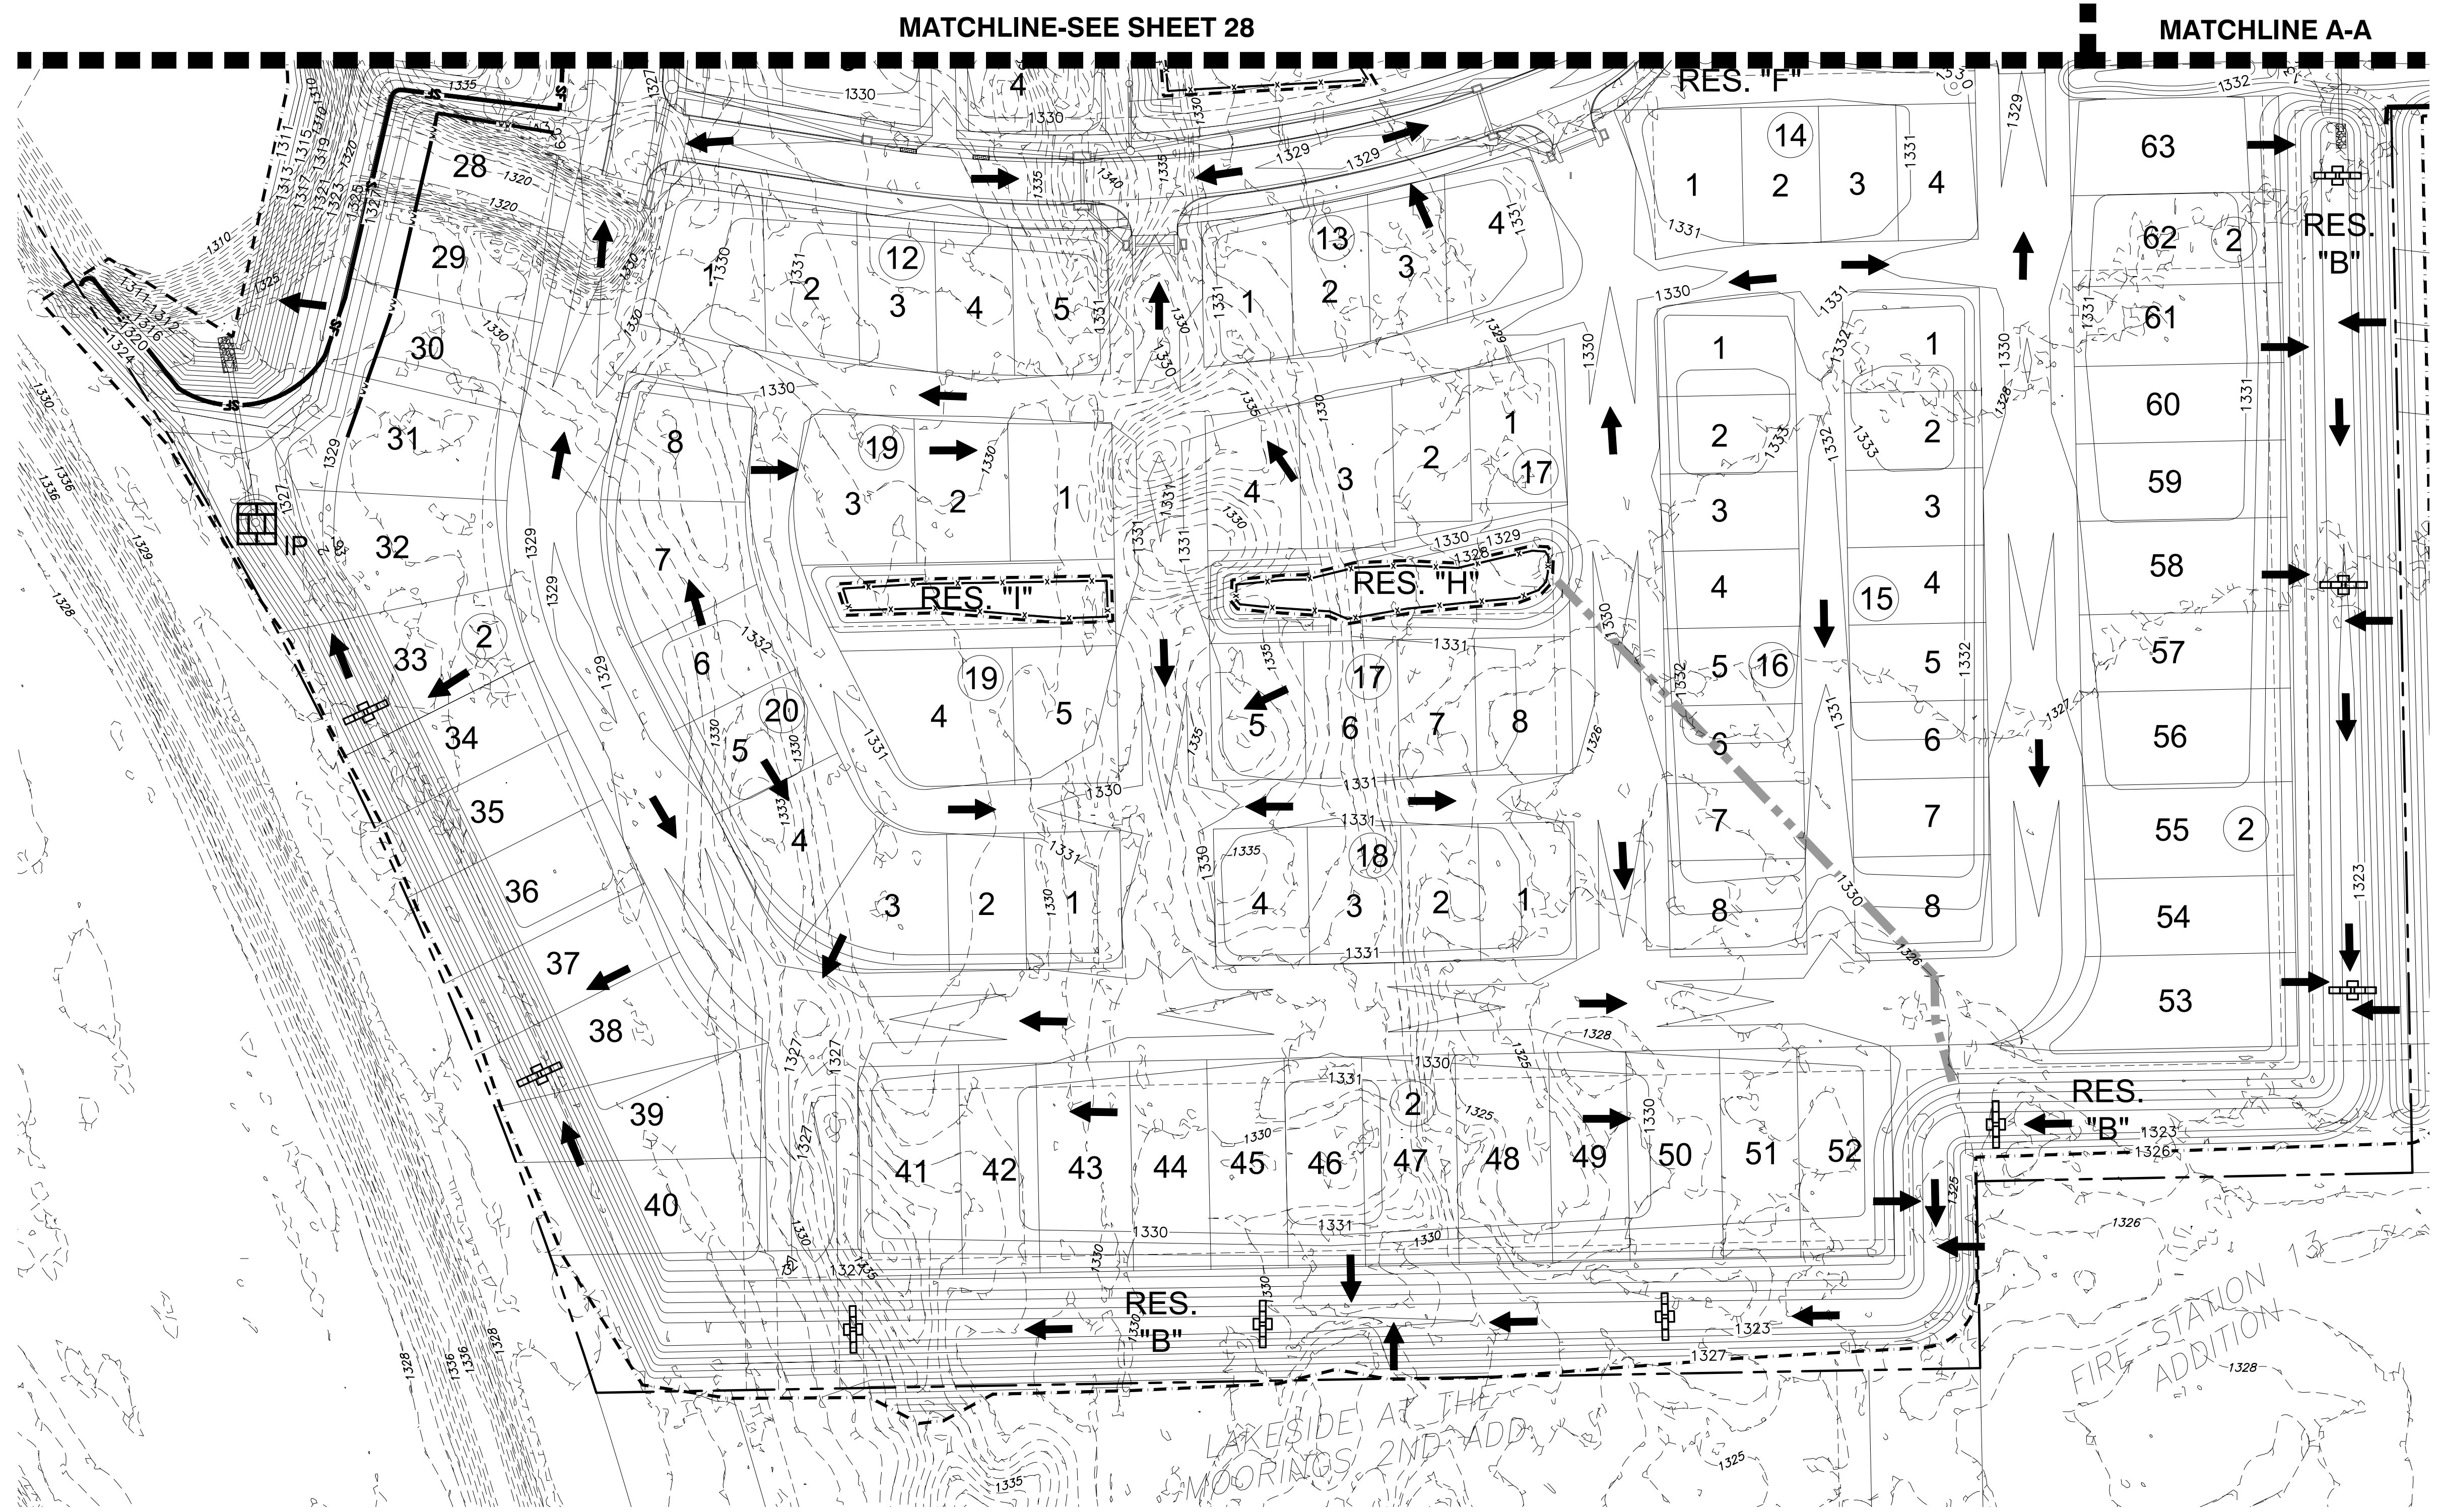
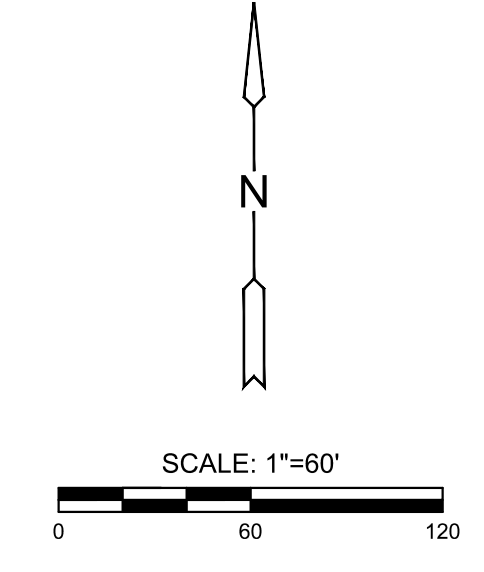


J:\PROJECTS\2022\121010427_PERFECTION_COURTYARDS_AT_MOORINGS\DWG\1210427_CAD\SHOTS\05_CIVIL\GRD\PH121427-05-6000.DWG
 PLOTTED: Monday, January 09, 2023 8:48:46AM

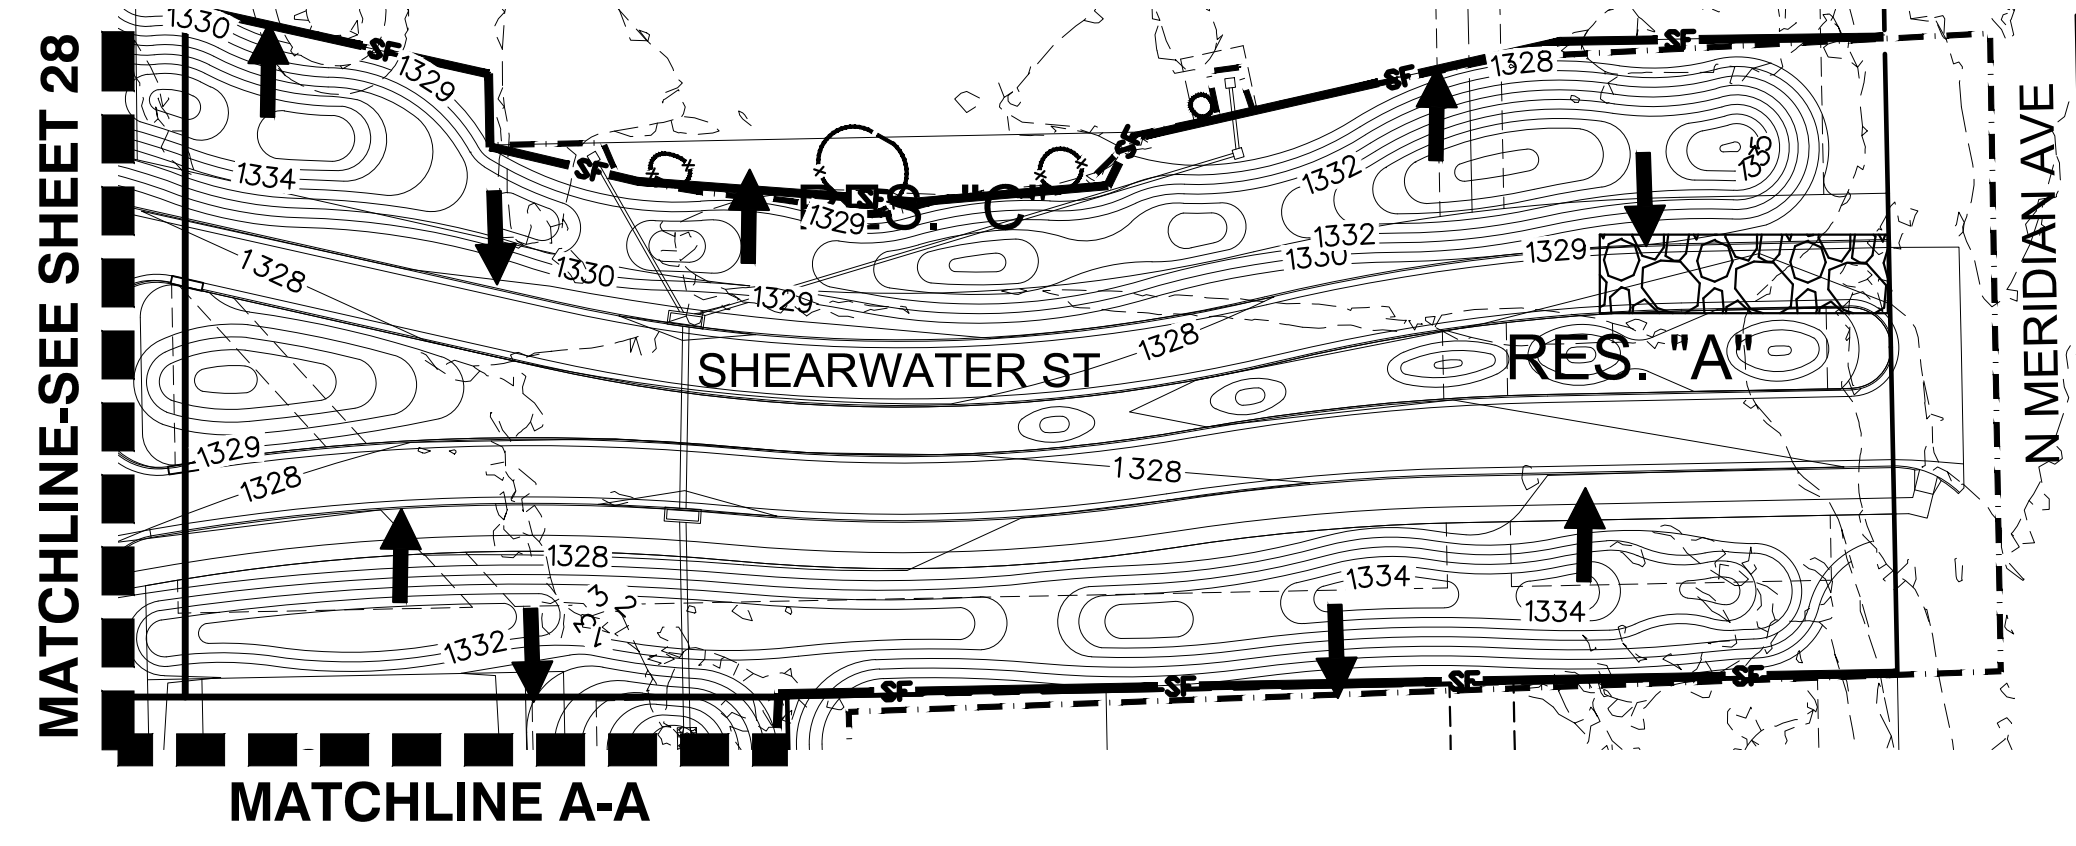

LEGEND

- 1370 --- EXIST. CONTOUR
- 1370 --- PROP. CONTOUR
- W --- WATERLINE
- S --- SANITARY SEWER
- SS --- STORMWATER SEWER
- UGE --- UNDERGROUND ELECTRICAL
- G --- GAS LINE
- FOC --- FIBER OPTIC CABLE
- FLOW ARROW
- SF --- SILT FENCE
- BC --- BACK OF CURB PROTECTION
- --- LIMITS OF GRADING
- --- STABILIZED CONSTRUCTION ENTRANCE
- --- STRAW BALE DITCH CHECK
- W --- 18" TALL WINDROW

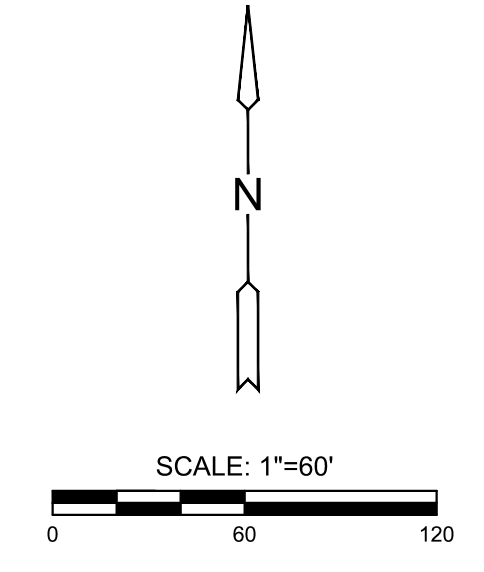

MASS GRADING PLANS FOR
COURTYARDS AT THE MOORINGS
 WICHITA, KS

©2023
 MKEC Engineering
 All Rights Reserved
 www.mkec.com
 These drawings and their contents, including, but not limited to, all concepts, designs, & ideas are the exclusive property of MKEC Engineering (MKEC), and may not be used or reproduced in any way without the express consent of MKEC.

EROSION CONTROL PLAN SOUTH

PROJECT NO.	458-2022-085511
DATE	JAN. 2023
SCALE	1" = 60'
DESIGNED	CJL
DRAWN	CJL
CHECKED	SPE

NO.	REVISION	DATE