



PLOTTED: Monday, January 09, 2023 @ 08:22AM

J:\PROJECTS\2022\12\10\10427_PERFECTION_COURTYARDS AT MOORINGS\DWG\12\10427-05-2023.DWG

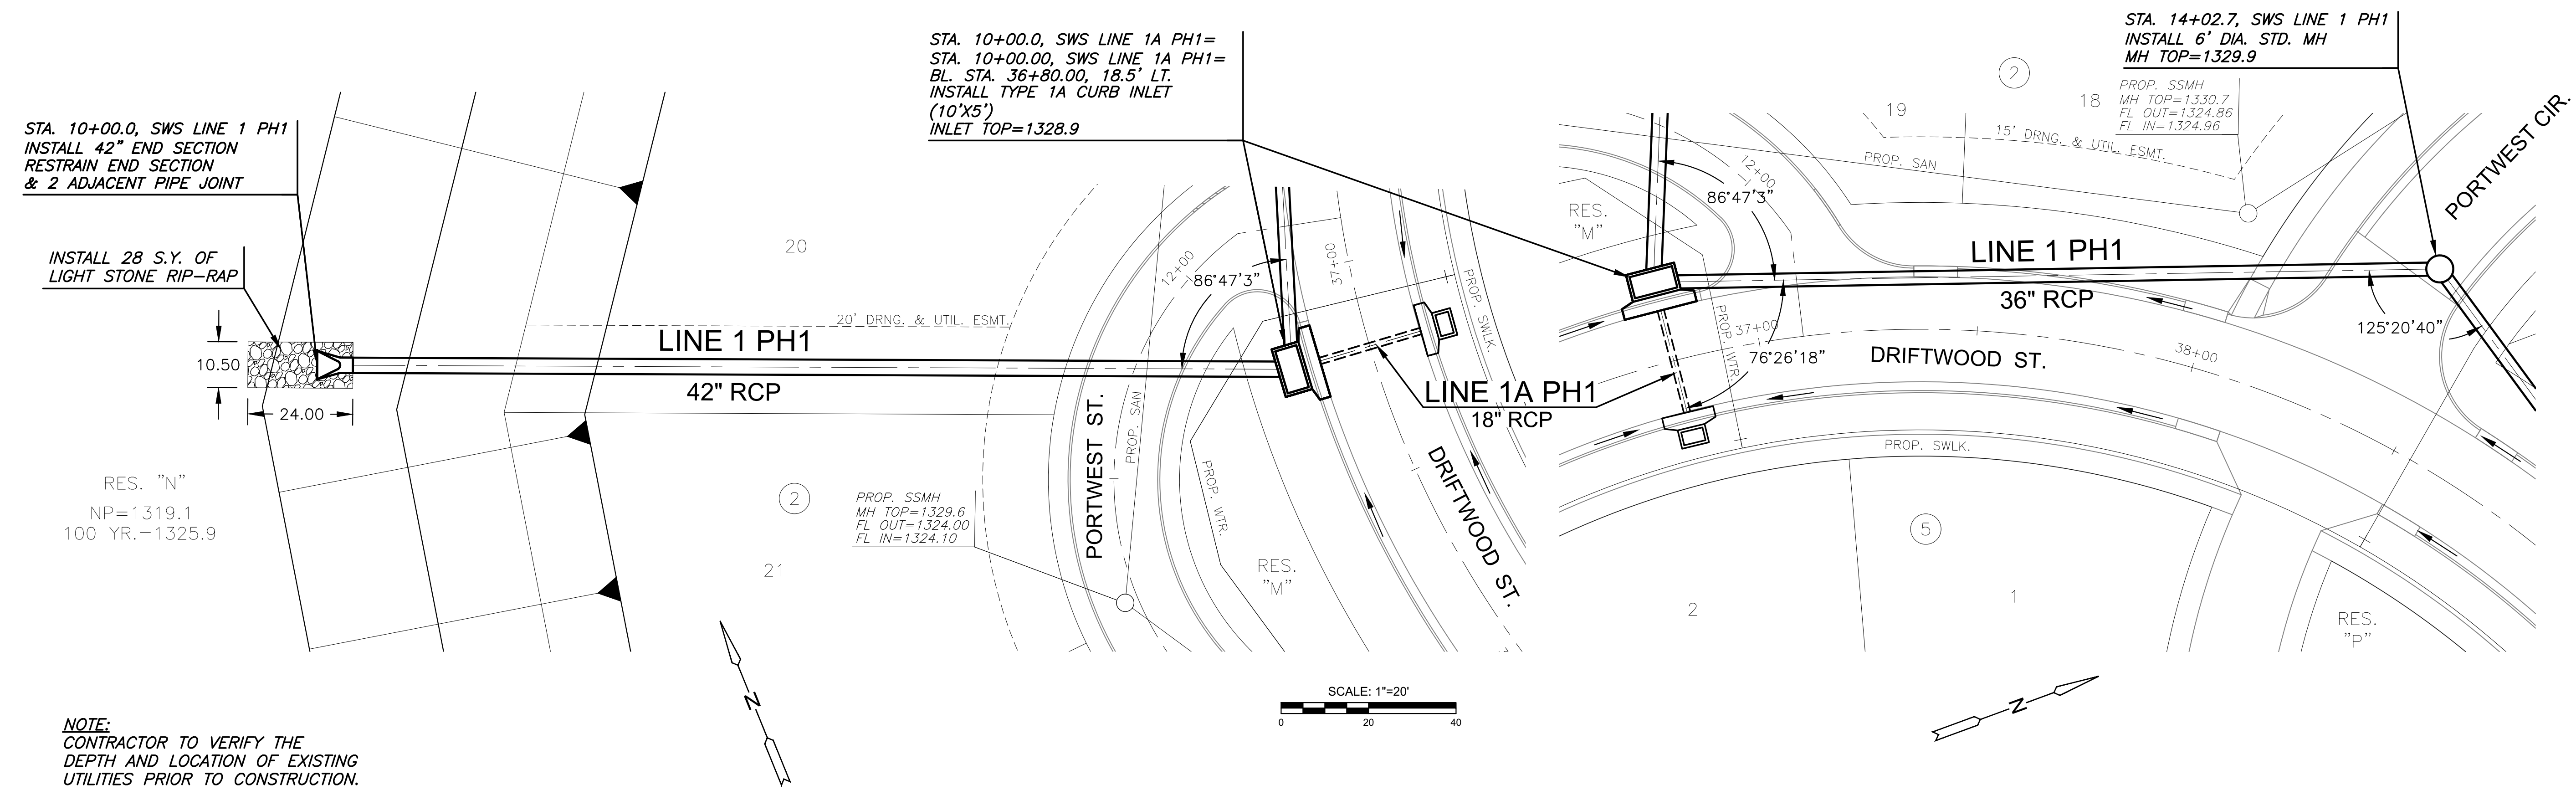

NOTE:
CONTRACTOR TO VERIFY THE DEPTH AND LOCATION OF EXISTING UTILITIES PRIOR TO CONSTRUCTION.

PLAN SWS LINE 1 PH1
PROFILE SWS LINE 1 PH1

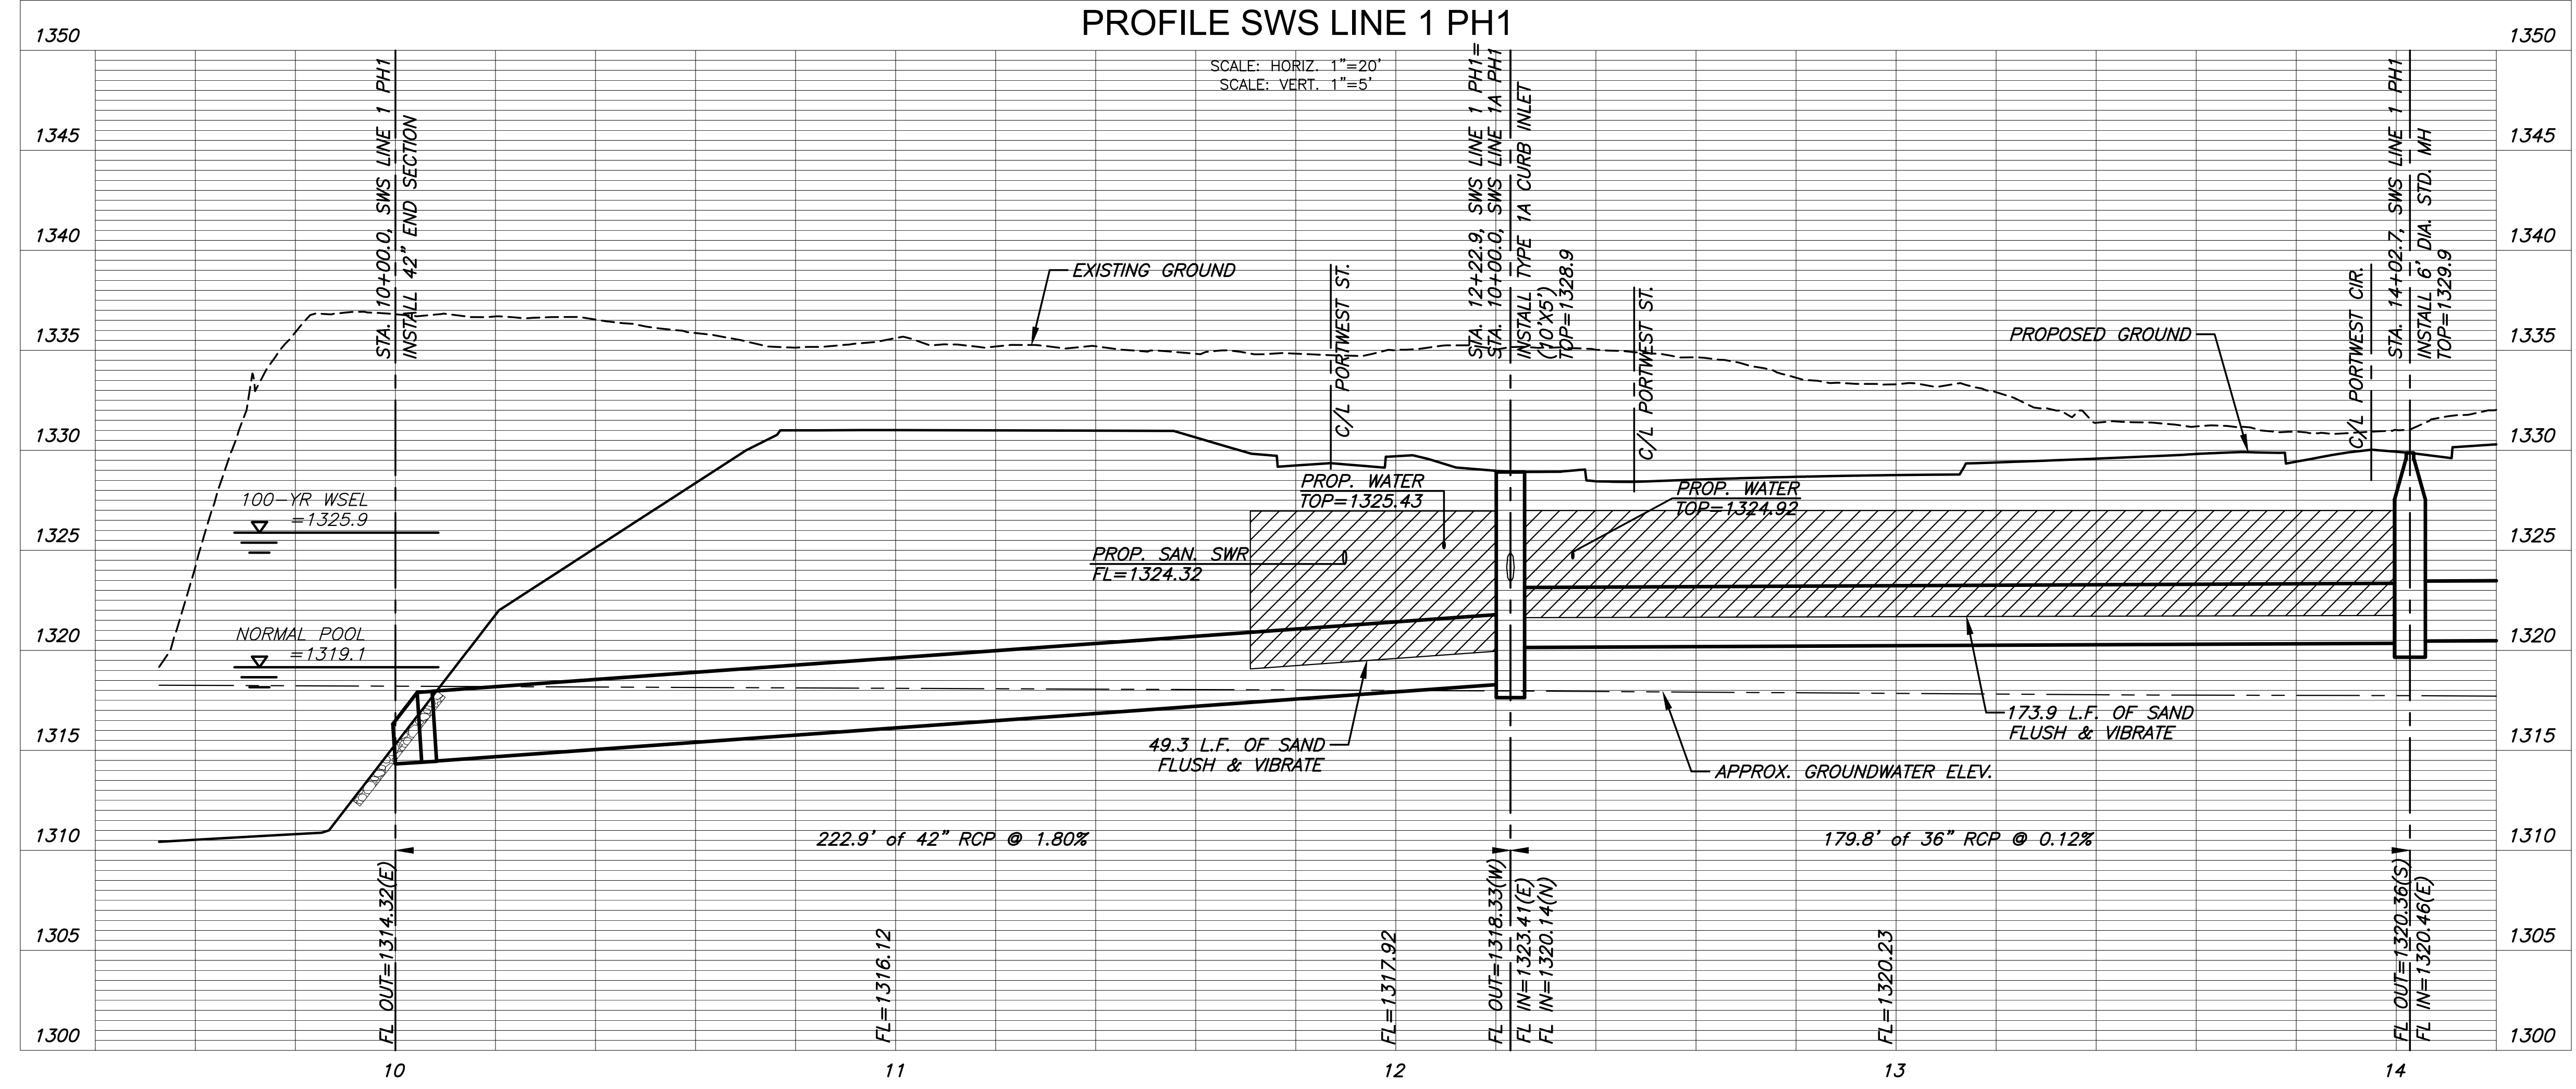

PAVING & INCIDENTAL DRAINAGE PLANS FOR
COURTYARDS AT THE MOORINGS
PHASE 1 PART A

©2023 MKEC Engineering All Rights Reserved
www.mkec.com
These drawings and their contents, including, but not limited to, all concepts, designs, & ideas are the exclusive property of MKEC Engineering (MKEC), and may not be used or reproduced in any way without the express consent of MKEC.

SWS LINE 1

PROJECT NO.	472-2022-085820A
DATE	JAN. 2023
SCALE	1" = 20'
DESIGNED	DFL
DRAWN	JWC
CHECKED	SPE

NO.	REVISION	DATE