



PLOTTED: Monday, February 06, 2023 @ 08:44AM

J:\PROJECTS\2017\1701010370_VERANDA_ADD_17270_CAD\SHS\505_CIVIL\PAV\17270-05-5600.DWG

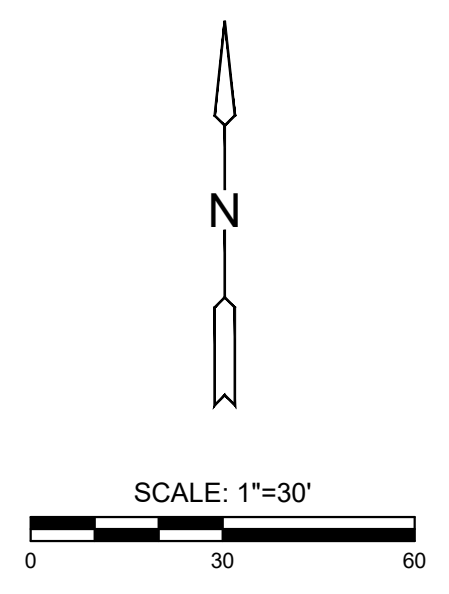

- LEGEND**
- CHANNELIZING DEVICE
 - ▨ WORK AREA
 - TRAFFIC FLOW
 - ▤ TYPE III BARRICADE

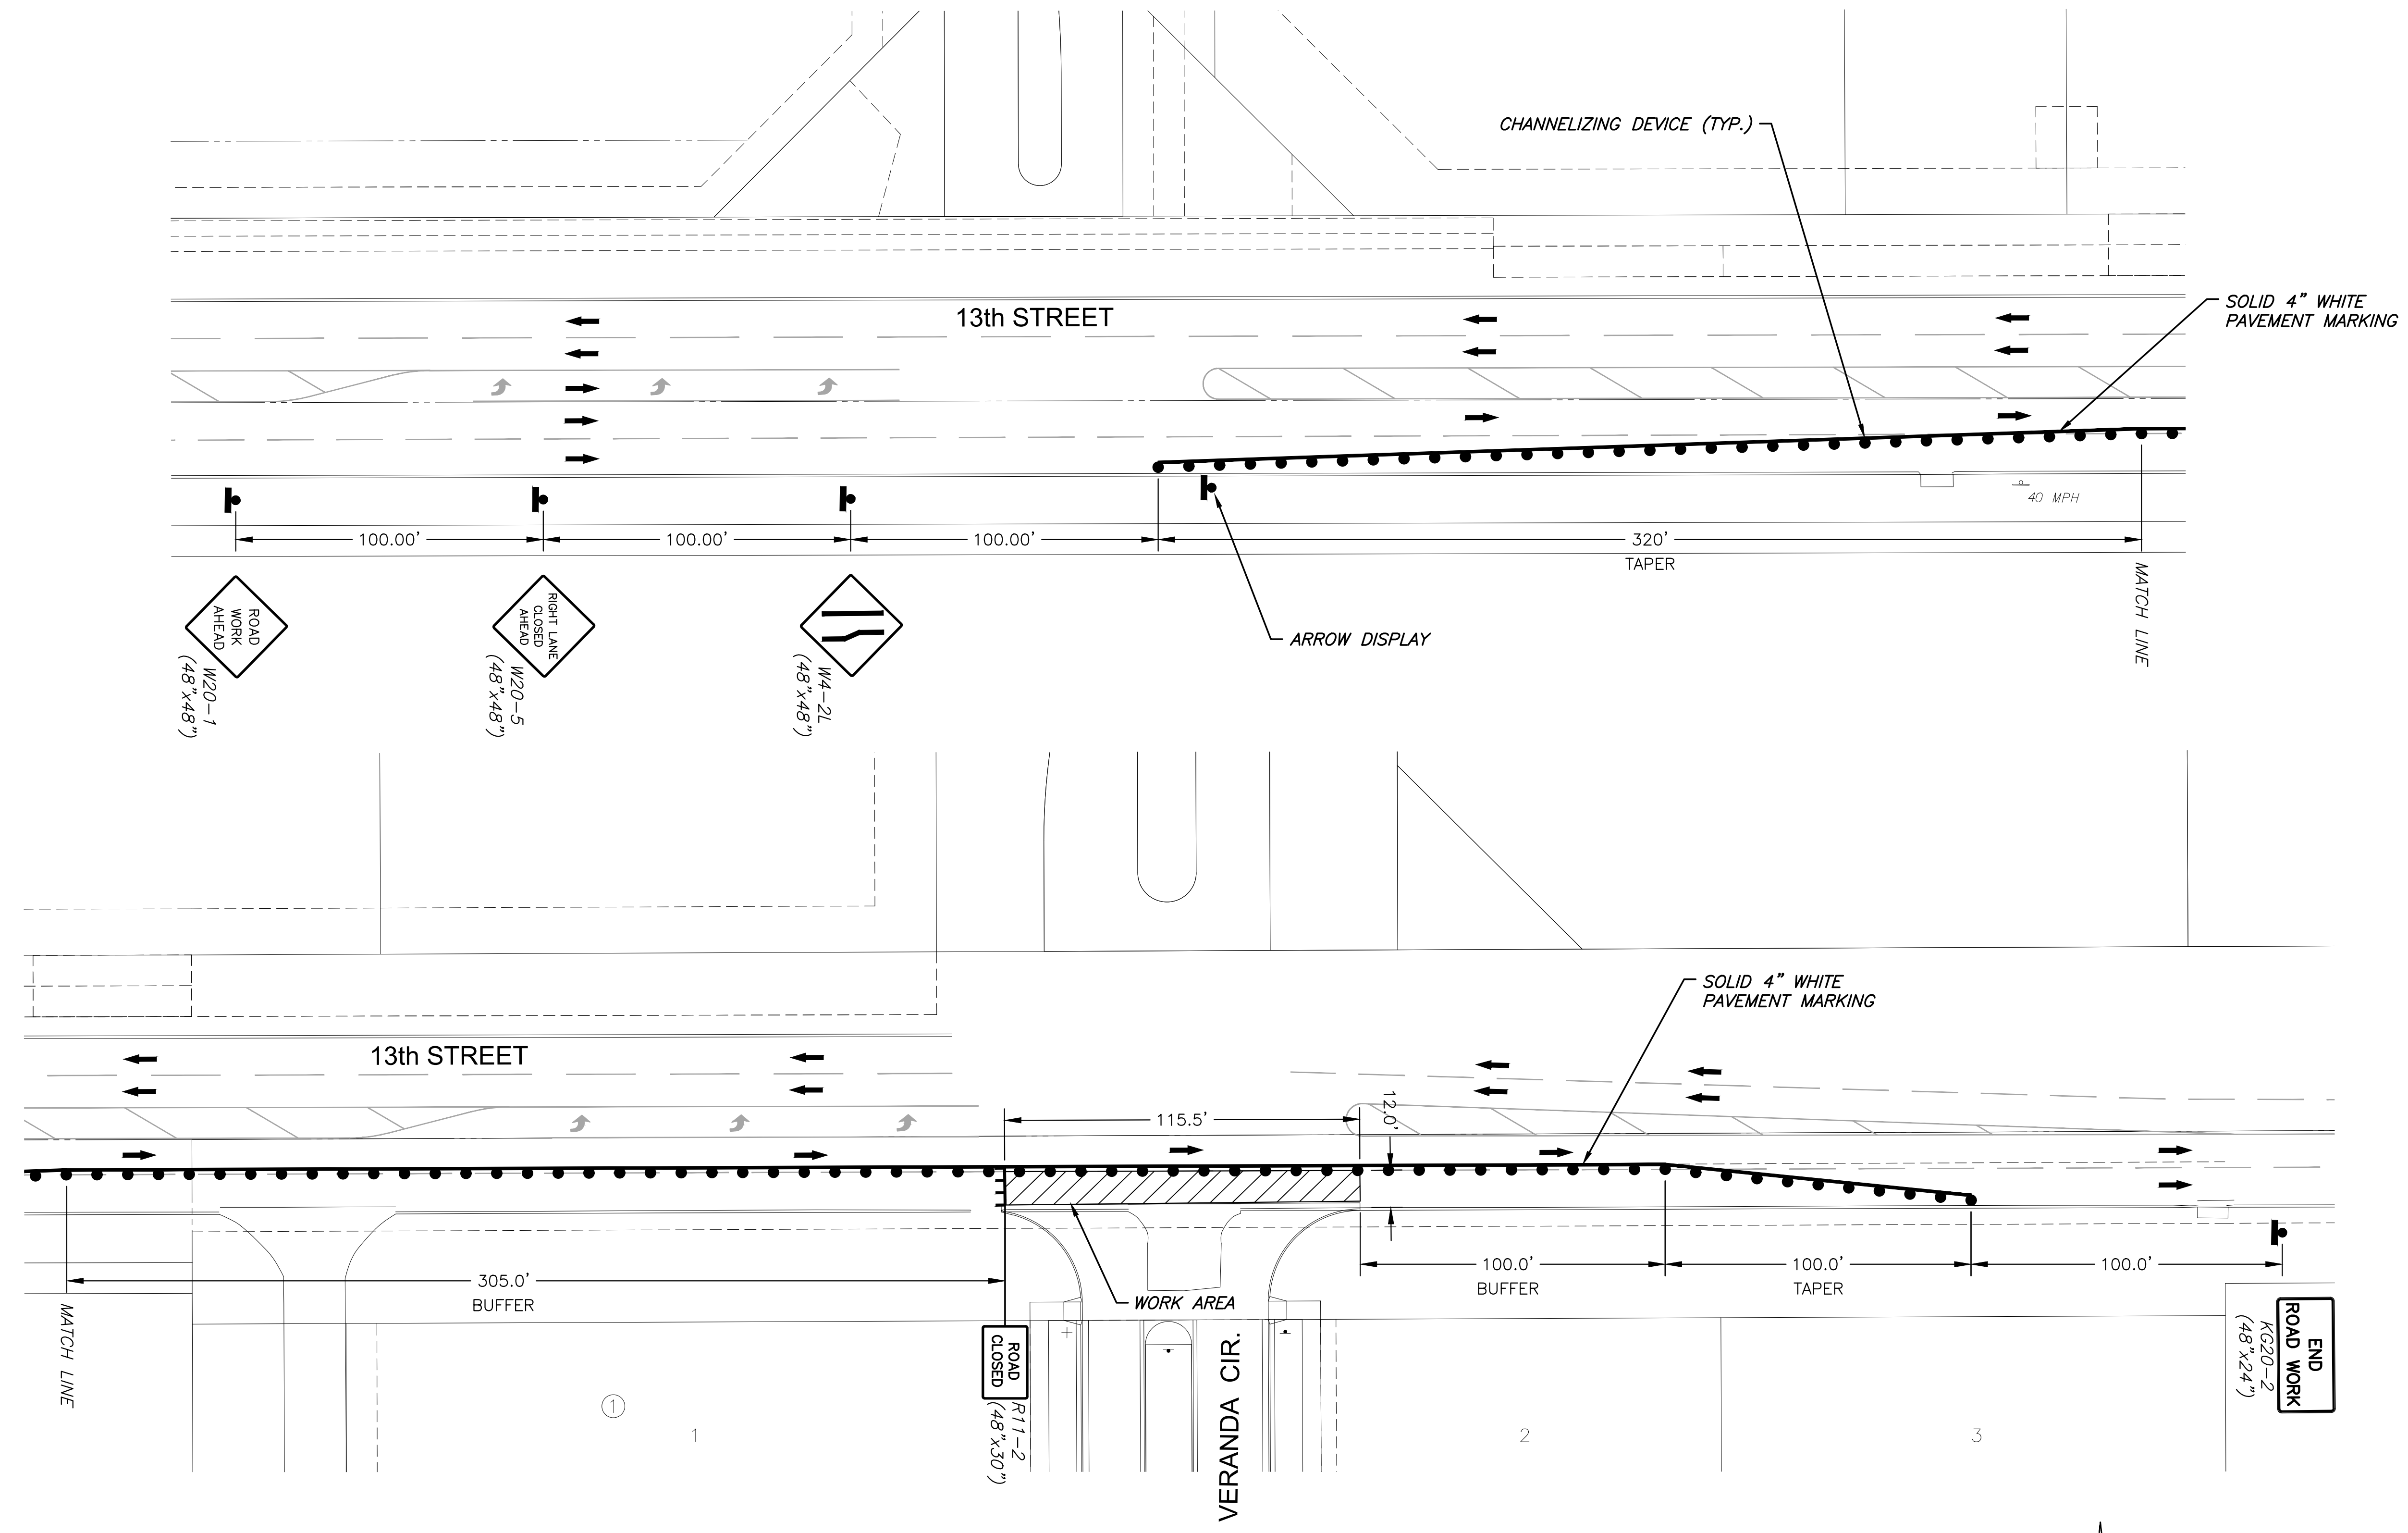

PAVING & INCIDENTAL DRAINAGE PLANS FOR PHASE 1
VERANDA SECOND ADDITION
 PHASE 1

©2023 MKEC Engineering All Rights Reserved www.mkec.com
 These drawings and their contents, including, but not limited to, all concepts, designs, & ideas are the exclusive property of MKEC Engineering (MKEC), and may not be used or reproduced in any way without the express consent of MKEC.

TRAFFIC CONTROL PLAN

PROJECT NO.	472-2022-085763	
DATE	FEB 2023	
SCALE	1" = 30'	
DESIGNED	DRAWN	CHECKED
DFL	JRB	SPE

NO.	REVISION	DATE