

4/20/23 3:34:18 PM

\\glmv\6642_glmv_mkt\Projects\01088R21003\04_Production\Phase9.dwg, 04/20/2023 08:02:03, A, Shaver, Additions, Phase 9.rvt




PHASE 9 STADIUM PRESS BOX AND FIELD NETTING IMPROVEMENTS
SCHEELS STRYKER SPORTS
WICHITA, KANSAS




©2023 MKEC Engineering All Rights Reserved. www.mkec.com These drawings and their contents, including, but not limited to, all concepts, designs, & data are the exclusive property of MKEC Engineering (MKEC), and may not be used or reproduced in any way without the express consent of MKEC.

CODE SITE PLAN

PROJECT NO.	01088R21003	
DATE	04-07-2023	
SCALE	AS NOTED	
DESIGNED	DRAWN	CHECKED
MH	SS	MH
0	ISSUED FOR CONSTRUCTION	04-07-23
NO.	REVISION	DATE
SHEET NO.		
SG0.3		

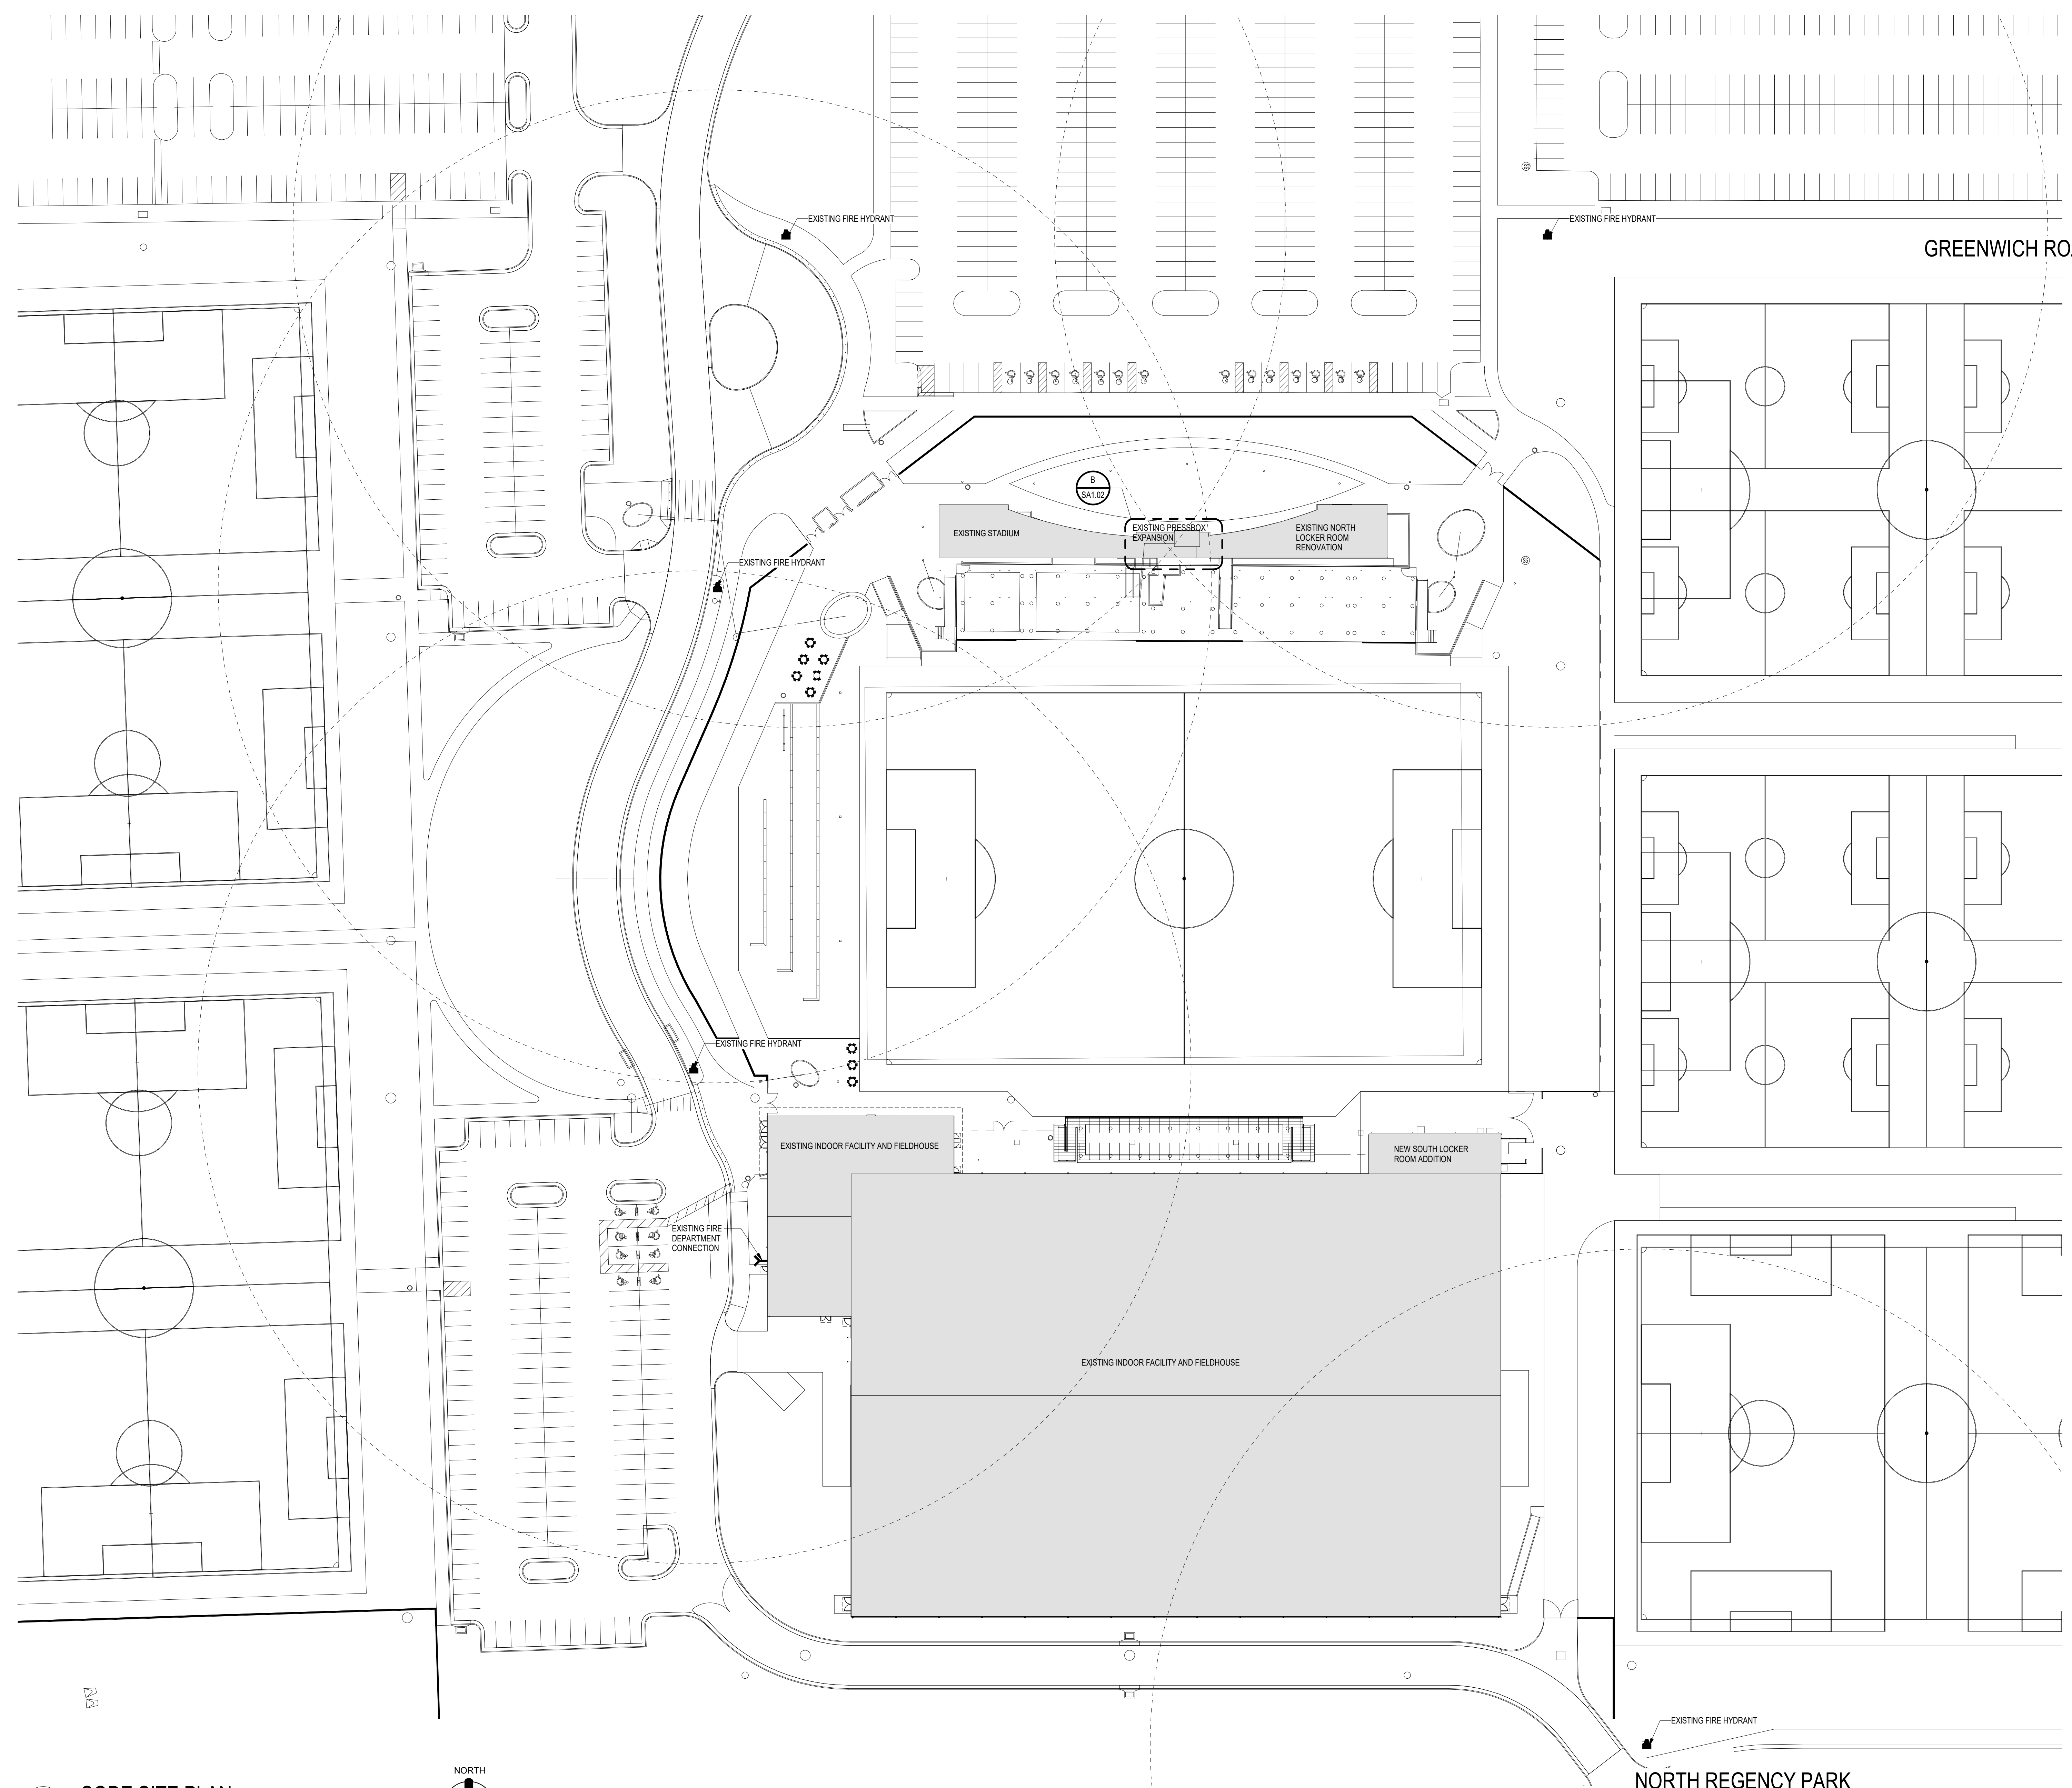

A CODE SITE PLAN
1" = 40'-0"

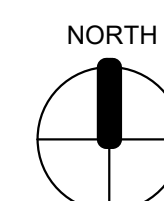

CODE SITE PLAN GRAPHIC LEGEND

	FACP	FIRE ALARM CONTROL PANEL (REF. PLANS)
	FAAP	FIRE ALARM ANNUNCIATOR PANEL (REF. PLANS)
	FDC	FIRE DEPARTMENT CONNECTION (FDC)
	FHY	PUBLIC FIRE HYDRANT (ALL EXISTING ON COMPLEX)

