



PLOTTED: Friday, July 07, 2023 @ 01:15PM

J:\PROJECTS\2022\2201010526_1_TIER1_ESTANCIA COMMERCIAL SECOND\00 220526 CAD\SH1505 CIVIL\SWS\PH1122526-05-4200 PH1.DWG

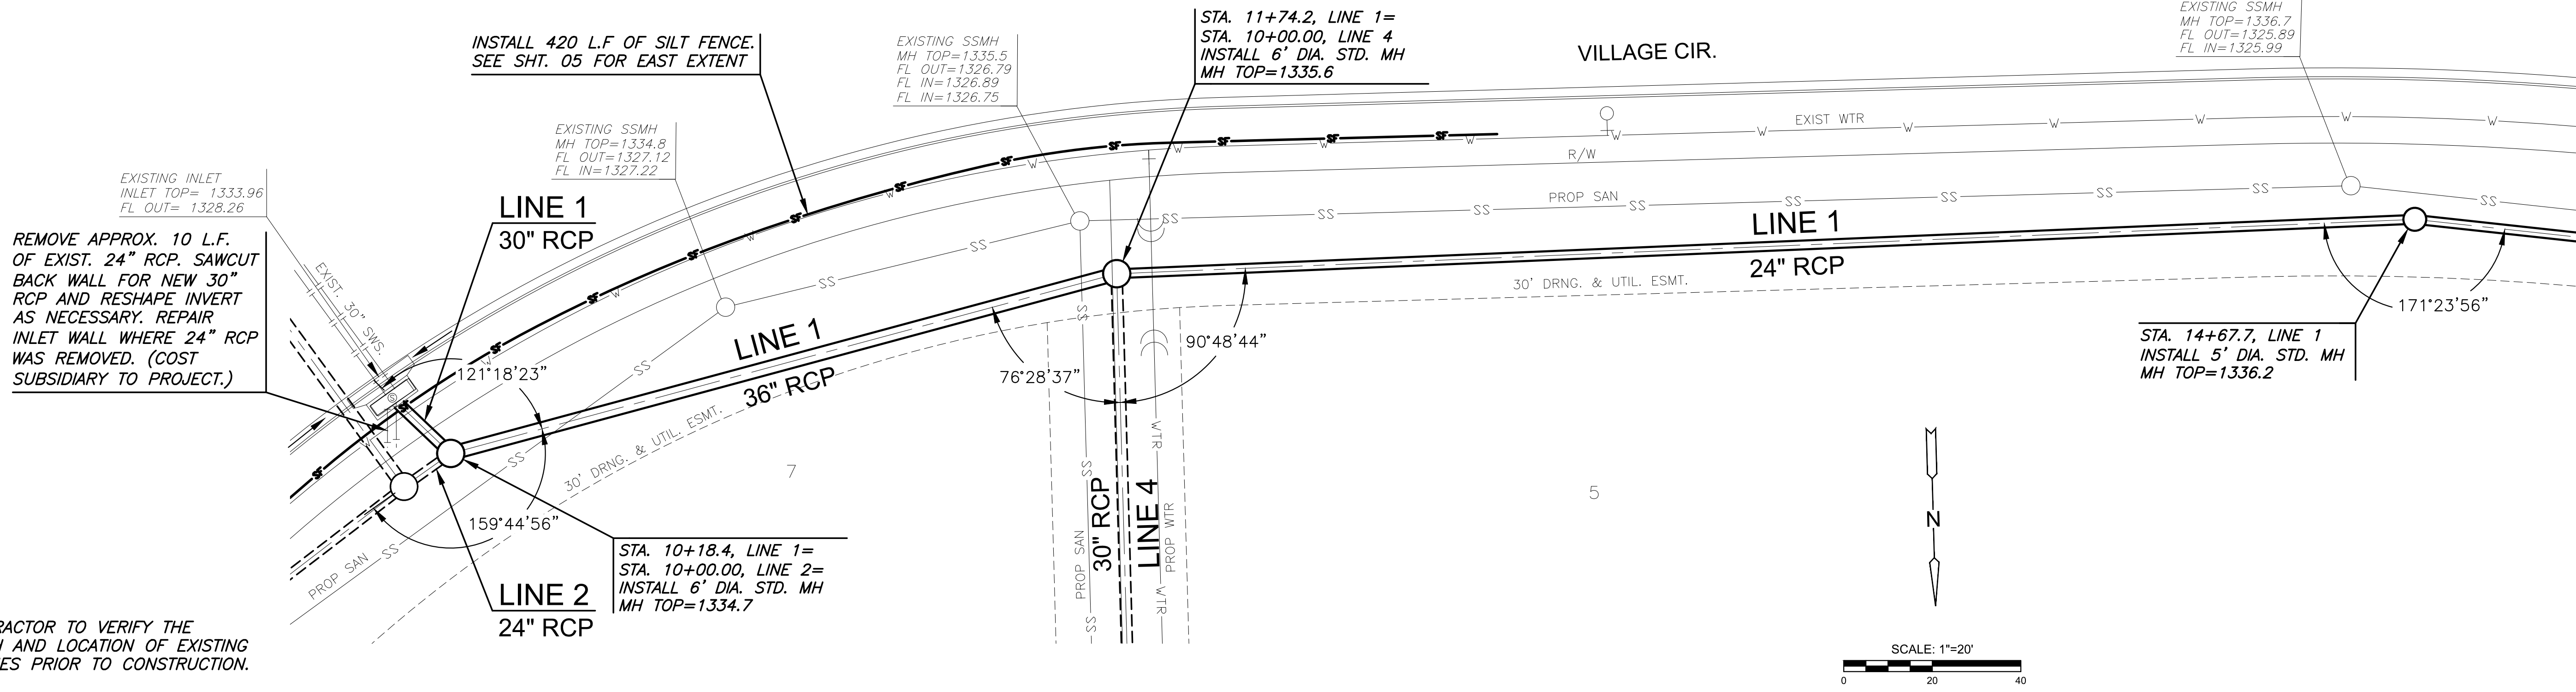

NOTE:
CONTRACTOR TO VERIFY THE DEPTH AND LOCATION OF EXISTING UTILITIES PRIOR TO CONSTRUCTION.

PLAN SWS LINE 1
PROFILE SWS LINE 1

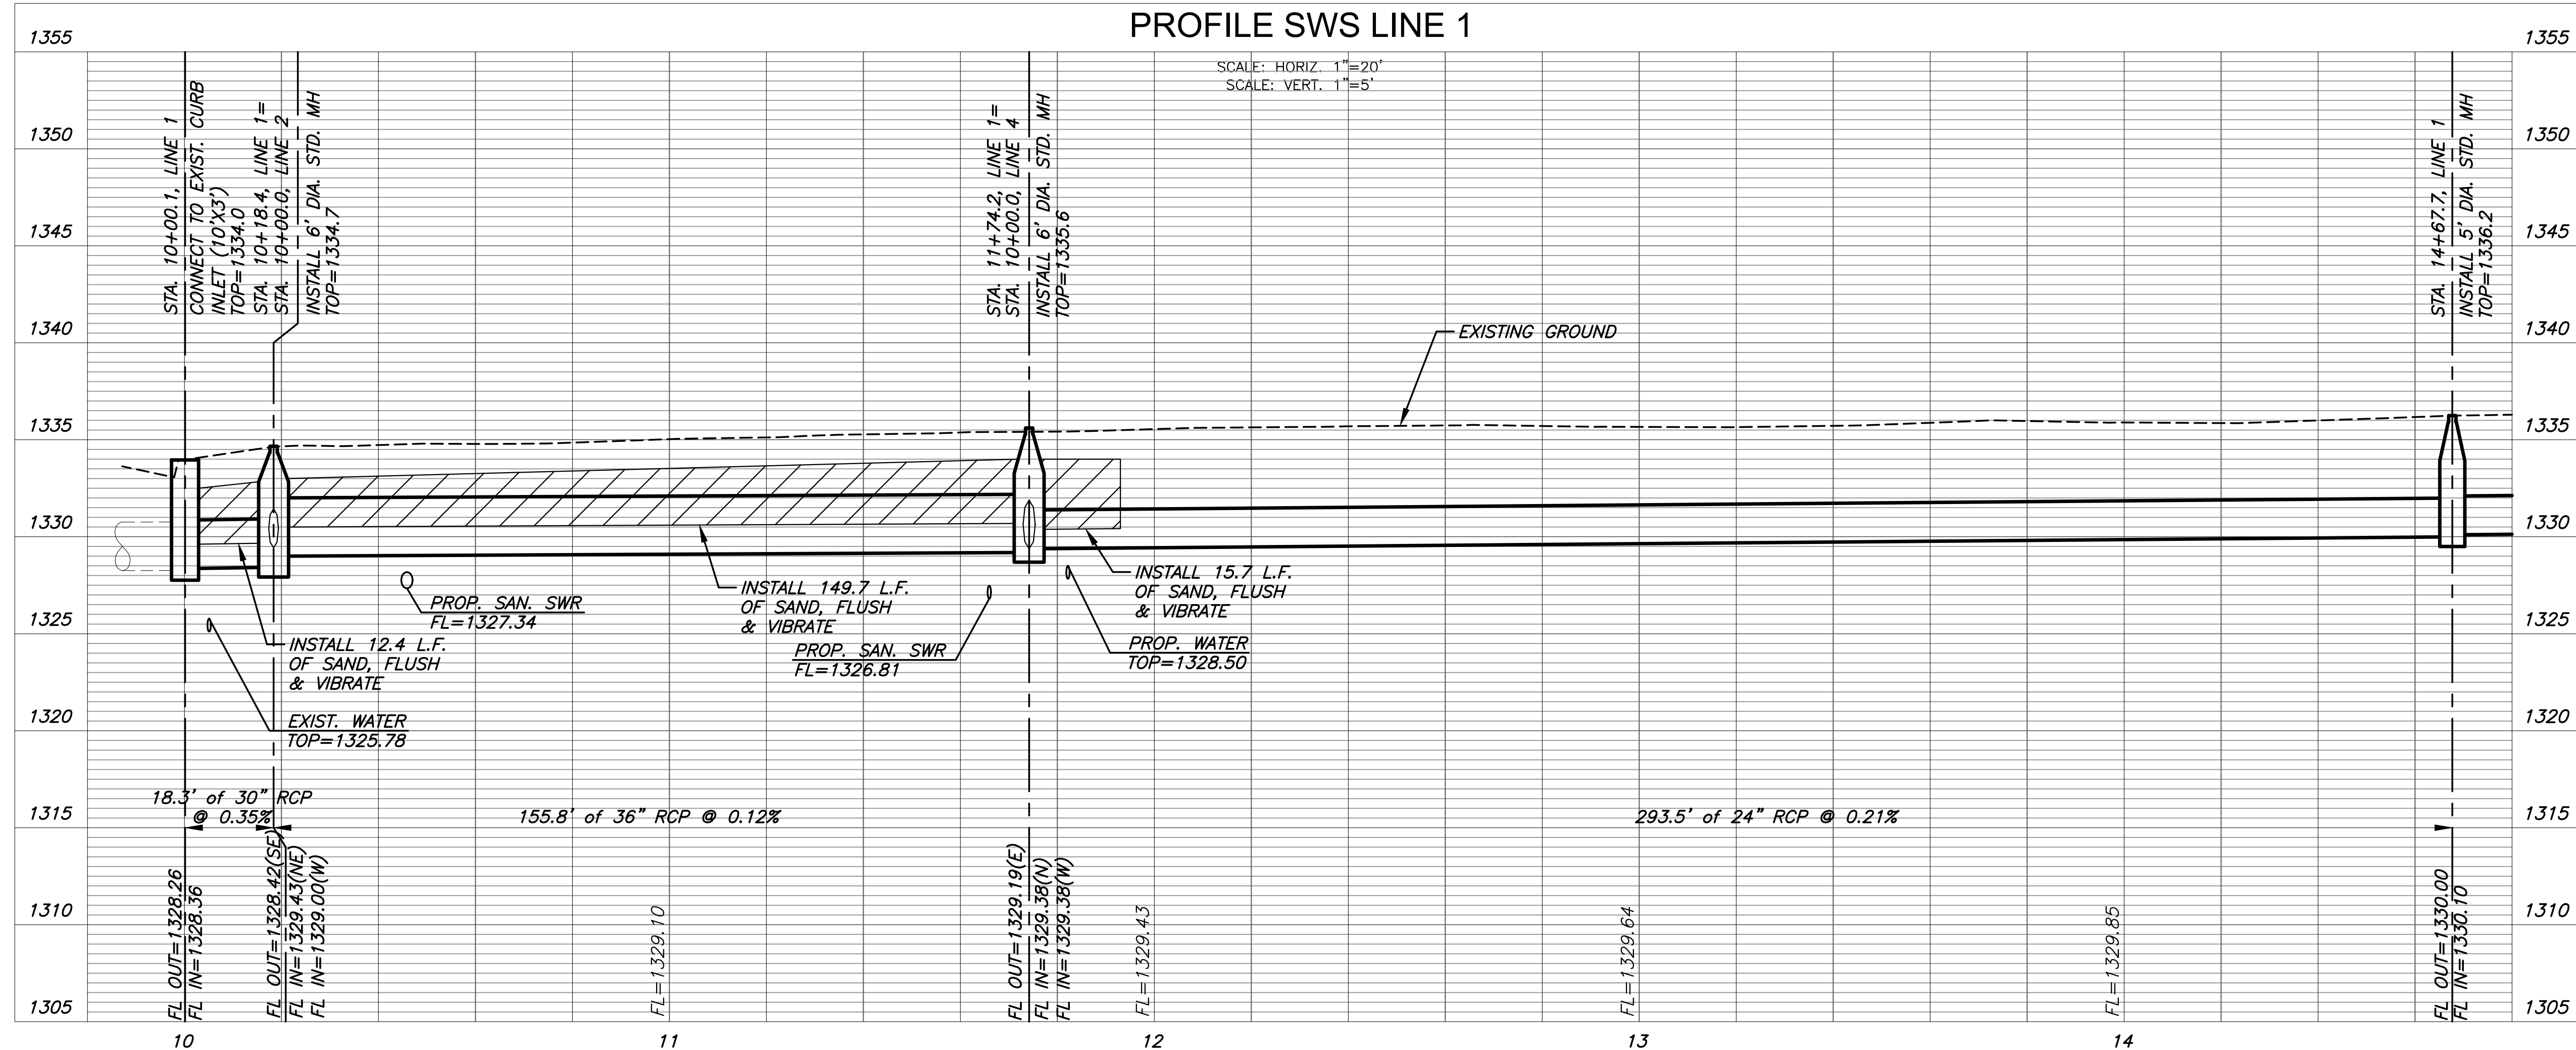

STORMWATER DRAINAGE PLANS FOR
ESTANCIA COMMERCIAL 2ND ADD.
PHASE 1

©2023
MKEC Engineering
All Rights Reserved
www.mkec.com
These drawings and their contents, including, but not limited to, all concepts, designs, & ideas are the exclusive property of MKEC Engineering (MKEC), and may not be used or reproduced in any way without the express consent of MKEC.

LINE 1		
PROJECT NO.	458-2023-085544	
DATE	JULY 2023	
SCALE	1" = 20'	
DESIGNED	DRAWN	
DFL	JWC	
CHECKED	SPE	
NO.	REVISION	DATE
SHEET NO. 05 OF 15		