



PLOTTED: Friday, July 07, 2023 @ 01:17PM

J:\PROJECTS\2022\201010526\_1\_TIER1\_ESTANCIA COMMERCIAL SECOND\00 220526 CAD\SH105 CIVIL\SWS\PH122526-05-4203 PH1.DWG

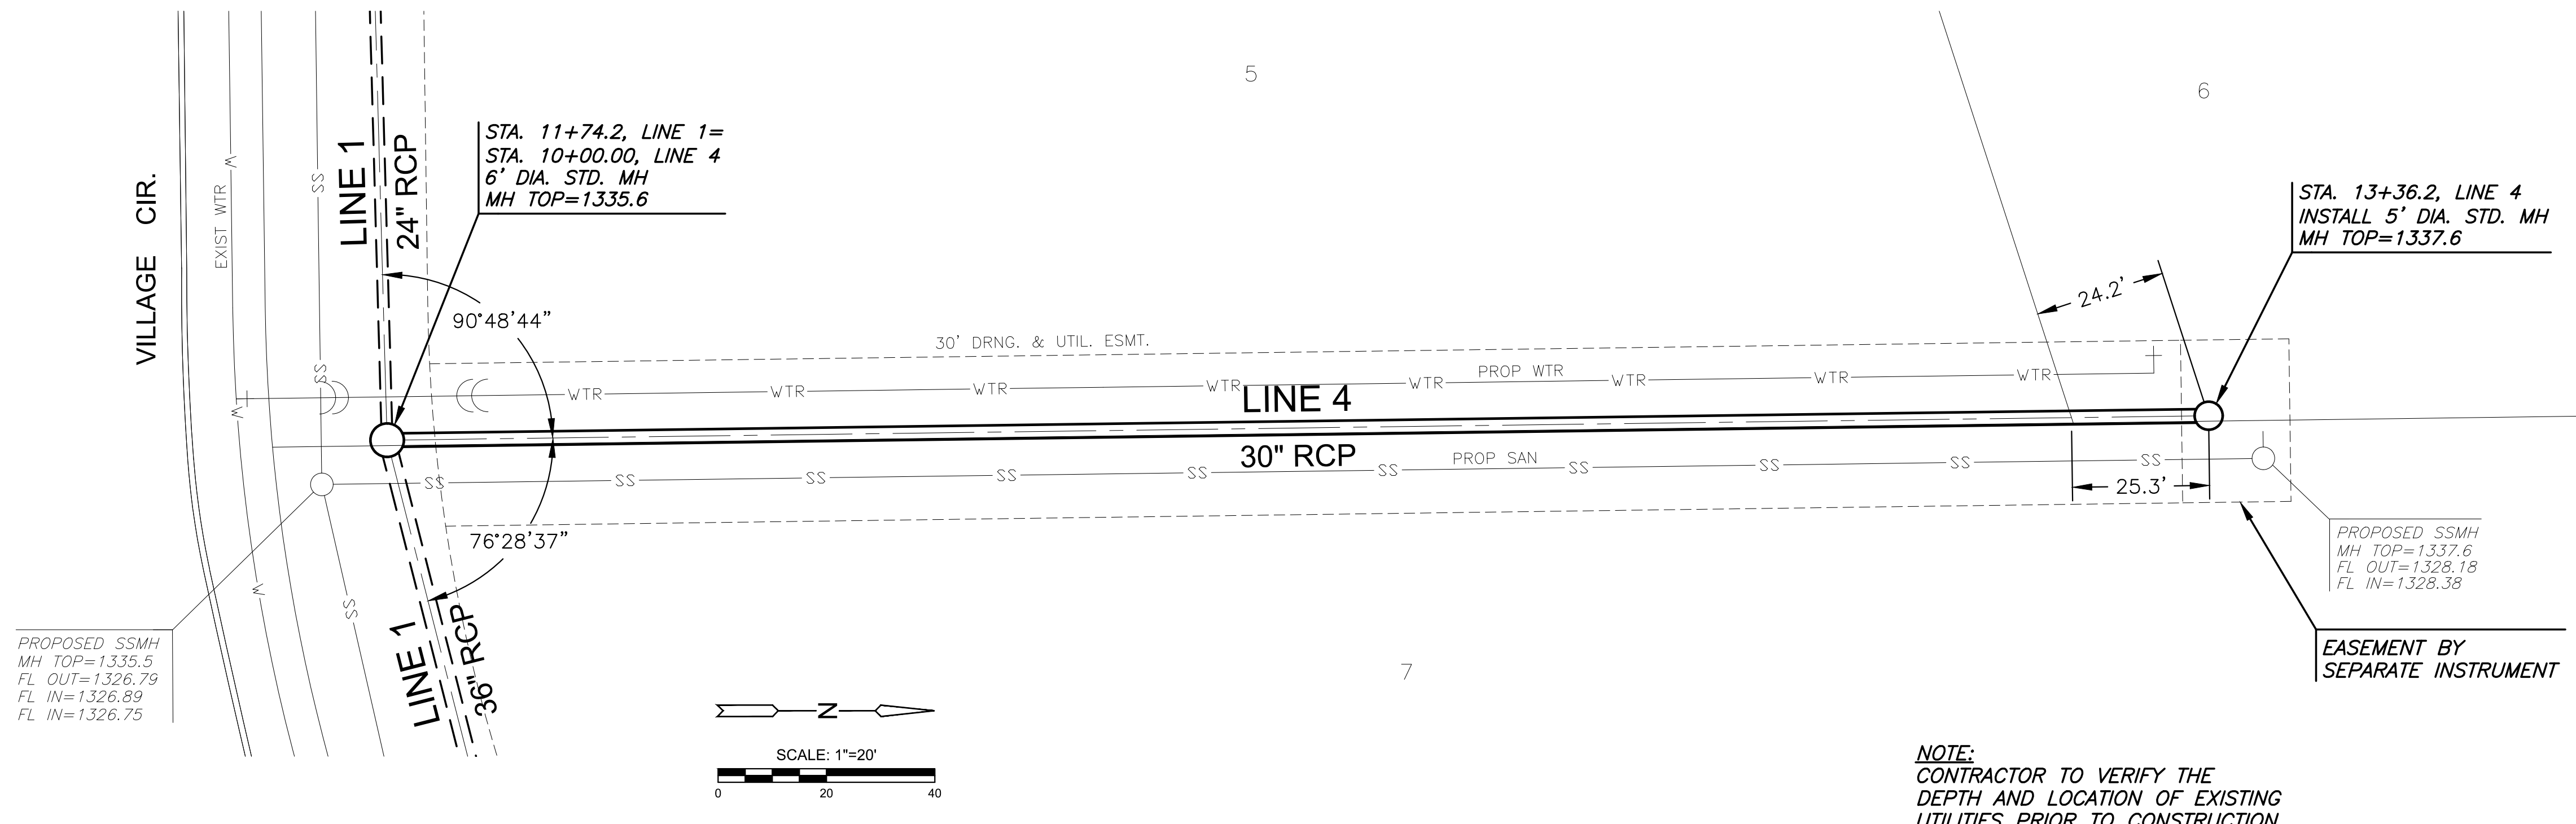

PLAN SWS LINE 4  
PROFILE SWS LINE 4

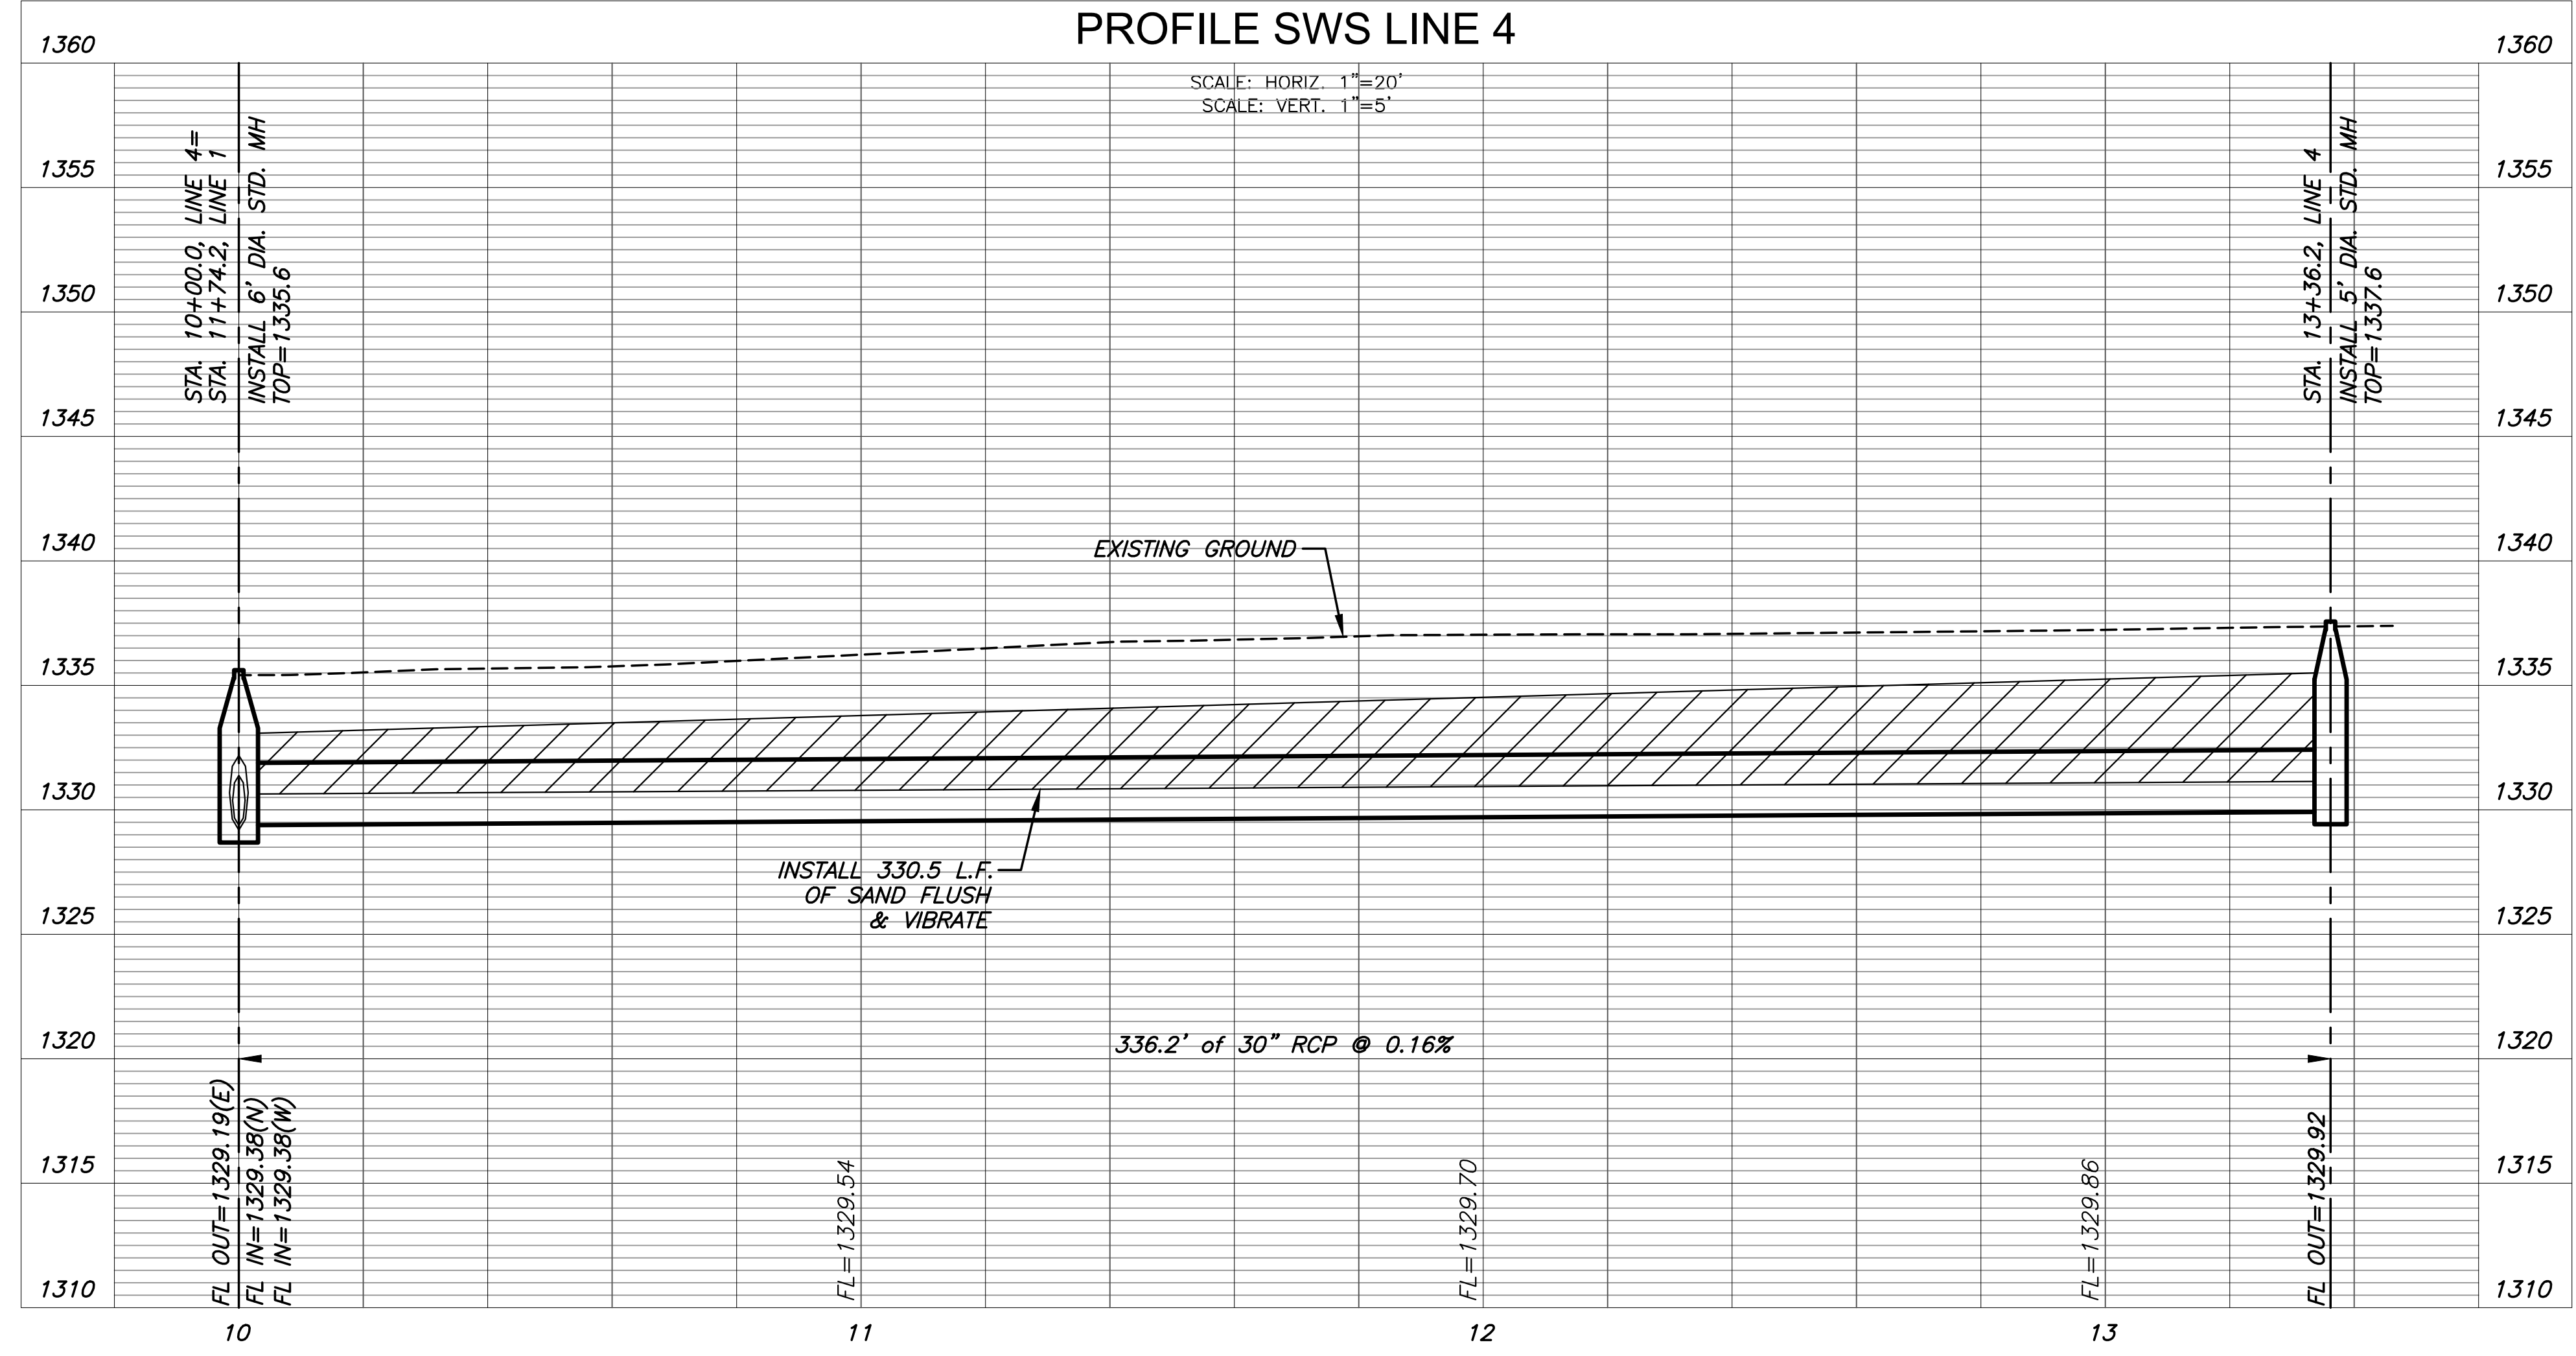

**NOTE:**  
CONTRACTOR TO VERIFY THE DEPTH AND LOCATION OF EXISTING UTILITIES PRIOR TO CONSTRUCTION.



STORMWATER DRAINAGE PLANS FOR  
**ESTANCIA COMMERCIAL 2ND ADD.**  
PHASE 1

©2023 MKEC Engineering All Rights Reserved  
www.mkec.com  
These drawings and their contents, including, but not limited to, all concepts, designs, & ideas are the exclusive property of MKEC Engineering (MKEC), and may not be used or reproduced in any way without the express consent of MKEC.

LINE 4		
PROJECT NO.	458-2023-085544	
DATE	JULY 2023	
SCALE	1" = 20'	
DESIGNED	DRAWN	CHECKED
DFL	JWC	SPE
NO.	REVISION	DATE
SHEET NO. 08 OF 15		