
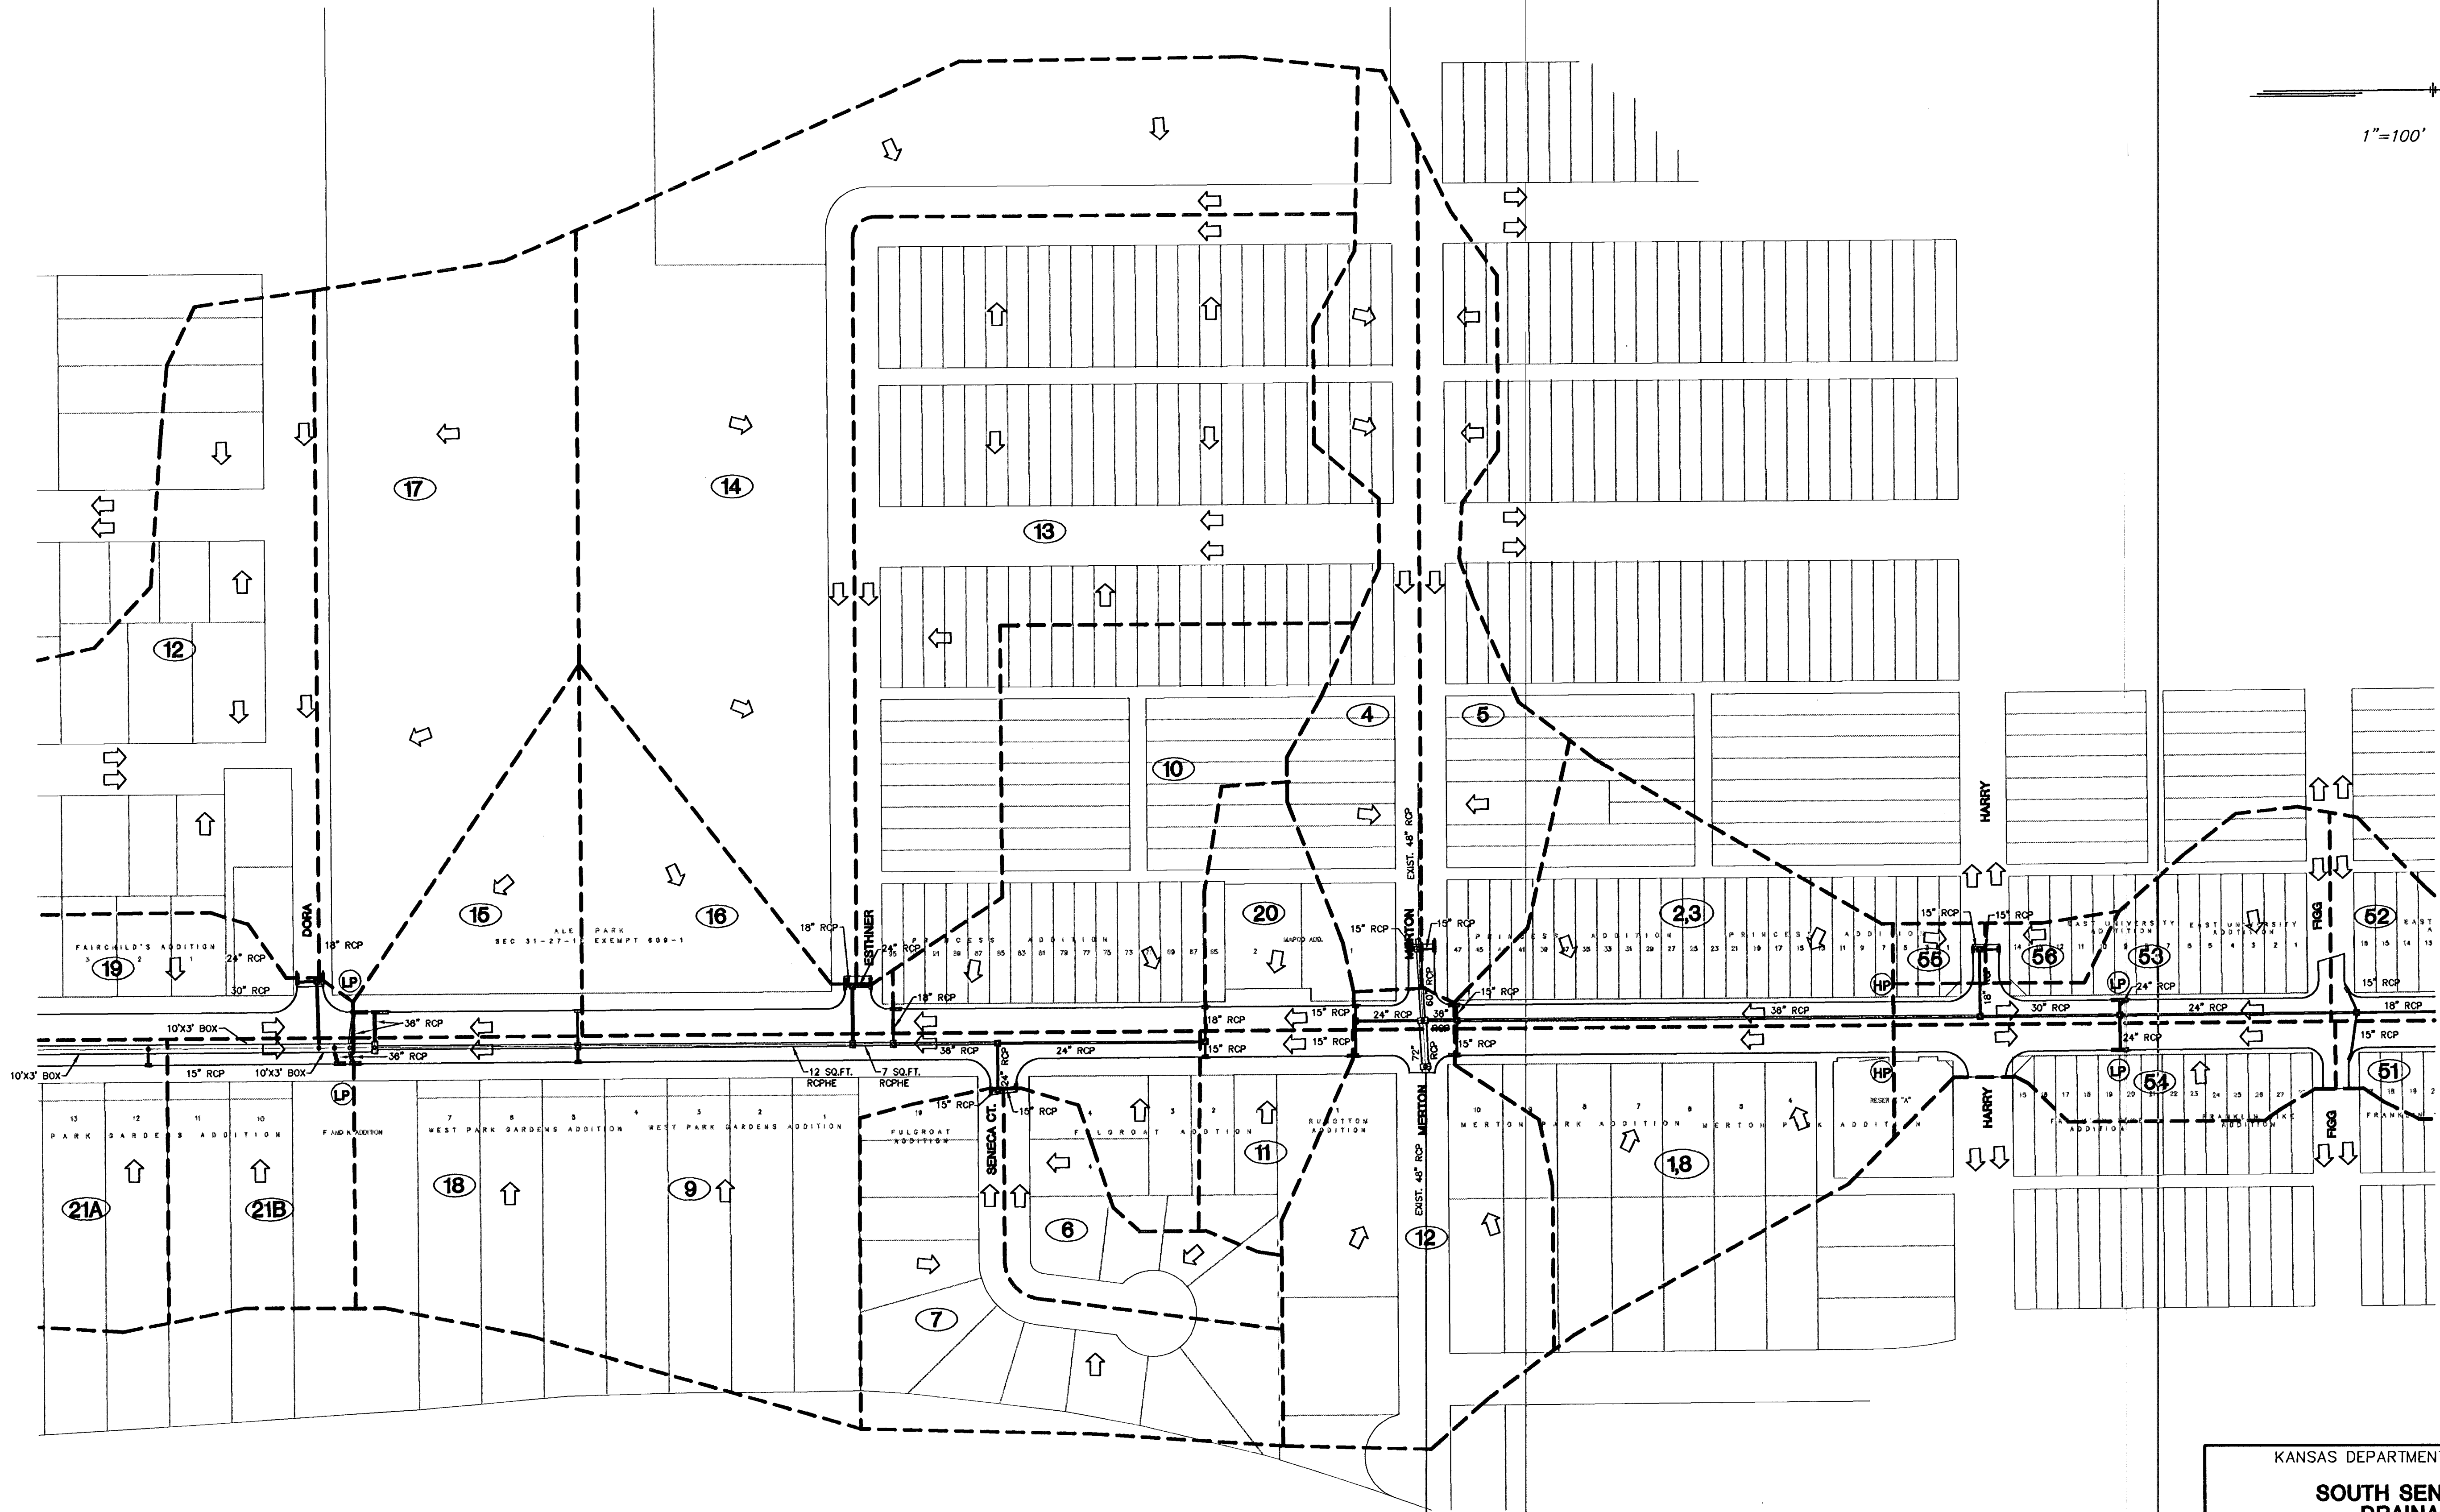


FHWA REG NO.	STATE	PROJECT NO.	YEAR	SHEET NO.	SHEETS
7	KANSAS	87N 0064-01	1997	107	130

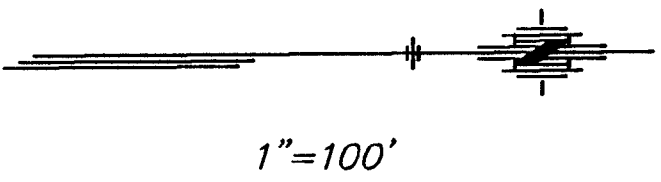

KANSAS DEPARTMENT OF TRANSPORTATION

**SOUTH SENECA STREET
DRAINAGE PLAN**

PROJECT NO. 87N 0064-01 SEDGWICK CO.

MID-KANSAS ENGINEERING CONSULTANTS, INC.
WICHITA, KANSAS

DESIGNED BY: GJA,PAF CHECKED BY: GJA

DRAWN BY: PAF DATE: 7/98 SHEET 107 OF 130

H:\CIVIL\SENECA\94005DRAINAGE\94005DR2 F11 May 30 13:51:19 1997

94005DR2