



PLOTTED: Tuesday, September 05, 2023 @ 08:15AM

J:\PROJECTS\2022\12\10\10427_PERFECTION_COURTYARDS_AT_MOORINGS\05_CIVIL\PAV\COLLECTOR\210427_CAD\SHOTS\05_CIVIL\PAV\COLLECTOR\210427-05-2600.DWG

PAVING & INCIDENTAL DRAINAGE PLANS FOR
COURTYARDS AT THE MOORINGS
 COLLECTOR PHASE - PART B

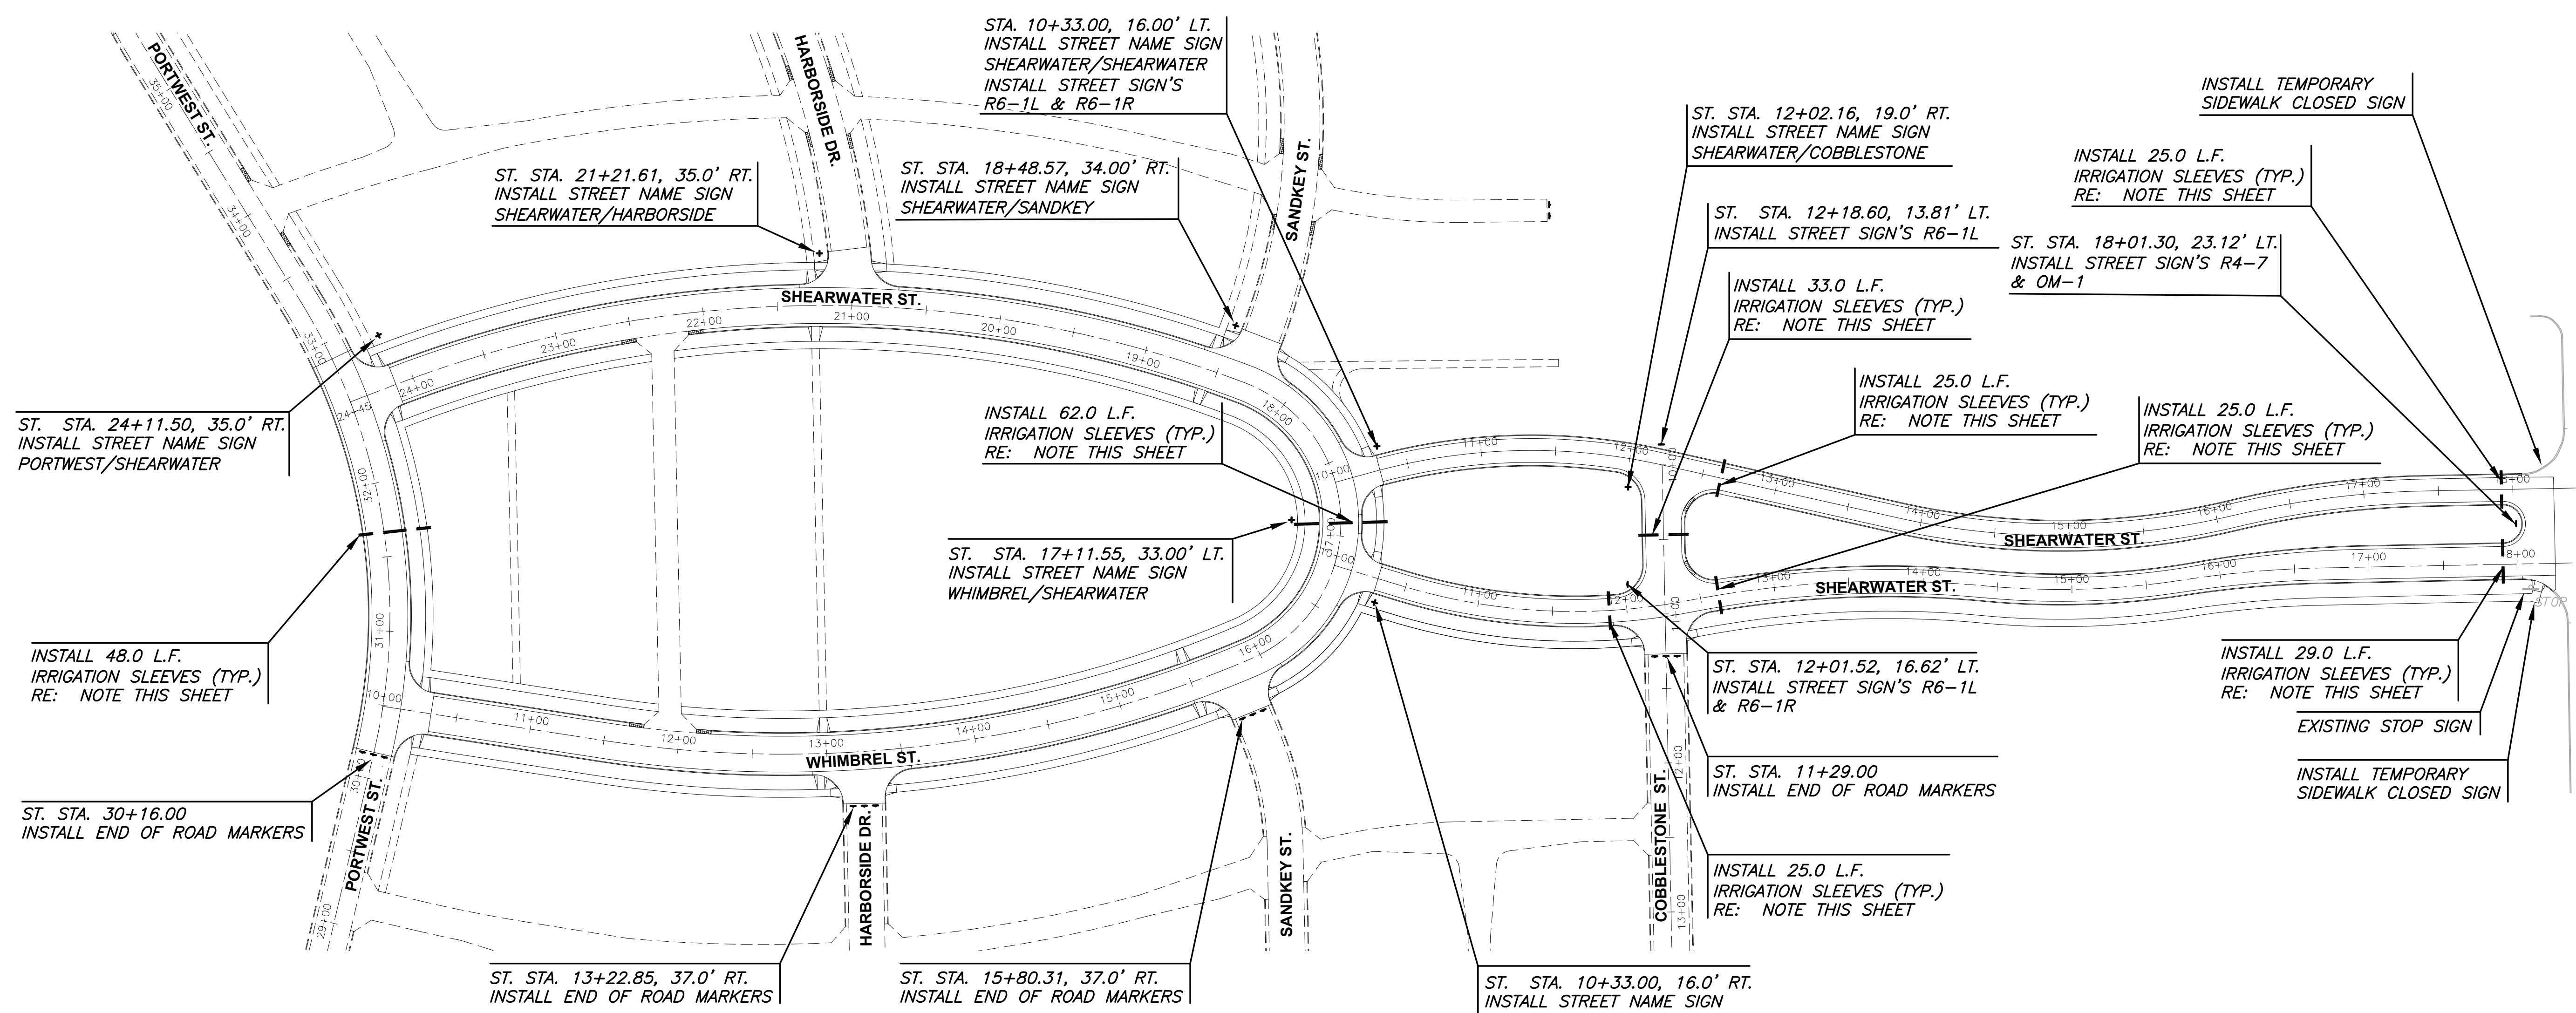

NOTE:
 INSTALL IRRIGATION SLEEVES IN LOCATIONS NOTED ON THE PLANS.
 TWO SLEEVES ARE REQUIRED IN EACH LOCATION: TWO (2) 6" PVC
 CLASS 200 SDR 21 SLEEVES. BOTH SHALL EXTEND 18" BEYOND
 THE BACK OF CURB, BUILDING, OR SIDEWALK AND BE MARKED.
 SLEEVES TO BE BURIED AT A DEPTH OF 2' TO TOP OF SLEEVE,
 MINIMUM. INSTALL TEMPORARY T-POST MARKER AT SLEEVE ENDS.

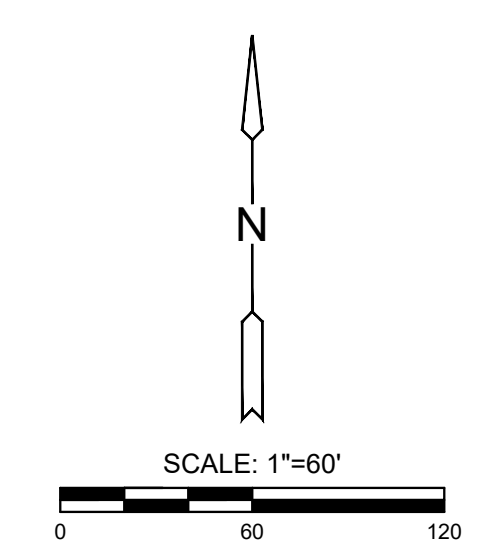

©2023
 MKEC Engineering
 All Rights Reserved
 www.mkec.com
 These drawings and their contents,
 including, but not limited to, all concepts,
 designs, & ideas are the exclusive
 property of MKEC Engineering (MKEC),
 and may not be used or reproduced in any
 way without the express consent of MKEC.

SIGNING & SLEEVING PLAN

PROJECT NO.	472-2022-085819B	
DATE	SEPT. 2023	
SCALE	1" = 60'	
DESIGNED	DRAWN	CHECKED
DFL	JRB	SPE
NO.	REVISION	DATE