

 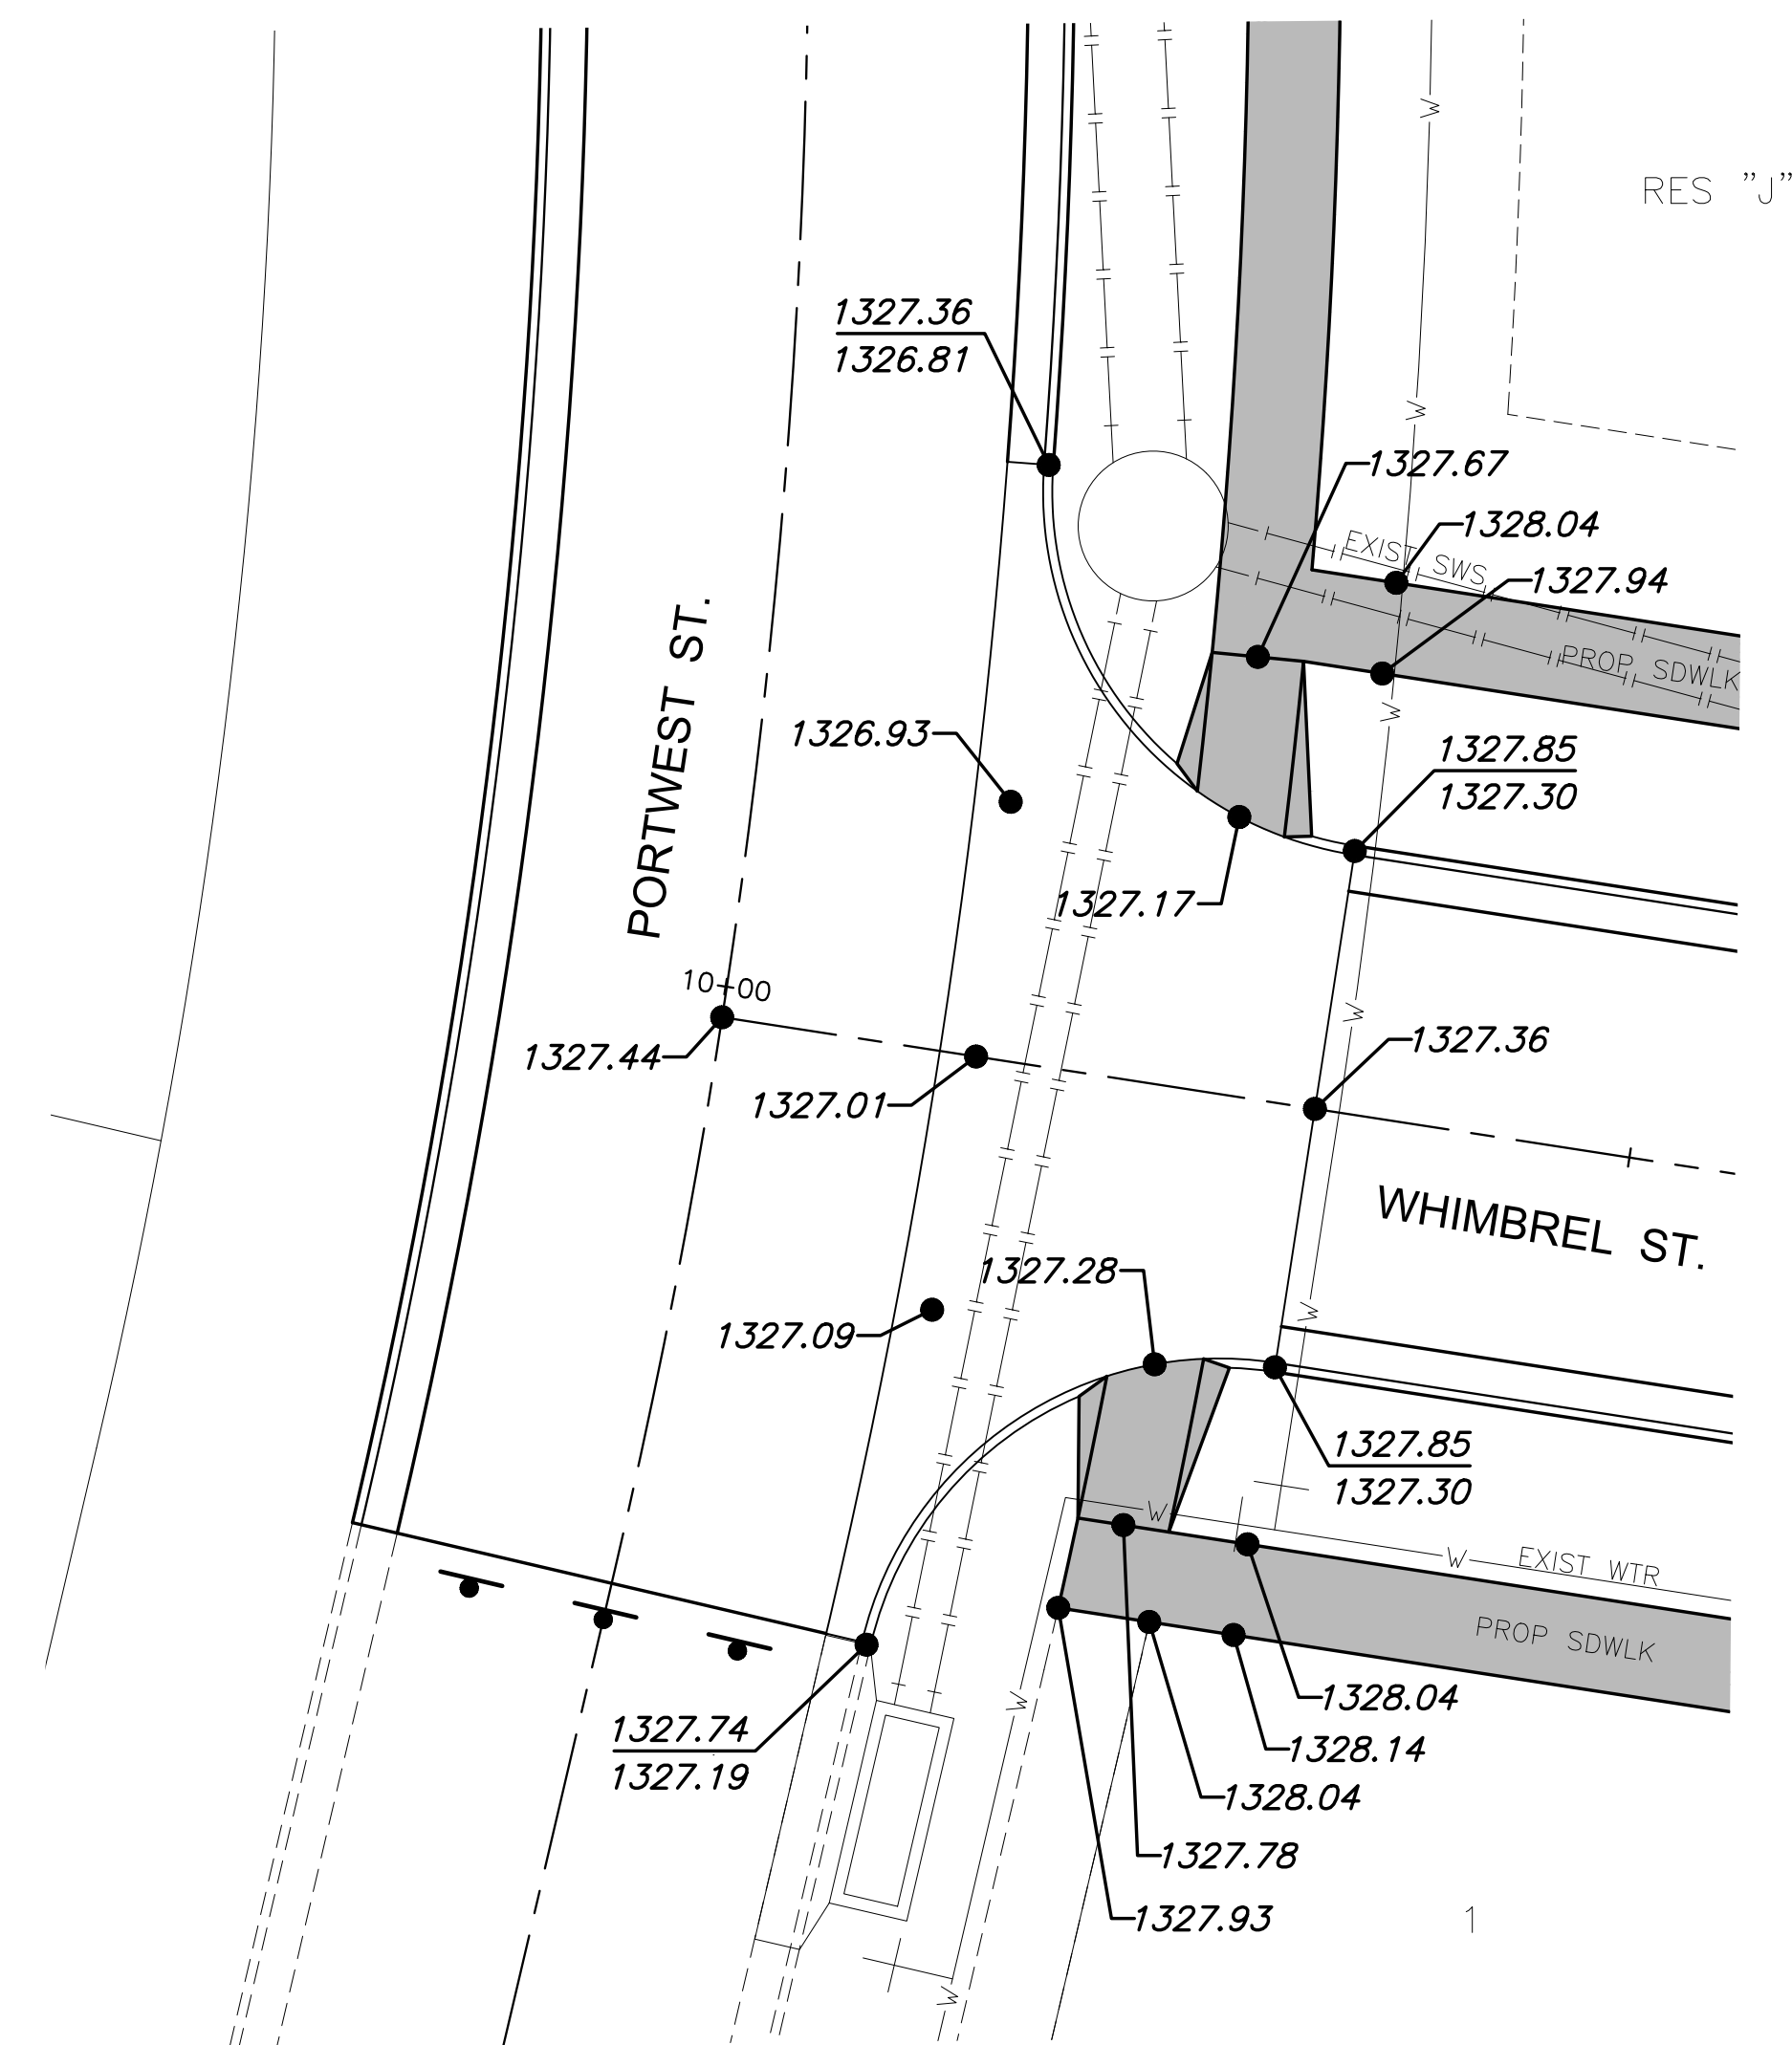


PLOTTED: Tuesday, September 05, 2023 @ 09:21AM

J:\PROJECTS\2023\12\10\10427_PERFECTION_COURTYARDS AT MOORINGS\DWG\PAV\COLLECTOR\210427 CAD\SHOTS\05 CIVIL\PAV\COLLECTOR\210427-05-2023.DWG

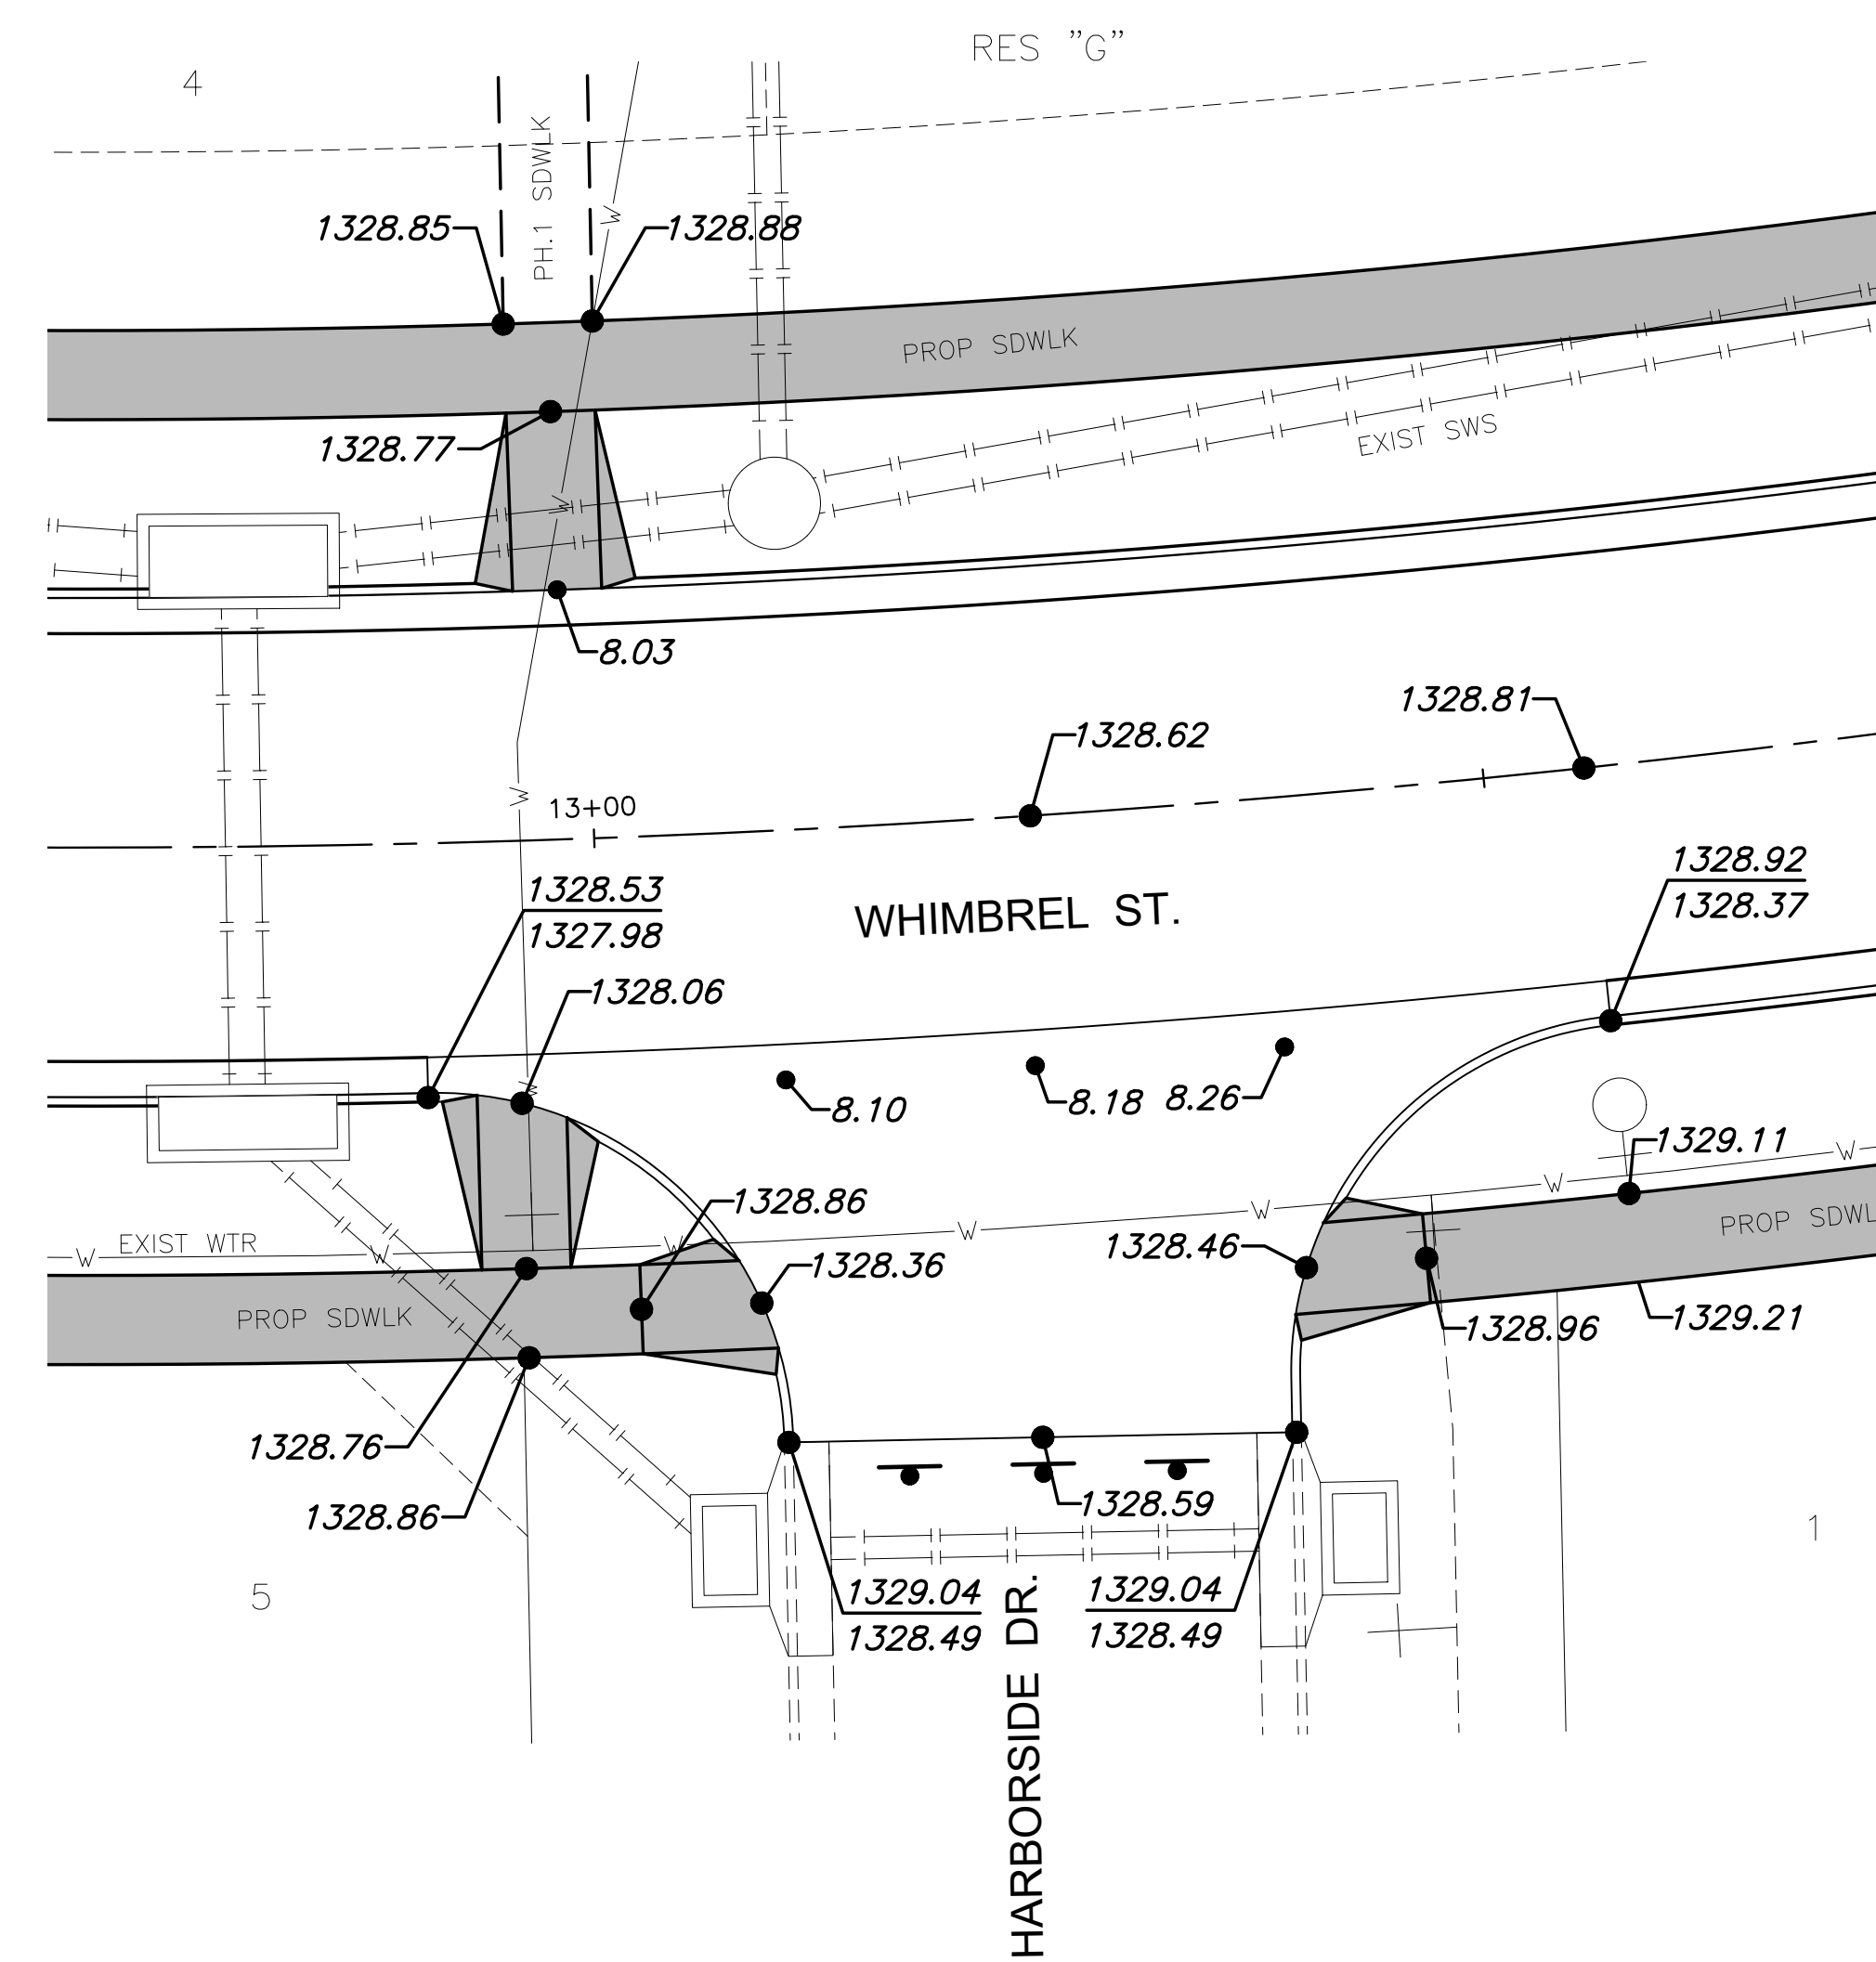

C DETAIL
1"=10'



D DETAIL
1"=10'

PAVING & INCIDENTAL DRAINAGE PLANS FOR
COURTYARDS AT THE MOORINGS
COLLECTOR PHASE - PART B

©2023
MKEC Engineering
All Rights Reserved
www.mkec.com
These drawings and their contents, including, but not limited to, all concepts, designs, & ideas are the exclusive property of MKEC Engineering (MKEC), and may not be used or reproduced in any way without the express consent of MKEC.

INTERSECTIONS

PROJECT NO.	472-2022-085819B	
DATE	SEPT. 2023	
SCALE	1" = 10'	
DESIGNED	DRAWN	CHECKED
DFL	LAL	SPE

NO.	REVISION	DATE

SHEET NO.