

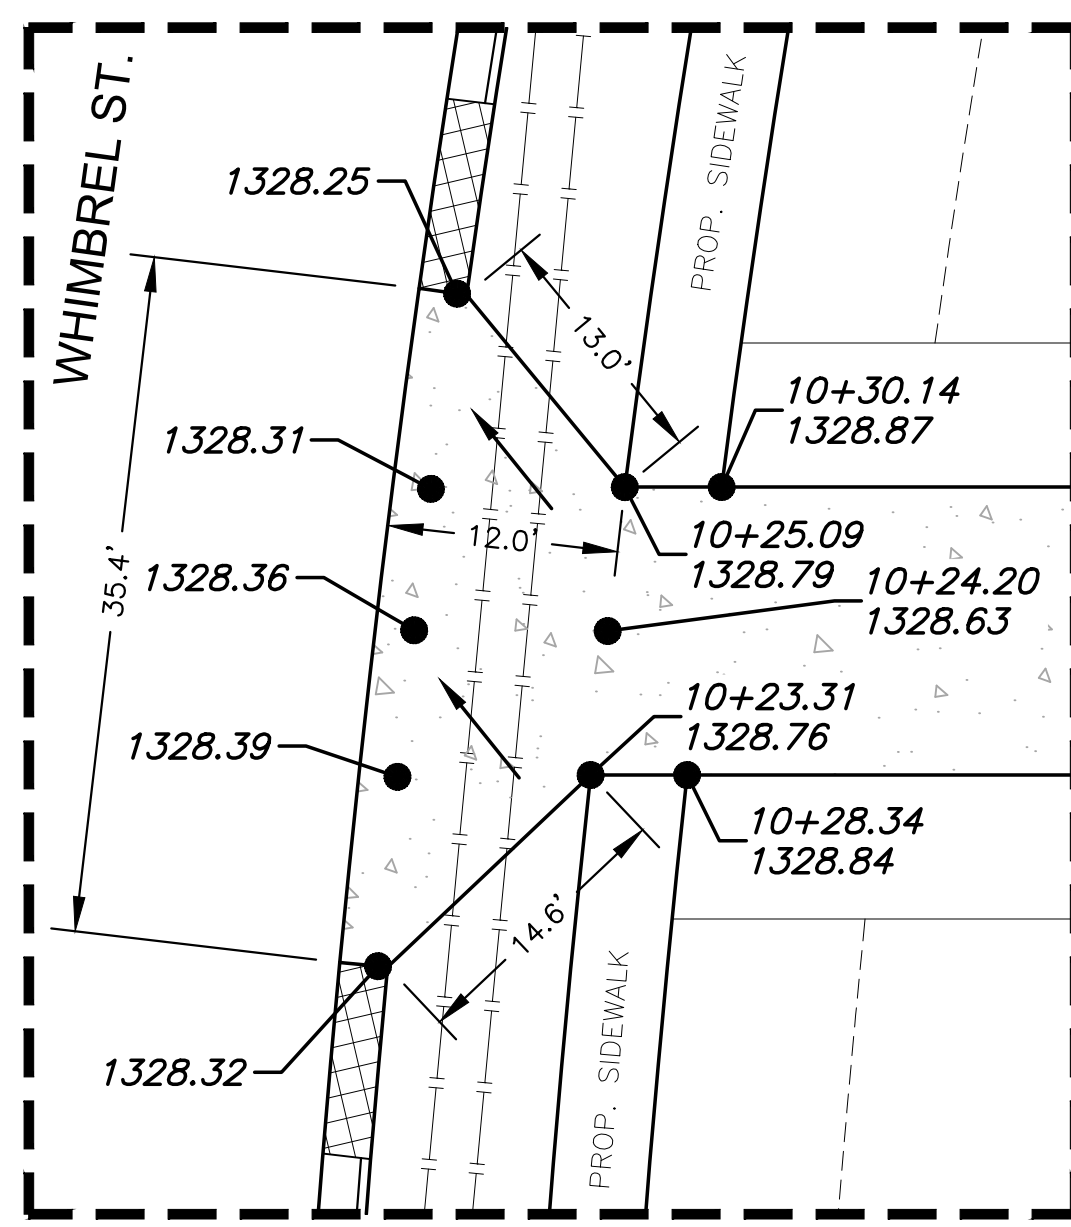


J:\PROJECTS\2022\121010427_PERFECTION_COURTYARDS AT MOORINGS\0210427 CAD\SH105 CIVIL\PAVPH121427-05-22-10-PH1.DWG
 PLOTTED: Thursday, September 14, 2023 @ 02:22PM


PAVING & INCIDENTAL DRAINAGE PLANS FOR
COURTYARDS AT THE MOORINGS
 PHASE 1 - PART B

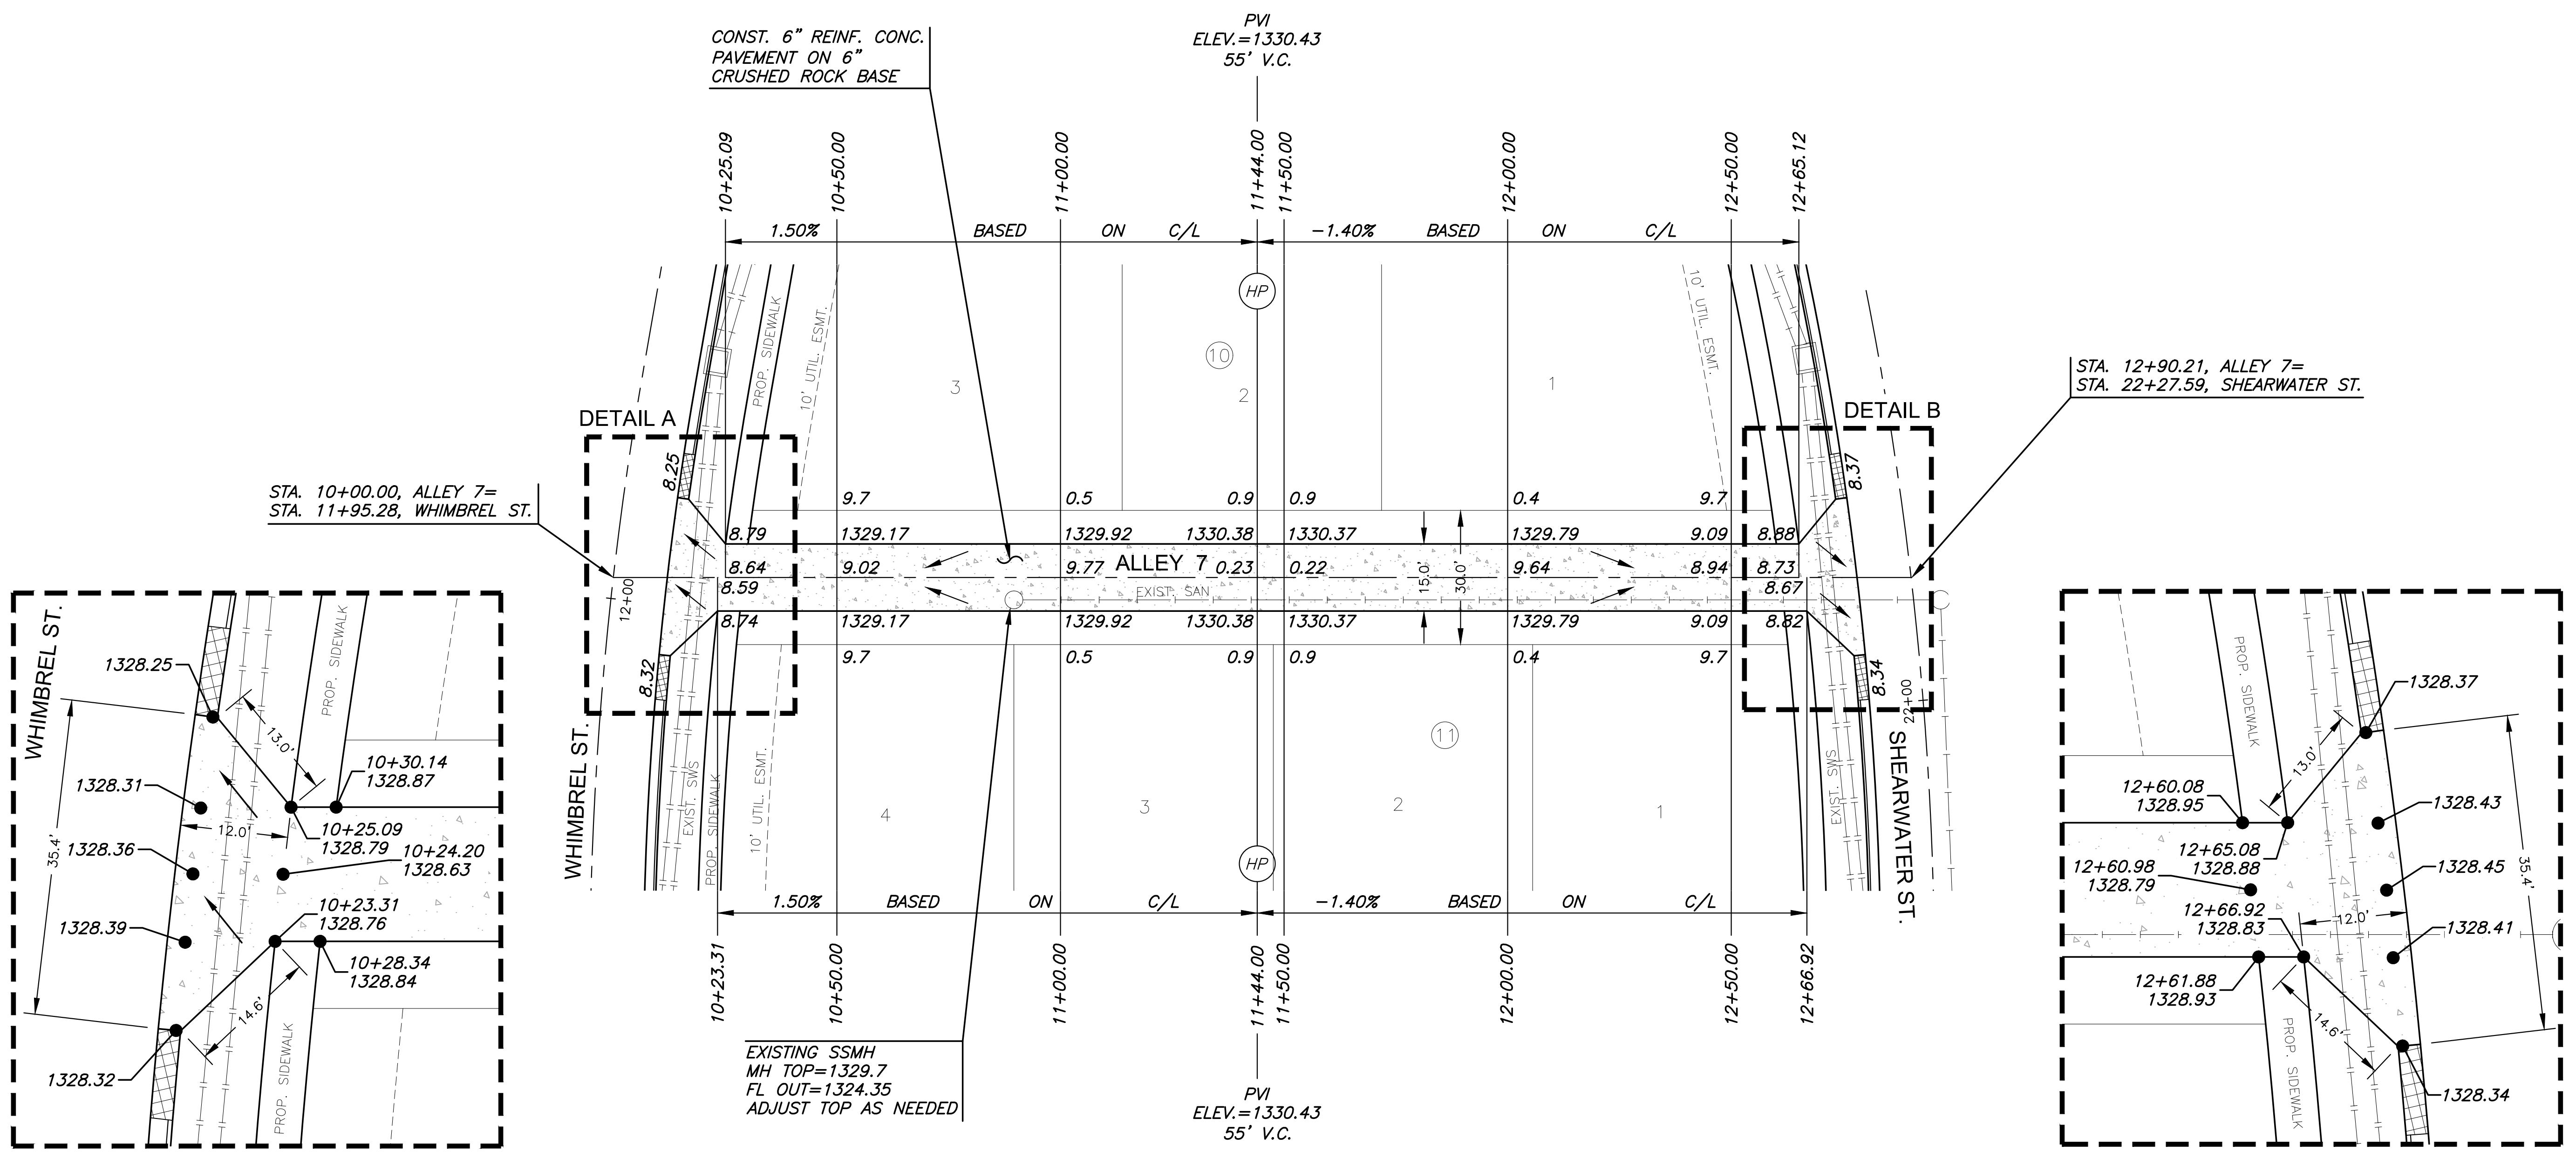

 
A **DETAIL**
SCALE: 1" = 10'

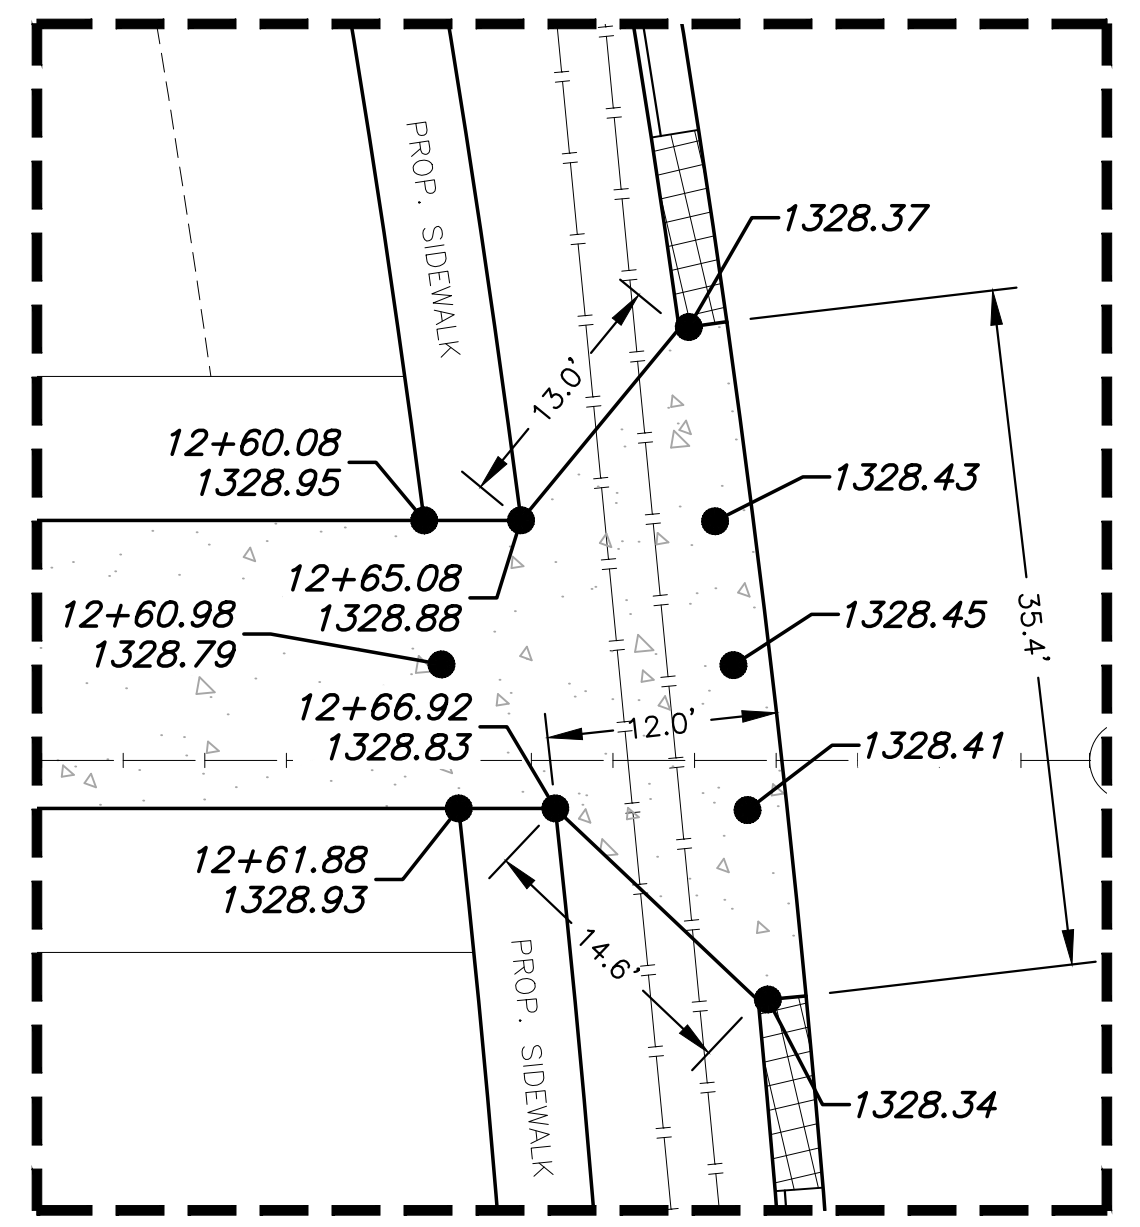

B **DETAIL**
SCALE: 1" = 10'

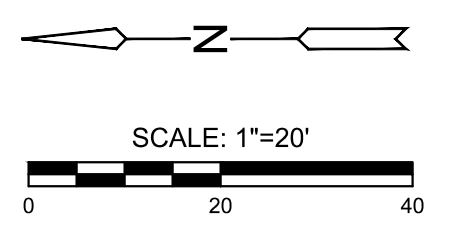

LEGEND


 STREET SIGN & SIGN LOCATION
 (SEE SIGN ASSEMBLY TABLE
 FOR TYPE & STATION OF SIGN)

NOTE:
 TOP OF CURB ELEVATIONS SHOWN
 ARE FOR FULL CURB. CONSTRUCT
 CURB AND GUTTER AS NOTED.

©2023
 MKEC Engineering
 All Rights Reserved
 www.mkec.com
 These drawings and their contents,
 including, but not limited to, all concepts,
 designs, & ideas are the exclusive
 property of MKEC Engineering (MKEC),
 and may not be used or reproduced in any
 way without the express consent of MKEC.

ALLEY 7		
PROJECT NO.	472-2022-085820B	
DATE	SEPT. 2023	
SCALE	1" = 20'	
DESIGNED	DRAWN	CHECKED
DFL	JWC	SPE
NO.	REVISION	DATE
SHEET NO.		
23 OF 51		