

CONSTRUCTION PLANS

FOR

HESS PUMP STATION SITE VALVE REPLACEMENT (PHASES 1 AND 2)


WATERLINE: CITY OF WICHITA ENGINEERING PROJECT NO. 448-2020-005881

ORG CODE 54254820

MUNIS CODE W0015

CITY OF WICHITA, KANSAS

PAUL GUNZELMAN, P.E. - CITY ENGINEER

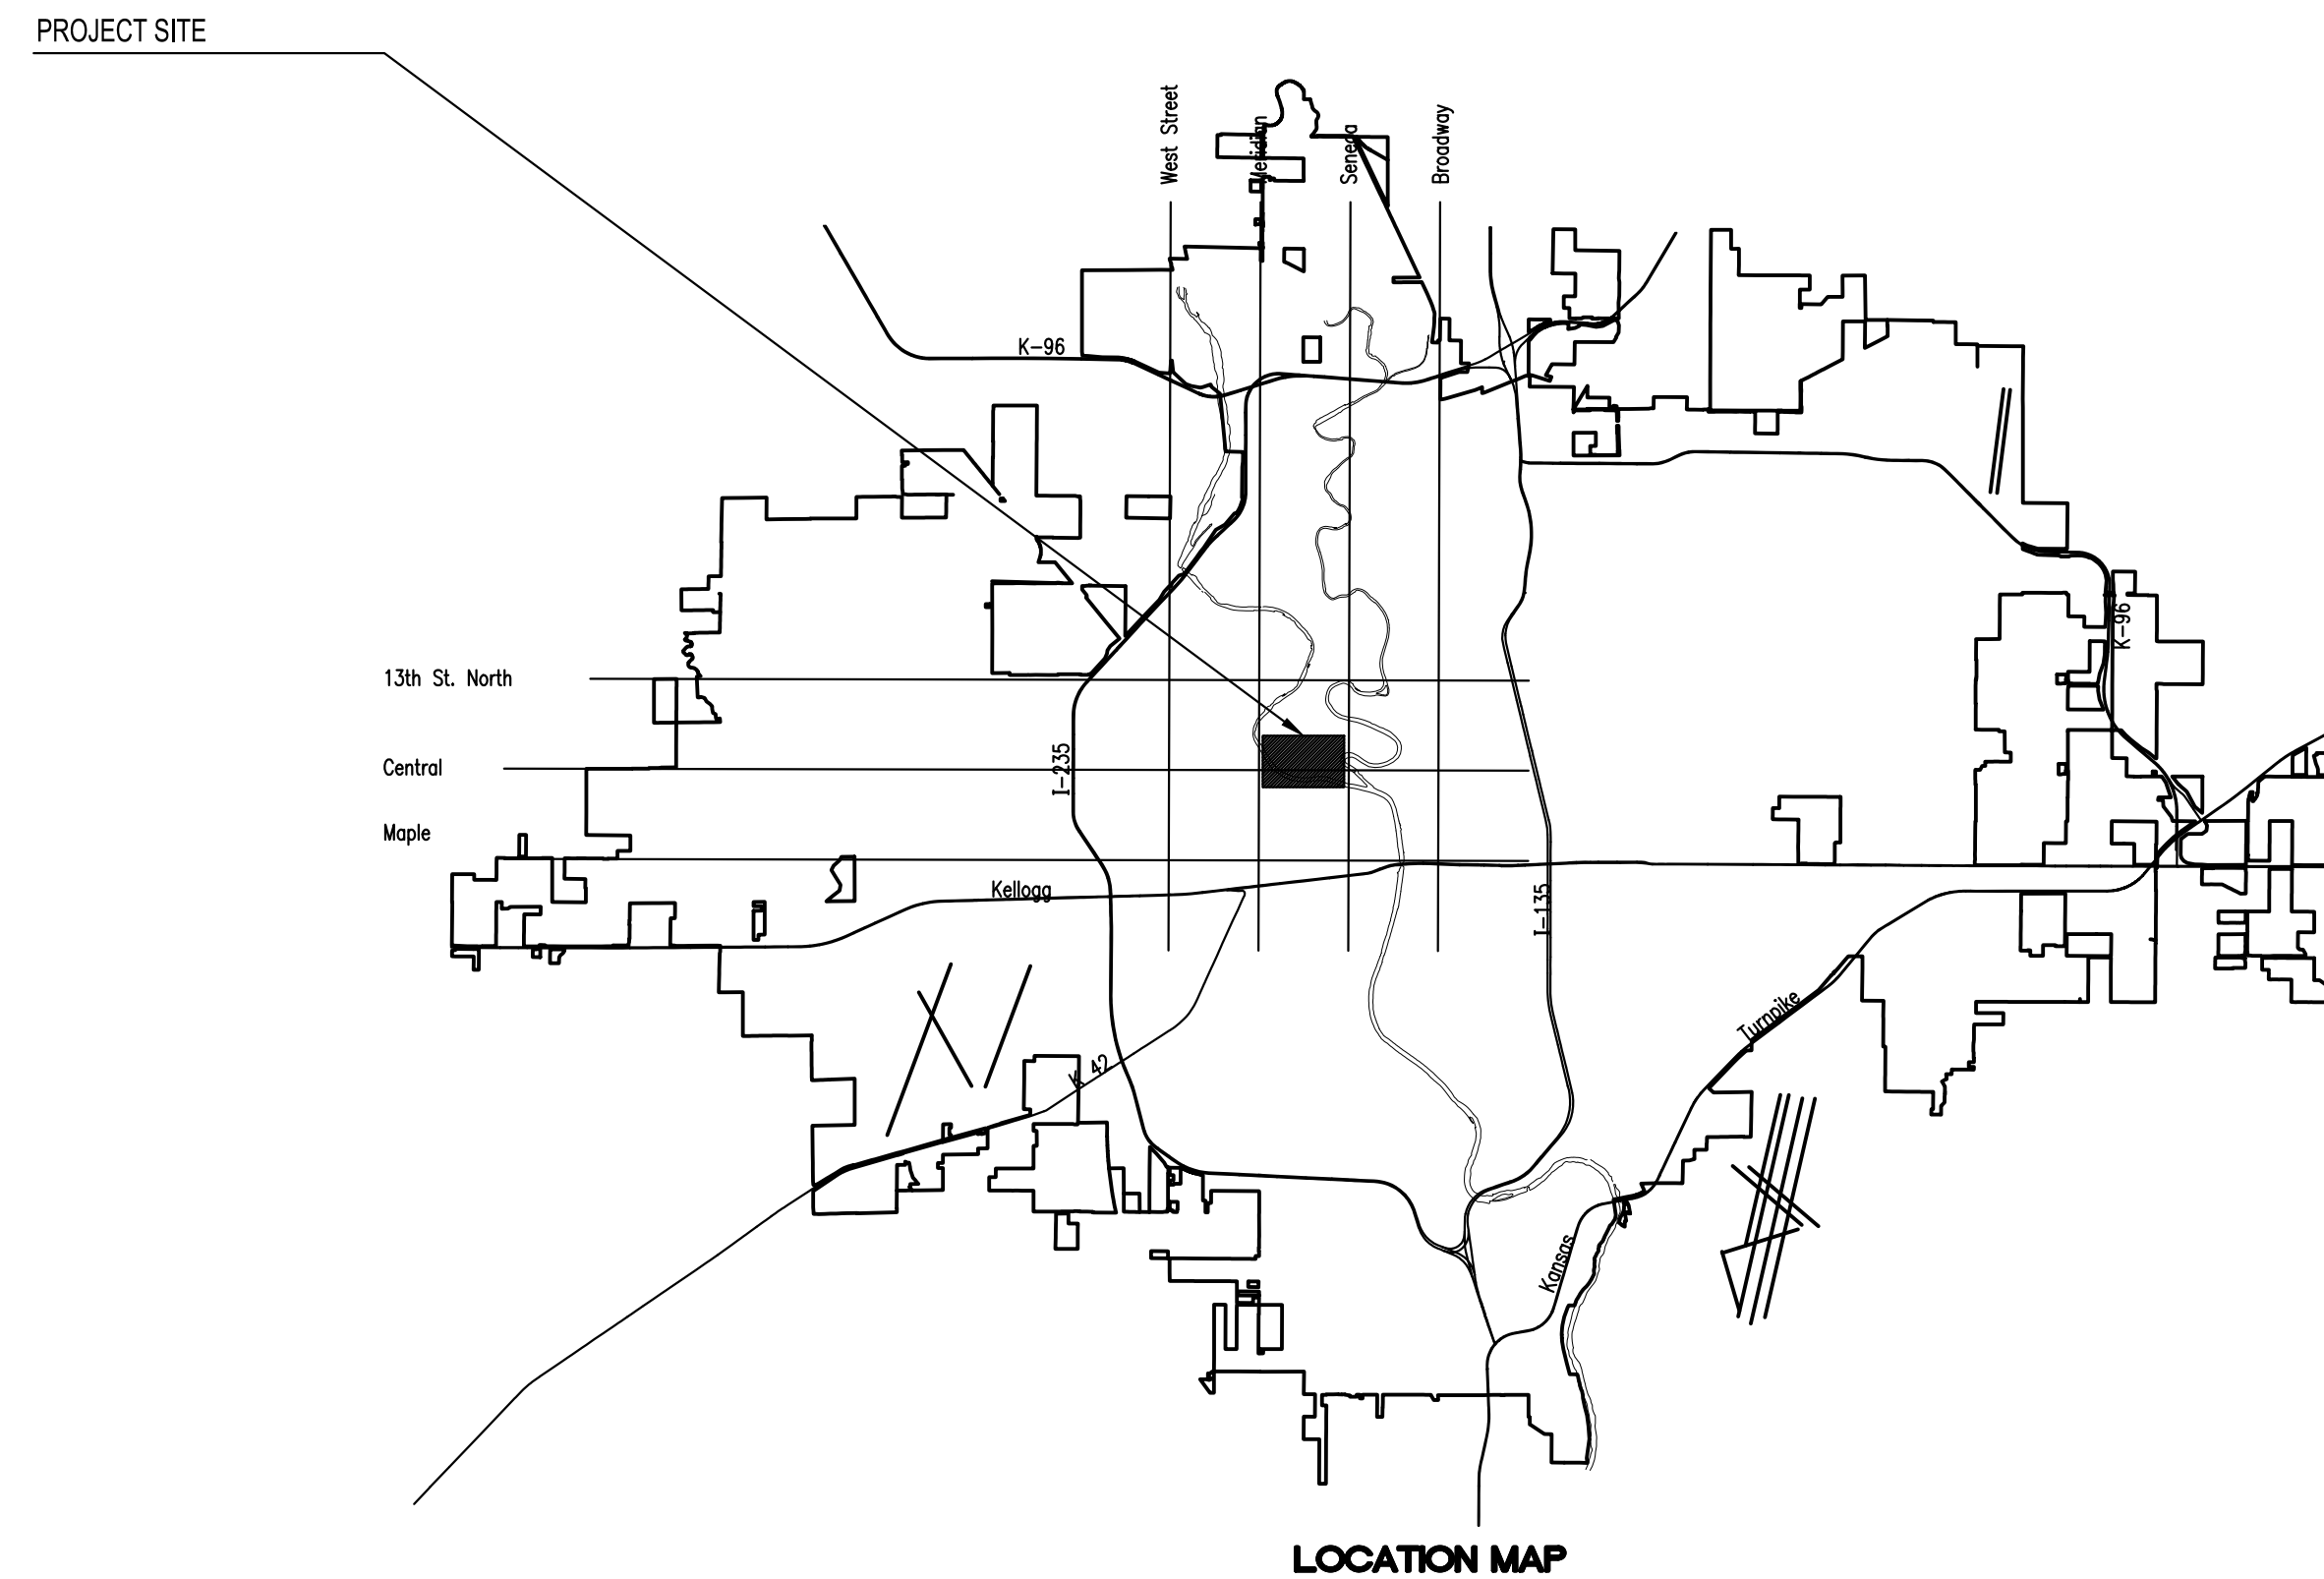

INDEX OF SHEETS

SHEET NUMBER	SHEET TITLE
C-001	TITLE SHEET
C-002	GENERAL NOTES
C-003	KEY MAP & BUBBLE MAP (PHASE 1)
C-004	KEY MAP & BUBBLE MAP (PHASE 2)
CU101	EXISTING VALVE VAULT #FUV08 (PHASE 1)
CU102	EXISTING VALVE VAULT #FUV09 (PHASE 1)
CU103	EXISTING VALVE VAULT #FUV11 (PHASE 1)
CU104	EXISTING VALVE VAULT #9235 (PHASE 1)
CU105	EXISTING VALVE VAULT #FUV12 (PHASE 2)
CU106	PROPOSED 42" VALVE VAULT (PHASE 2)
CU107	PROPOSED 42" VALVE VAULT DETAILS (PHASE 2)
CU501	MISCELLANEOUS WATER DETAILS
CU502 - CU506	EROSION CONTROL DETAILS
S-001	STRUCTURAL GENERAL NOTES
S-101	STRUCTURAL SITE PLAN
S-102	STRUCTURAL PLANS
E0.1	ELECTRICAL LEAD SHEET
E1.1	ELECTRICAL SITE PLAN
E2.1	ELECTRICAL DETAILS
E3.1	ELECTRICAL CONTROLS

OCTOBER 2023



CONSTRUCTION PLANS
 FOR
HESS PUMP STATION
SITE VALVE REPLACEMENT
(PHASE 1 AND 2)
 PAUL GUNZELMAN, P.E. - INTERIM CITY ENGINEER
 CITY OF WICHITA PROJECT NO. 448-2021-005881

Issue:		

JOB NO.	35-200335-004-0042
DATE	JUNE 2023
PM	TBK
DESIGNED BY	KJW
DRAWN BY	KTD
CHECKED BY	RWG

TITLE SHEET

C-001