


SAVED 10/26/2023 4:35:53 AM BY ROY THOMAS
 PLOTTED 10/26/2023 9:49:27 AM BY ROY THOMAS
 U:\WICHITA-CIVIL\2022\220008\03\MUNICIPALDRAWINGS\220008-003-SA101.DWG

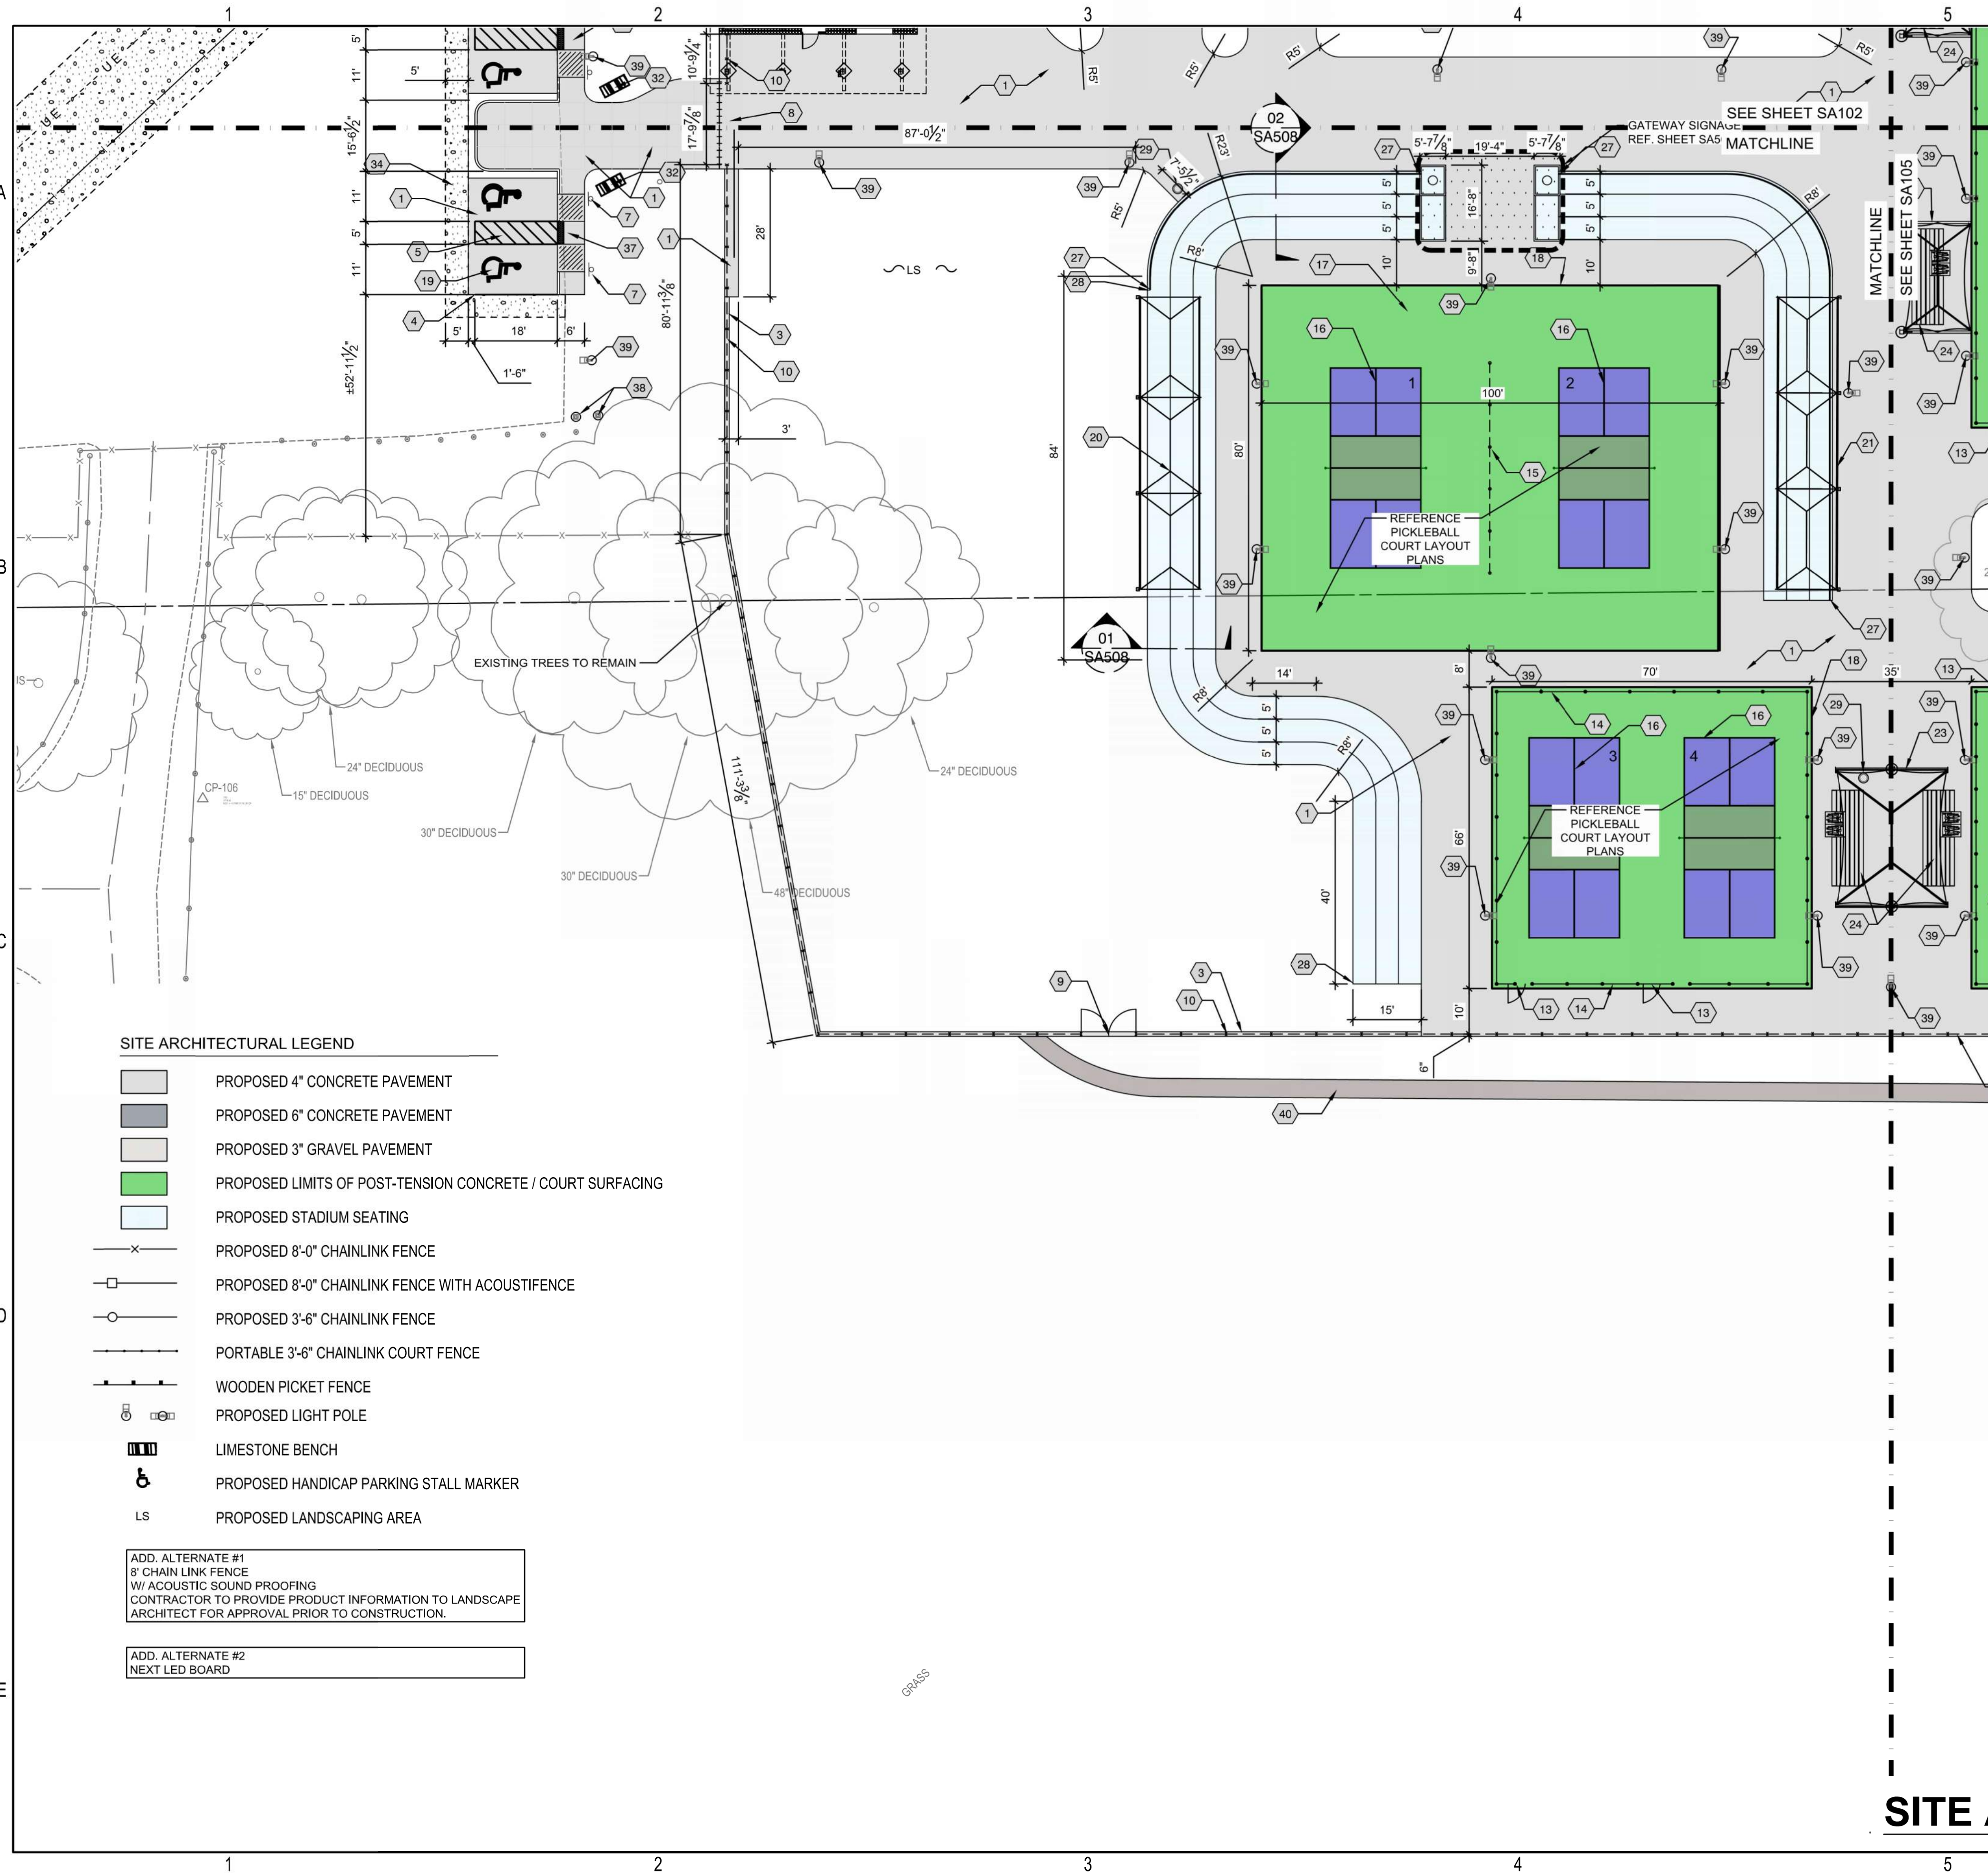

NOTES:
 1. CONTRACTOR TO PROVIDE SHOP DRAWINGS SEALED BY A LICENSED ENGINEER IN STATE OF KANSAS FOR POST-TENSIONED SYSTEM, SHOWING CABLE SPACING AND PULL DIRECTIONS.

REFERENCE NOTES SCHEDULE SHEET SA104

SYMBOL	DESCRIPTION	DETAIL
1	4" CONCRETE PAVEMENT	1/SA501
3	MOW STRIP	6/SA501
4	PARKING LOT STRIPING	3/SA502
5	STRIPING CROSS HATCH	3/SA502
6	STANDARD CURB AND GUTTER	5/SA501
7	HANDICAP SIGN	4/SA502
9	8' TALL X 4' WIDE CHAIN LINK GATE (SIM.) CONTRACTOR TO PROVIDE INFORMATION FOR LANDSCAPE ARCHITECT APPROVAL	2/SA506
10	8' CHAIN LINK FENCE	1/SA507
13	3' 6" TALL X 4' WIDE CHAIN LINK GATE SIM. CONTRACTOR TO PROVIDE INFORMATION FOR LANDSCAPE ARCHITECT APPROVAL	2/SA506
14	3'-6" CHAIN LINK FENCE	1/SA507
15	PORTABLE 3'-6" CHAIN LINK COURT FENCE	1/SA507
16	PICKLEBALL COURT MARKINGS	4/SA504
17	COURT SURFACING COLOR 3 "LIGHT GREEN"	5/SA504
18	5" POST-TENSIONED PICKLEBALL COURT	2/SA504
19	ADA PARKING SYMBOL	2/SA502
20	CHAMPIONSHIP COURT SHADE STRUCTURE (WEST SIDE) BY ATHCO OR APPROVED EQUAL	2/SA513
21	CHAMPIONSHIP COURT SHADE STRUCTURE (EAST SIDE) BY ATHCO OR APPROVED EQUAL	2/SA513
27	CHAMPIONSHIP SEATING WITH GUARDRAIL	2/SA508
28	CHAMPIONSHIP SEATING WITHOUT GUARDRAIL	1/SA508
29	TRASH RECEPTACLES RECEPTABLE 157-32SH-FTO 32 GAL W/SHIELD SIDE DOOR FLAT TOP LID BY DUMOR, INC OR APPROVED EQUAL	2/SA505
32	LIMESTONE BENCHES CUSTOM CUT FLINT HILLS GRAY LIMESTONE 24" TALL X 30" WIDE X 72" LONG BY U.S. STONE INDUSTRIES OR APPROVED EQUAL	2/SA505
34	REMOVE AND RESET 3" GRAVEL PAVEMENT IN KIND.	1/SA502
37	ADA RAMP TYPE 2	1/SA503
38	FOOD TRUCK PEDESTAL REFERENCE ELECTRICAL PLANS	1/SA503
39	SITE LIGHTING REFERENCE ELECTRICAL PLANS	1/SA503
40	4' WIDE CONCRETE FLUME	7/SA501

SITE ARCHITECTURAL LEGEND

- PROPOSED 4" CONCRETE PAVEMENT
- PROPOSED 6" CONCRETE PAVEMENT
- PROPOSED 3" GRAVEL PAVEMENT
- PROPOSED LIMITS OF POST-TENSION CONCRETE / COURT SURFACING
- PROPOSED STADIUM SEATING
- PROPOSED 8'-0" CHAINLINK FENCE
- PROPOSED 8'-0" CHAINLINK FENCE WITH ACOUSTIFENCE
- PROPOSED 3'-6" CHAINLINK FENCE
- PORTABLE 3'-6" CHAINLINK COURT FENCE
- WOODEN PICKET FENCE
- PROPOSED LIGHT POLE
- LIMESTONE BENCH
- PROPOSED HANDICAP PARKING STALL MARKER
- PROPOSED LANDSCAPING AREA

ADD. ALTERNATE #1
 8' CHAIN LINK FENCE
 W/ ACOUSTIC SOUND PROOFING
 CONTRACTOR TO PROVIDE PRODUCT INFORMATION TO LANDSCAPE ARCHITECT FOR APPROVAL PRIOR TO CONSTRUCTION.

ADD. ALTERNATE #2
 NEXT LED BOARD




**SOUTH LAKES
 SPORTS PARK**
 WICHITA, KS

Issue:		
100% PLANS		10/18/23
BID SETS		10/25/23

JOB NO.	220008-003
DATE	18 OCTOBER 2023
PM	NLS
DESIGNED BY	NLS
DRAWN BY	RFT
CHECKED BY	MEB

SITE ARCHITECTURAL PLAN

SA104

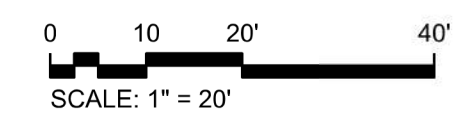

SITE ARCHITECTURAL PLAN