


NOTE

FOUNTAIN AS MANUFACTURED BY OR APPROVED EQUAL: MOST DEPENDABLE FOUNTAINS MODEL NO. PEDESTAL BOTTLE FILLER 10145 SM STANDARD 304 10 STAINLESS STEEL


1. COLOR: BY OWNER FROM LIST OF MANUFACTURER'S COLORS
2. SEE PLUMBING PLANS FOR CONNECTIONS
3. INCLUDE 3' SQUARE CONCRETE PAD FOR INSTALLATION

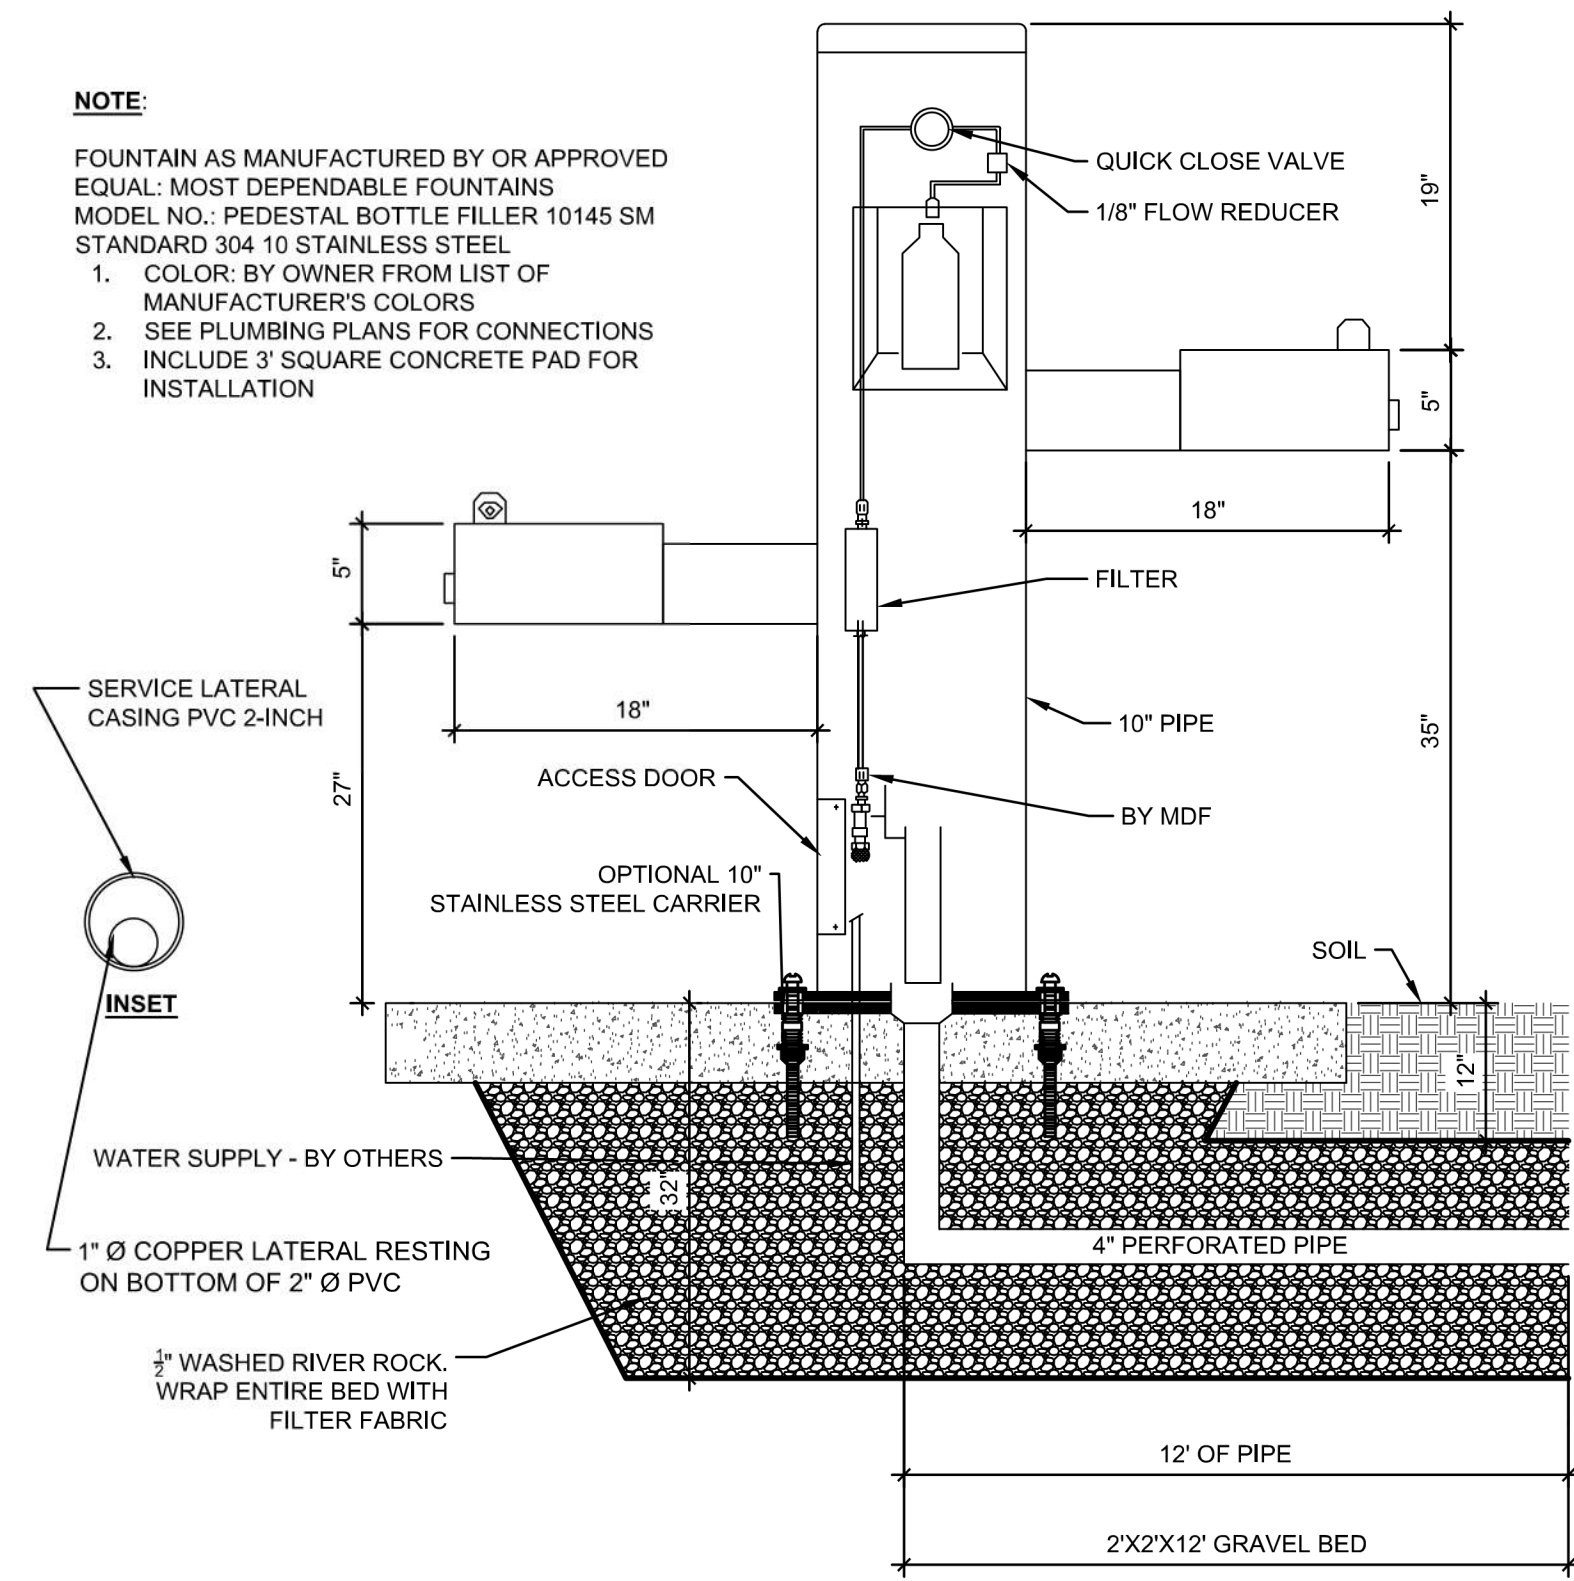

1 DRINKING FOUNTAIN DETAIL

3/4" = 1'-0"


VIEW-111007631

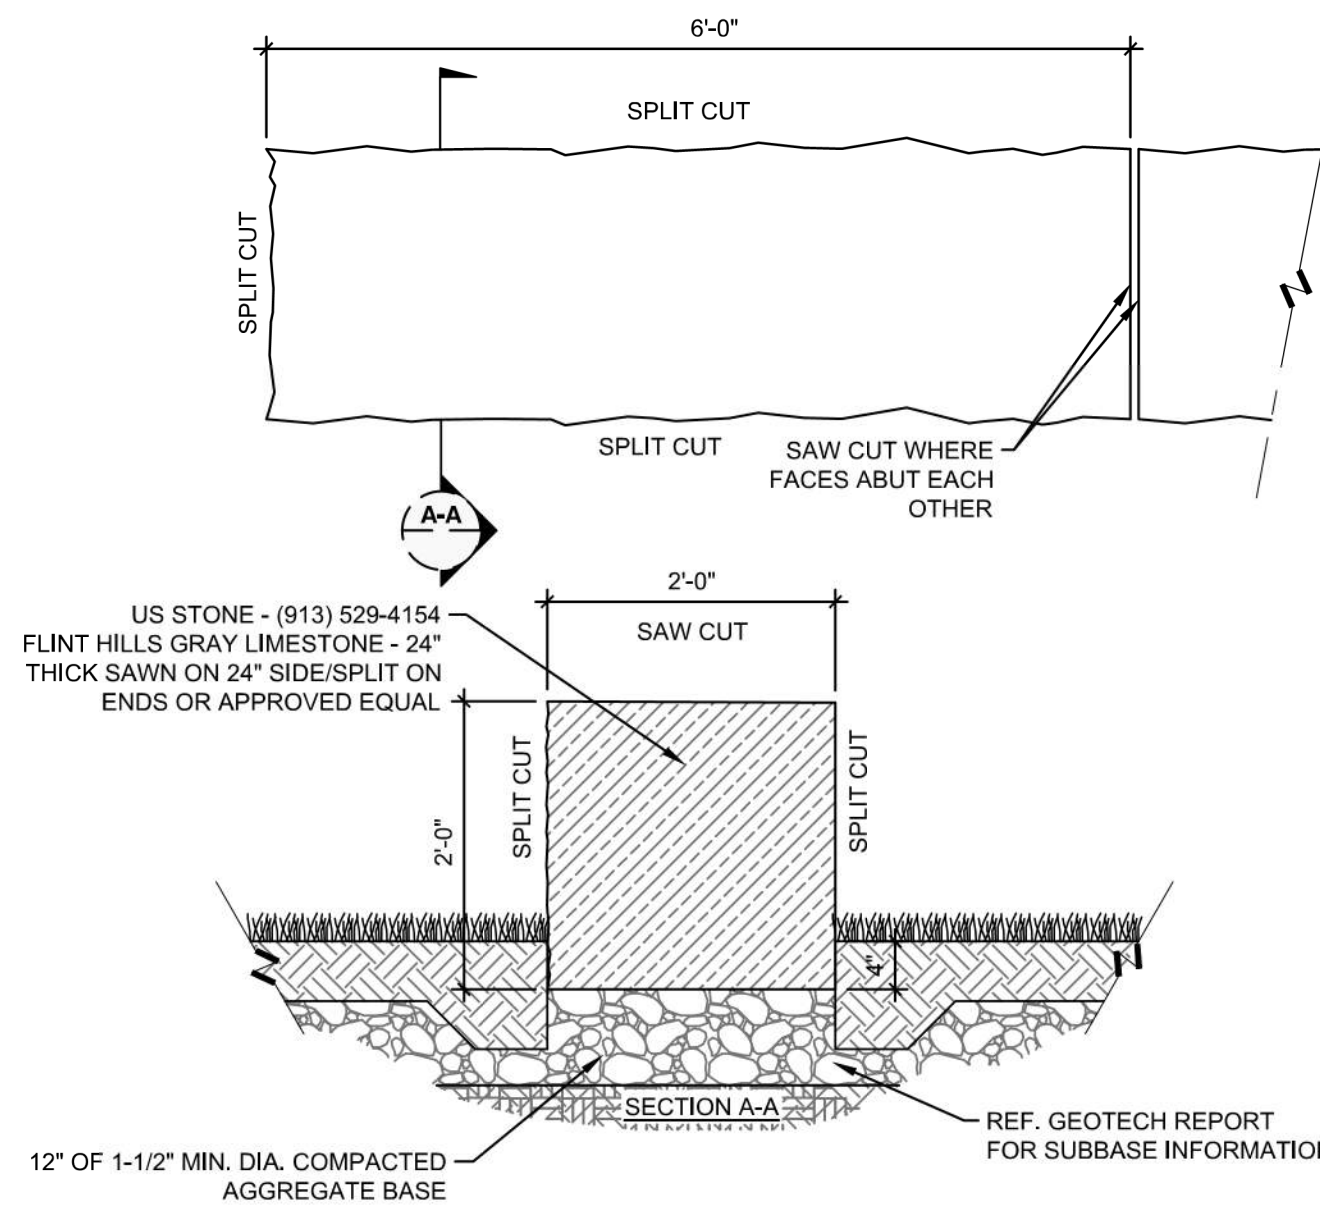

2 LIMESTONE BENCH DETAIL

3/4" = 1'-0"


VIEW-113056541

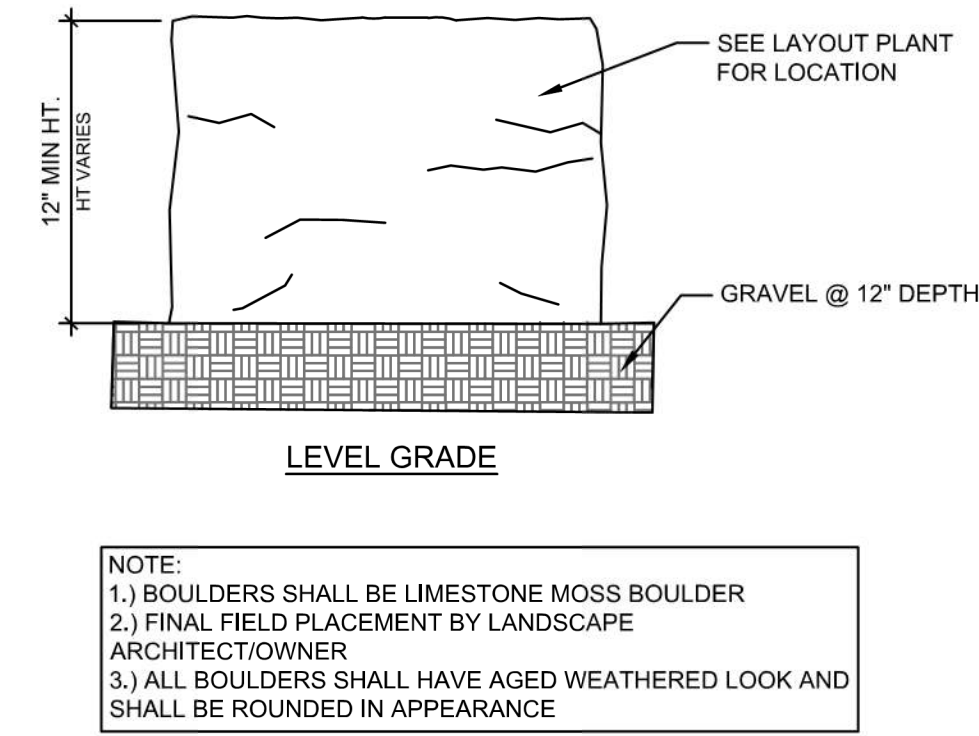

3 LIMESTONE BOULDER


3/4" = 1'-0"

VIEW-443657994

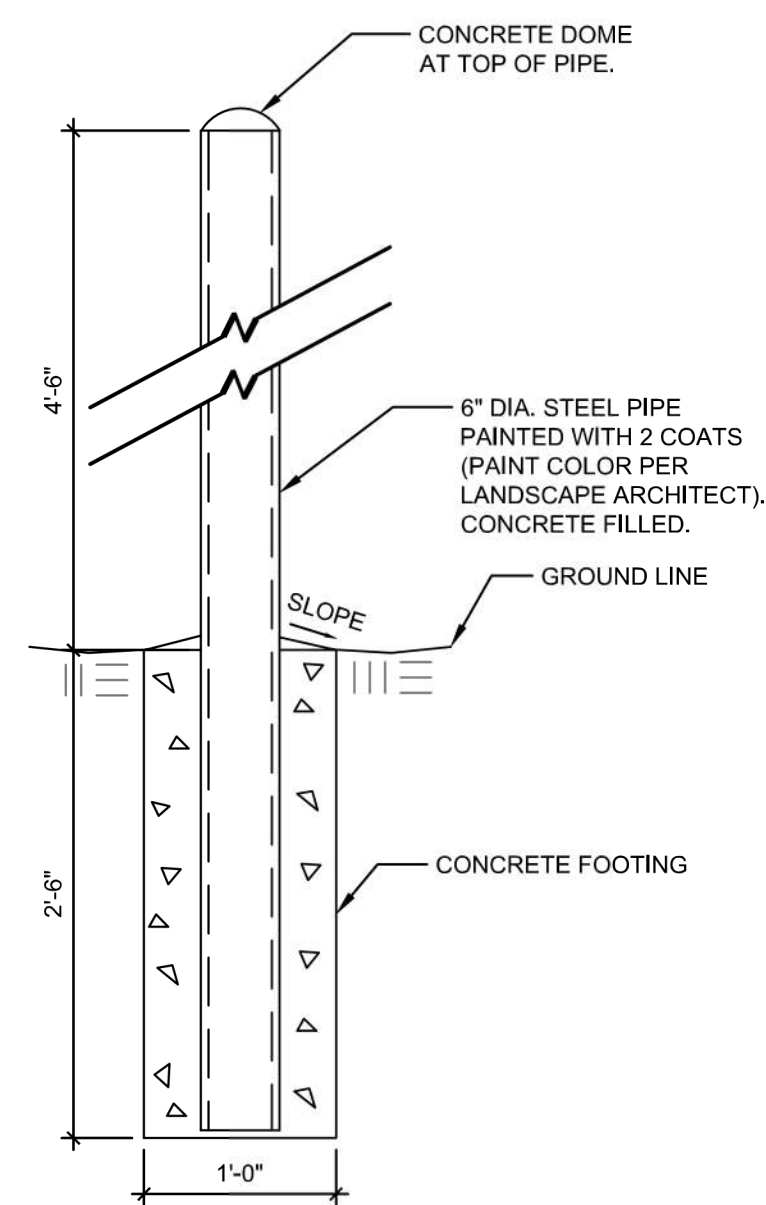

4 PERMANENT BOLLARD

1" = 1'-0"

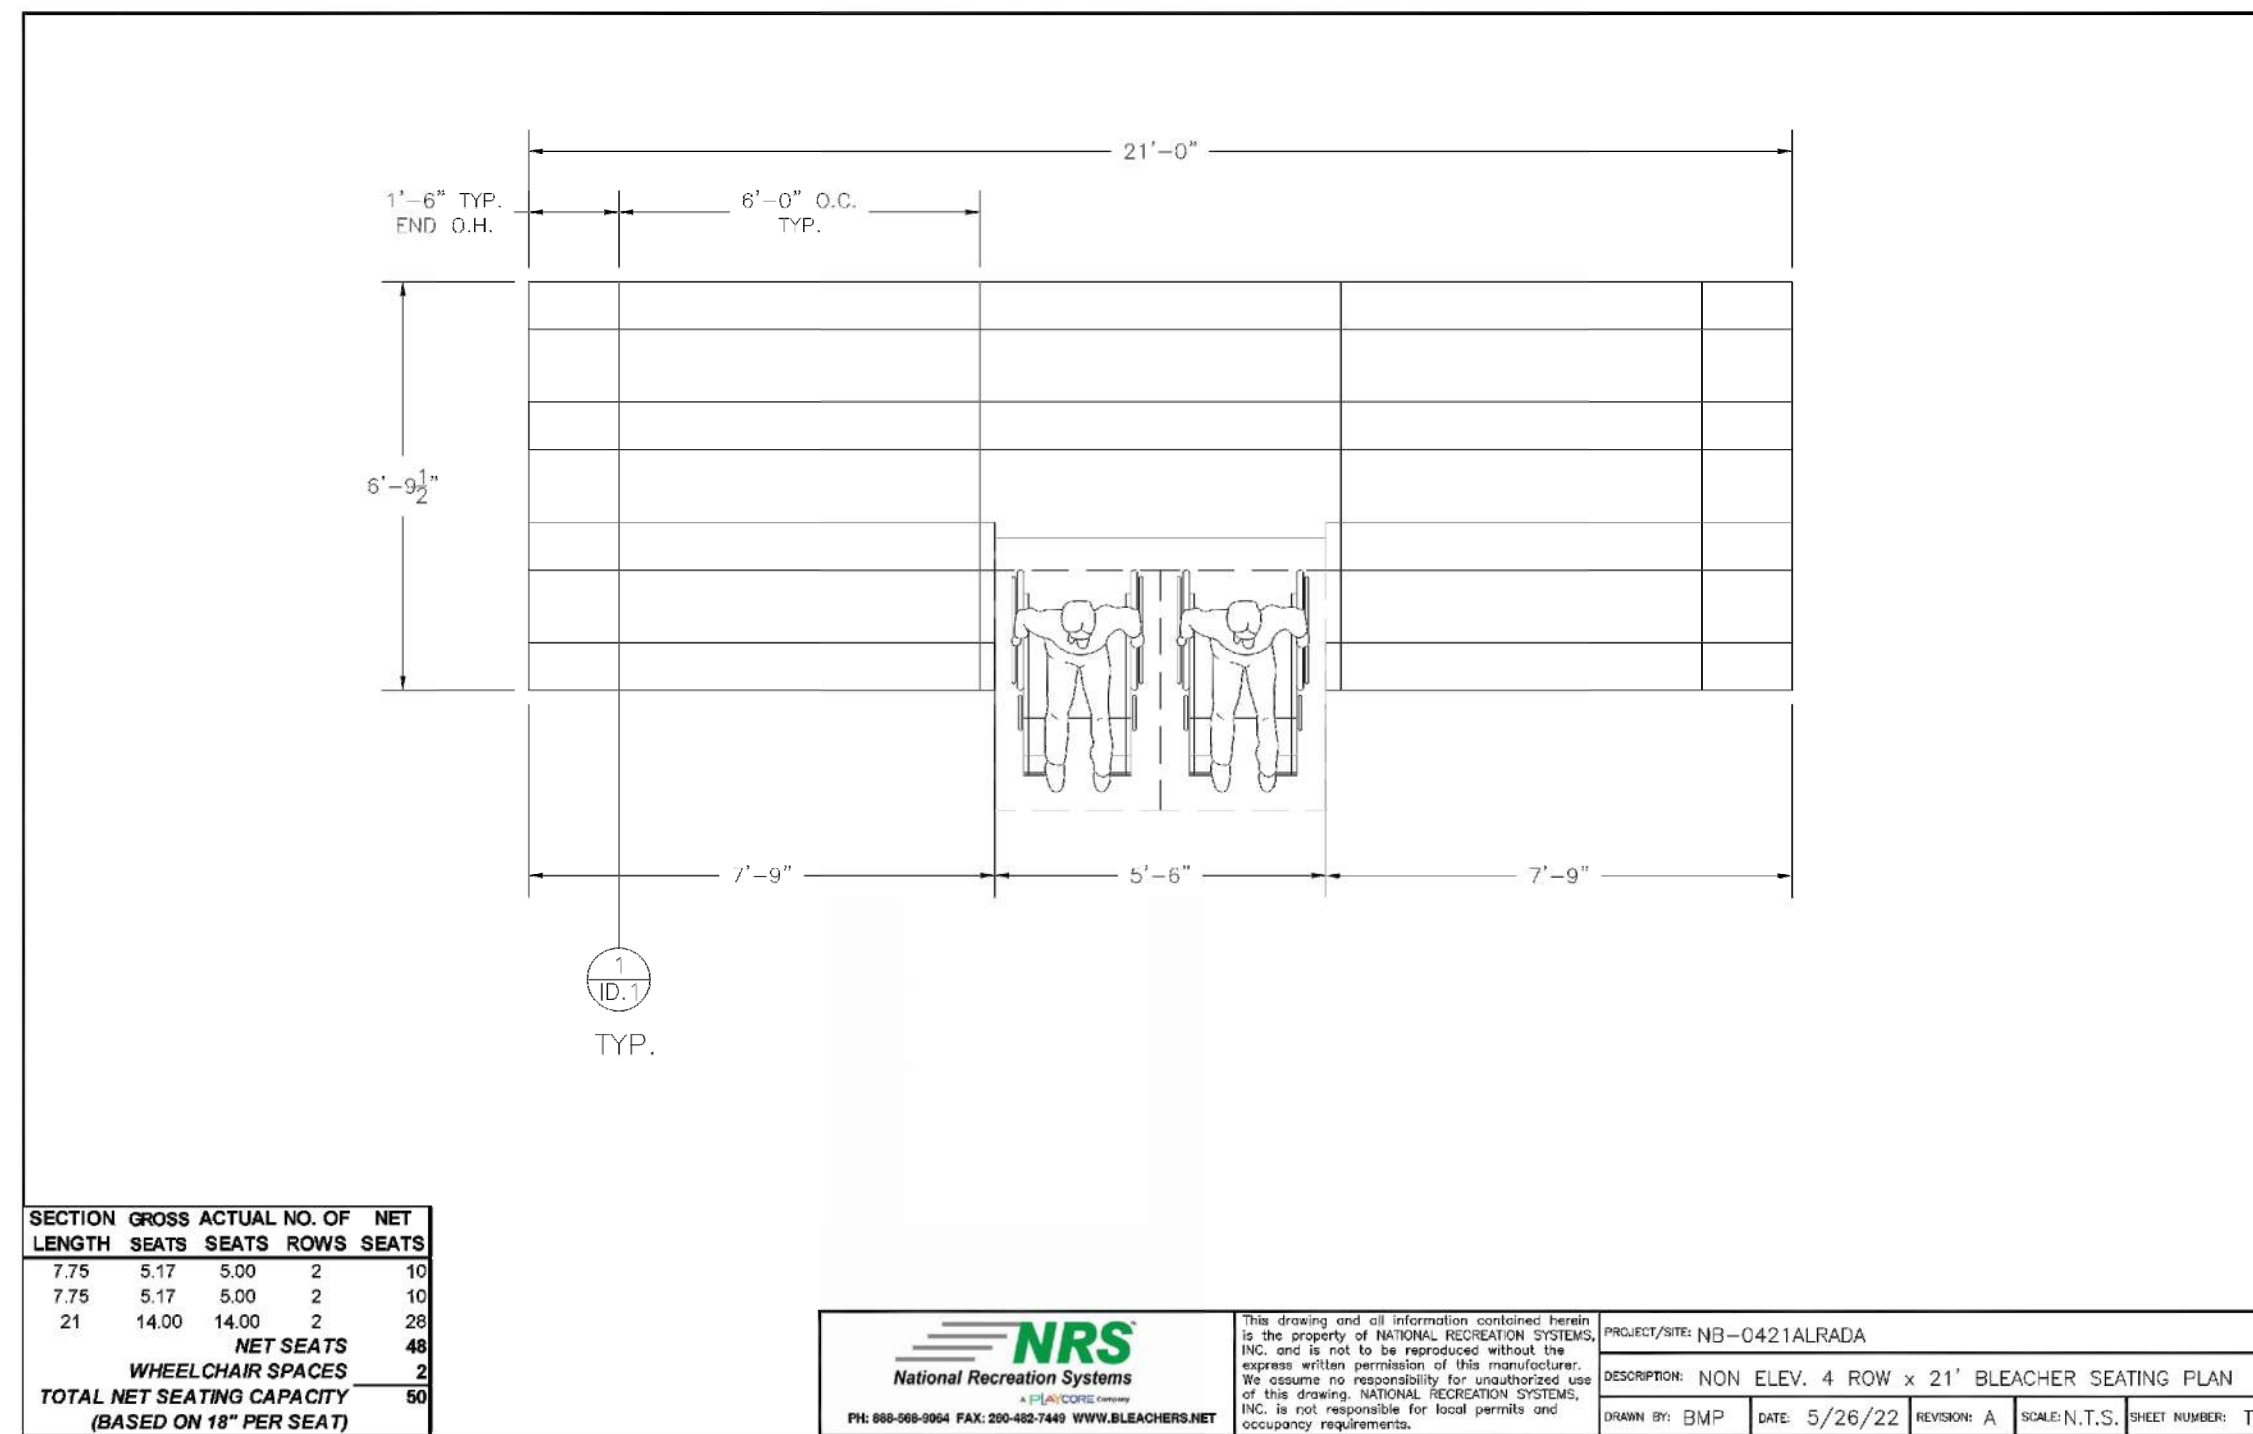

SECTION	GROSS LENGTH	GROSS SEATS	ACTUAL SEATS	NO. OF ROWS	NET SEATS
1	7.75	5.17	5.00	2	10
2	7.75	5.17	5.00	2	10
3	21	14.00	14.00	2	28
NET SEATS					48
WHEELCHAIR SPACES					2
TOTAL NET SEATING CAPACITY (BASED ON 18" PER SEAT)					50



This drawing and all information contained herein is the property of NATIONAL RECREATION SYSTEMS, INC. and is not to be reproduced without the express written permission of this manufacturer. We assume no responsibility for unapproved use of this drawing. NATIONAL RECREATION SYSTEMS, INC. is not responsible for local permits and occupancy requirements.

PROJECT/PRJ: NB-0421ALRADA
 DESCRIPTION: NON ELEV. 4 ROW x 21' BLEACHER SEATING PLAN
 DRAWN BY: GMP DATE: 5/26/22 REVISION: A DRAWN BY: T.S. SHEET NUMBER: TD.1

5 BLEACHER DETAIL

3/4" = 1'-0"

VIEW-368659497



SOUTH LAKES PARK - PICKLEBALL COMPLEX
 WICHITA, KS

Issue:		
BID SET		5/25/23

JOB NO.	220008-001
DATE	25 MAY 2023
PM	NLS
DESIGNED BY	NLS
DRAWN BY	JSG
CHECKED BY	MEB

SITE ARCHITECTURAL DETAILS

SA505