


SAVED 10/25/2023 4:23:51 PM BY CHANCE SWANEY  
 PLOTTED 10/25/2023 4:26:59 PM BY CHANCE SWANEY  
 U:\WICHITA-CIVIL\2022\2008\03\MUNIDRAWINGS\220008-003-CU101.DWG

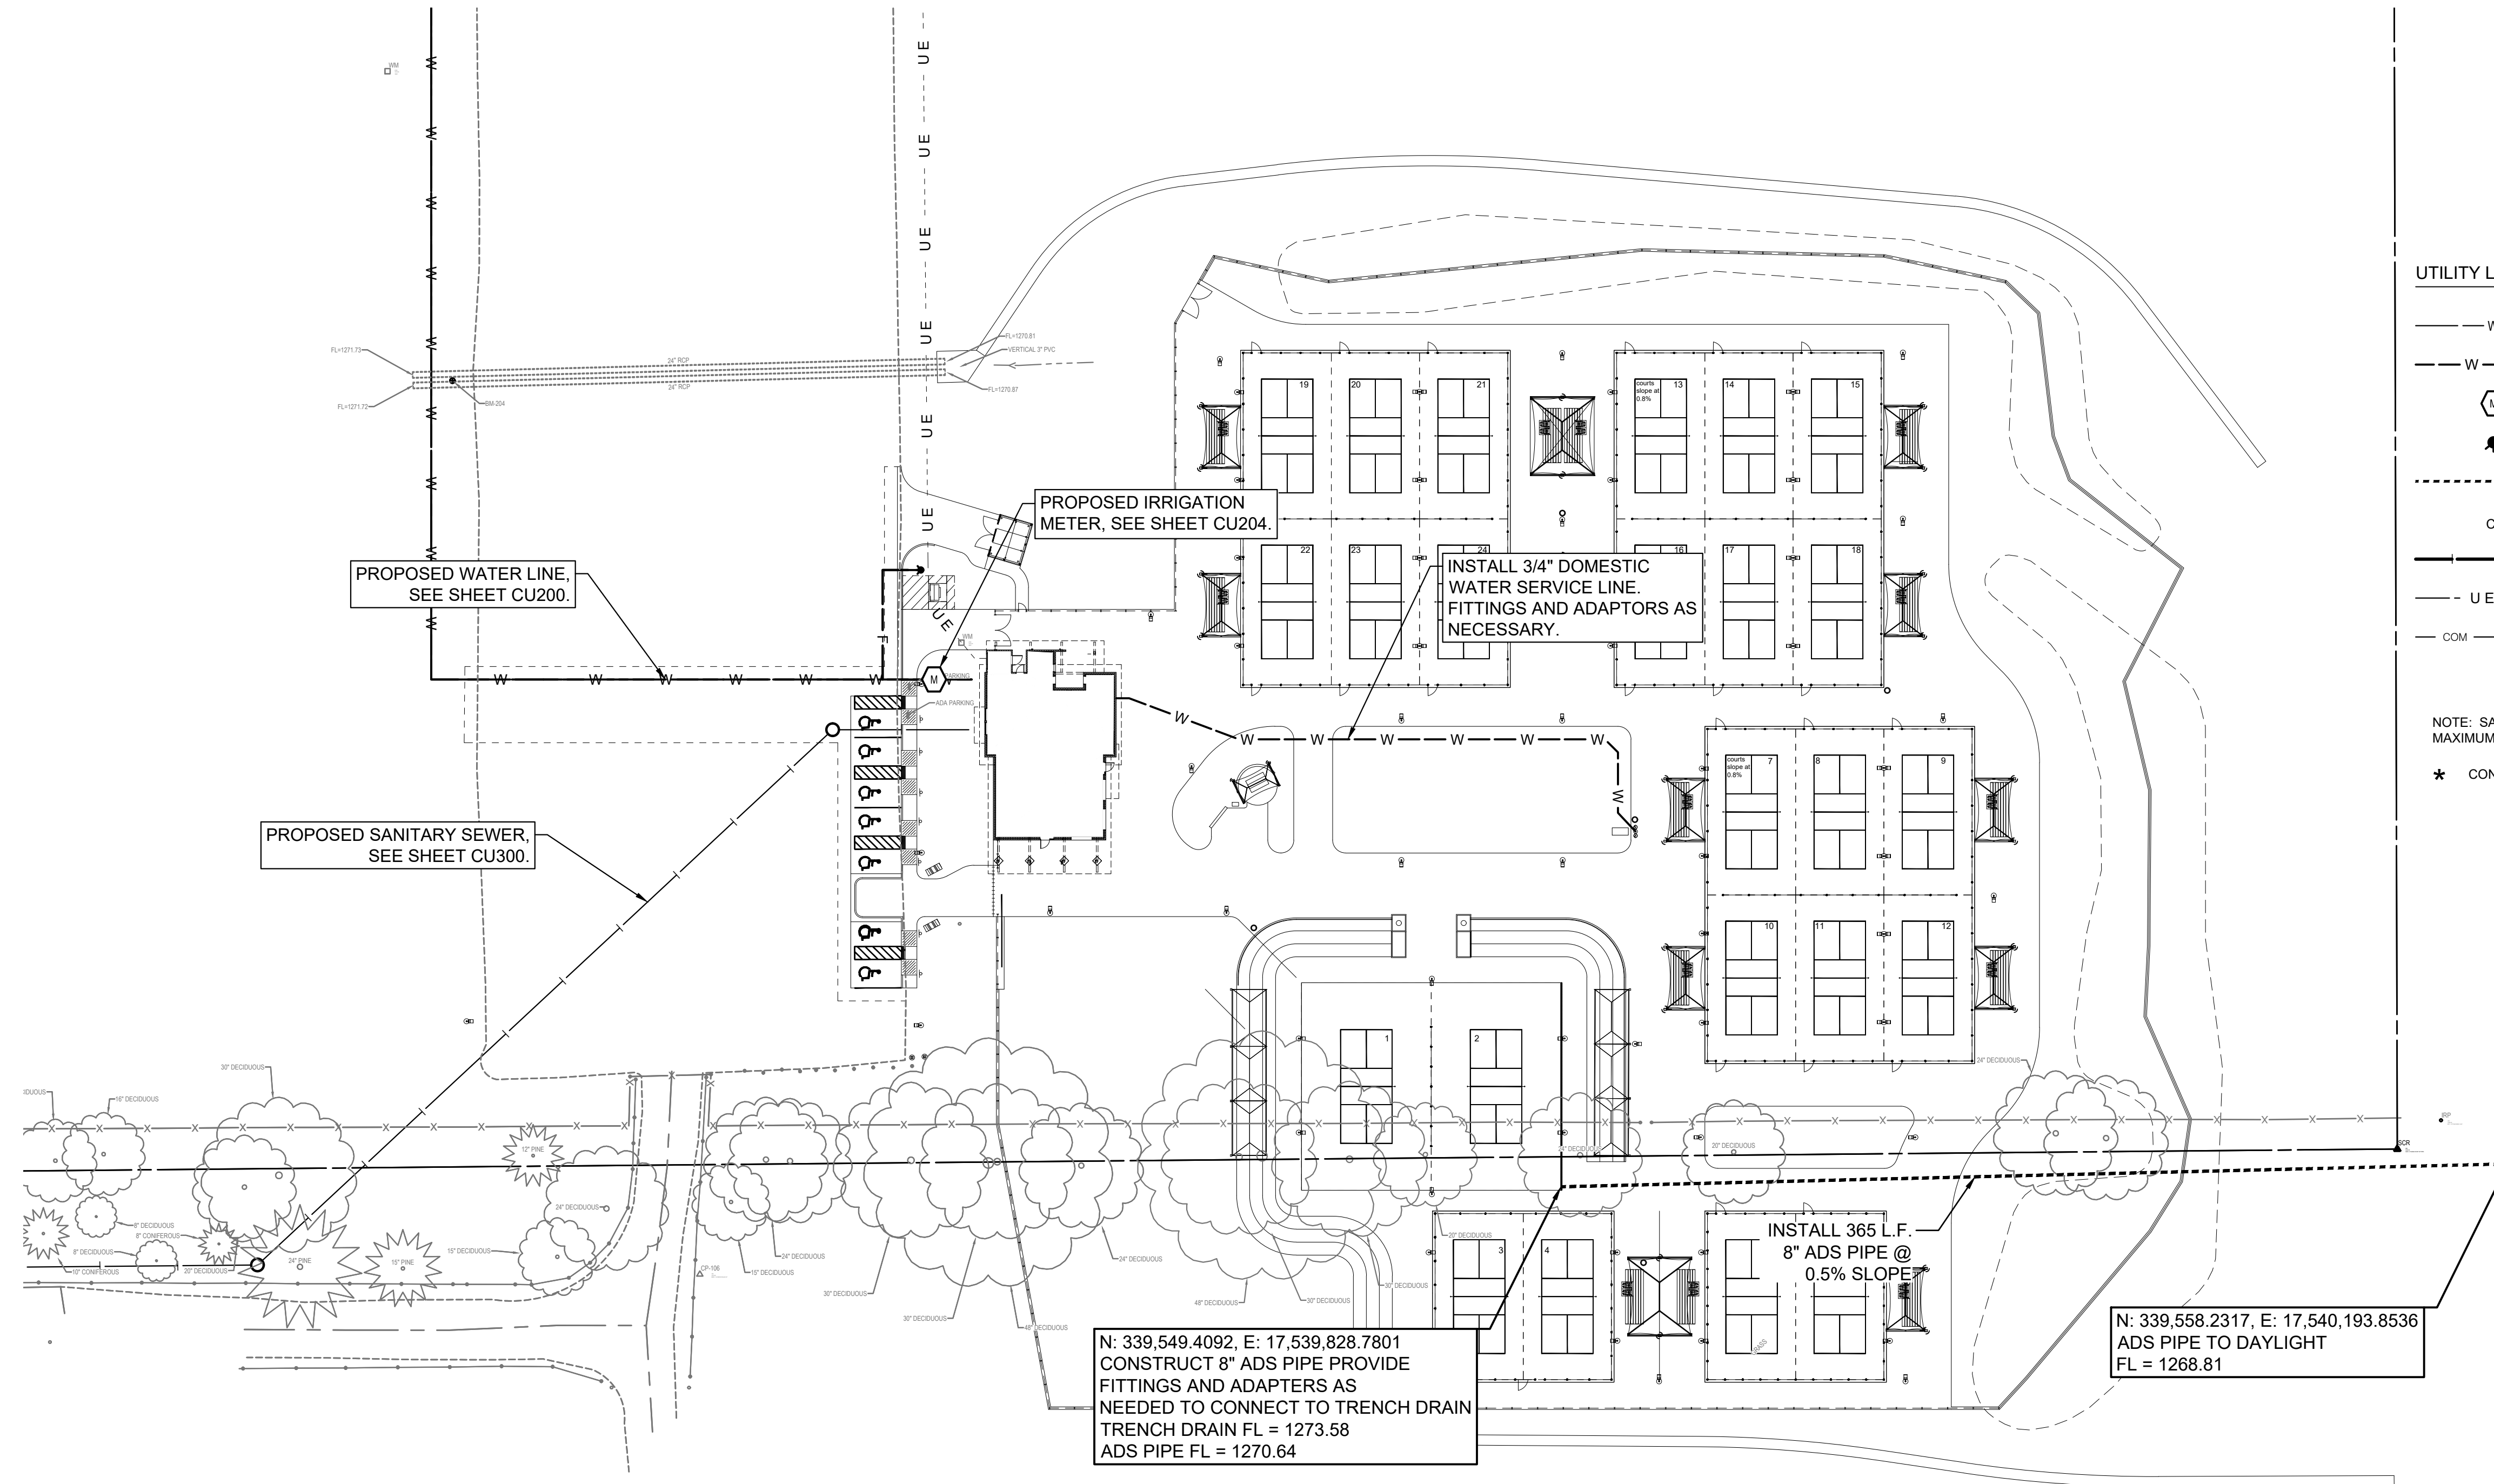

- UTILITY LEGEND
- W — EXISTING WATERLINE
  - - - W - - - PROPOSED WATERLINE
  - ⊕ PROPOSED WATER METER
  - ⚡ PROPOSED FIRE HYDRANT
  - - - - - PROPOSED STORM LINE
  - CO PROPOSED SANITARY SEWER CLEANOUT
  - S — PROPOSED SANITARY SEWER
  - - - U E - - - PROPOSED ELECTRIC LINE
  - COM — PROPOSED COMMUNICATION LINE

NOTE: SANITARY SEWER CLEANOUTS TO BE INSTALLED AT ALL BENDS. MAXIMUM SPACING BETWEEN CLEANOUTS IS 100 L.F.

\* CONTRACTOR TO REIMBURSE CITY OF WICHITA FOR THIS WORK




**SOUTH LAKES  
 SPORTS PARK  
 WICHITA, KS**

Issue:		
100% PLANS		10/18/23
BID SETS		10/25/23
JOB NO.	220008-003	
DATE	18 OCTOBER 2023	
PM	NLS	
DESIGNED BY	NLS	
DRAWN BY	RFT	
CHECKED BY	MEB	



**OVERALL UTILITY PLAN**

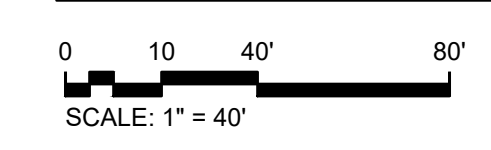

OVERALL UTILITY PLAN

CU101