

**LEGEND**

- Pavement Removal
- Sidewalk Removal
- Curb & Gutter Removal



**SCALE**  
 PLAN: Lat. & Long. 20' 0 20' 40'

**Note:**  
 The Contractor shall see streetscape plans for all items of construction beyond the back of curb, See Sheets 17-40

**(XXX)** For Storm Sewer coordinate data, See Sheet 54  
 For Storm Profiles, See Sheet 41  
 For Electrical and Lighting Plans, See Sheets 92-96

**(XXX)** For Right of Way Callouts, See Sheet 54

Contractor is to field verify all utility locations and elevations prior to excavating. Utility locations and elevations are shown to the best knowledge of the utility companies.

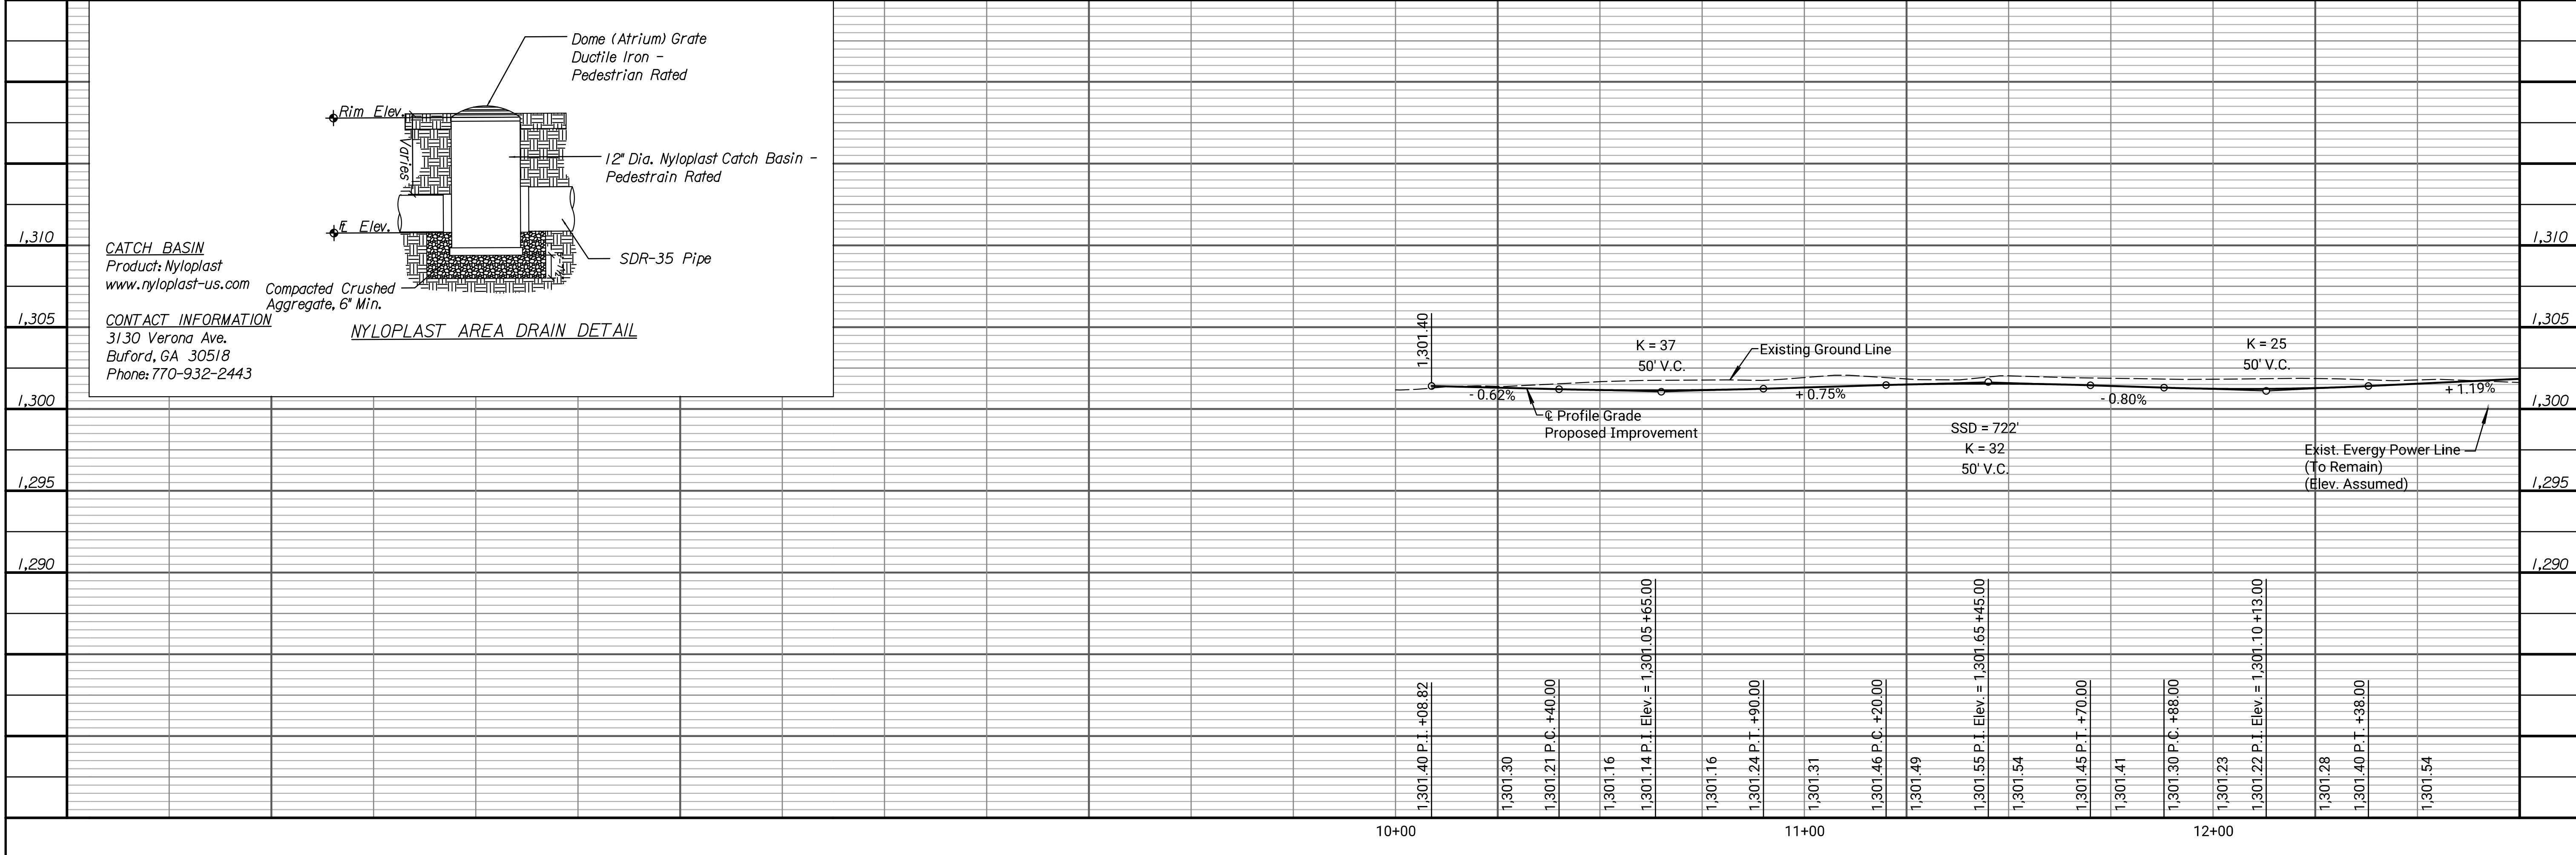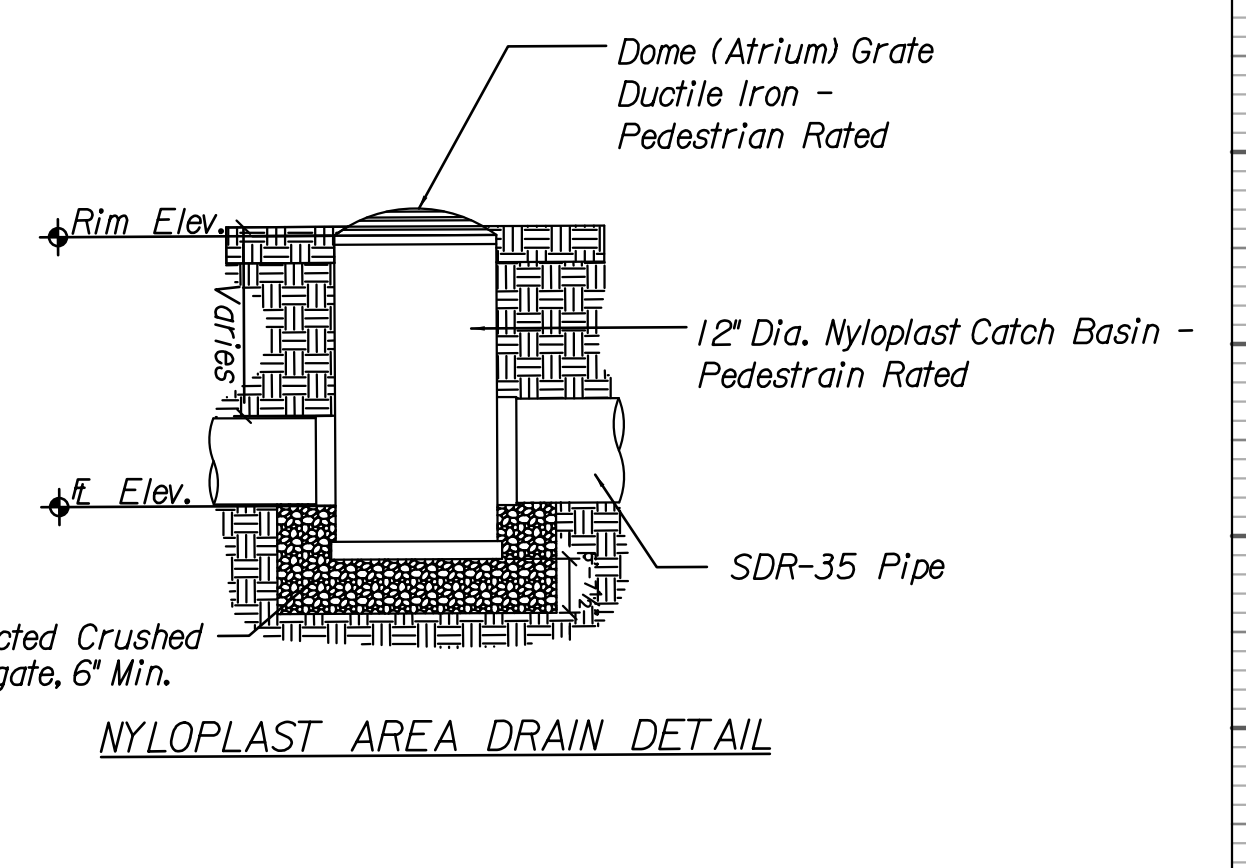

**Tran Systems**  
 245 NORTH WACO  
 SUITE 222  
 WICHITA, KANSAS 67202  
 PHONE: 316-303-3000  
 FAX: 316-462-5629

**CONSULTANTS:**  
  
 LK ARCHITECTURE, INC.  
 345 RIVERVIEW  
 SUITE 200  
 WICHITA, KANSAS 67208  
 PHONE: 316-268-0230

**DELANO GREENWAY IMPROVEMENTS FROM EXPOSITION TO OSAGE**  
 WICHITA, KANSAS

REVISIONS:	MARK	DATE	DESCRIPTION

PROJ NO: 472-85462  
 SCALE: 1"=20'  
 DATE: 11/1/2022  
 DESIGNED BY: MCG  
 DRAWN BY: DJB  
 CHECKED BY: MDB

**SHEET TITLE:**  
 DELANO GREENWAY  
 PLAN & PROFILE  
 EXPOSITION TO  
 OSAGE

SHEET NO. 9  
 SHEET 9 OF 96

CADconform Certify This File

danawano 11/1/2022 8:51:56 AM - c:\transtransystems\paw\lanawar\0675143c-rdw\00-101.dgn