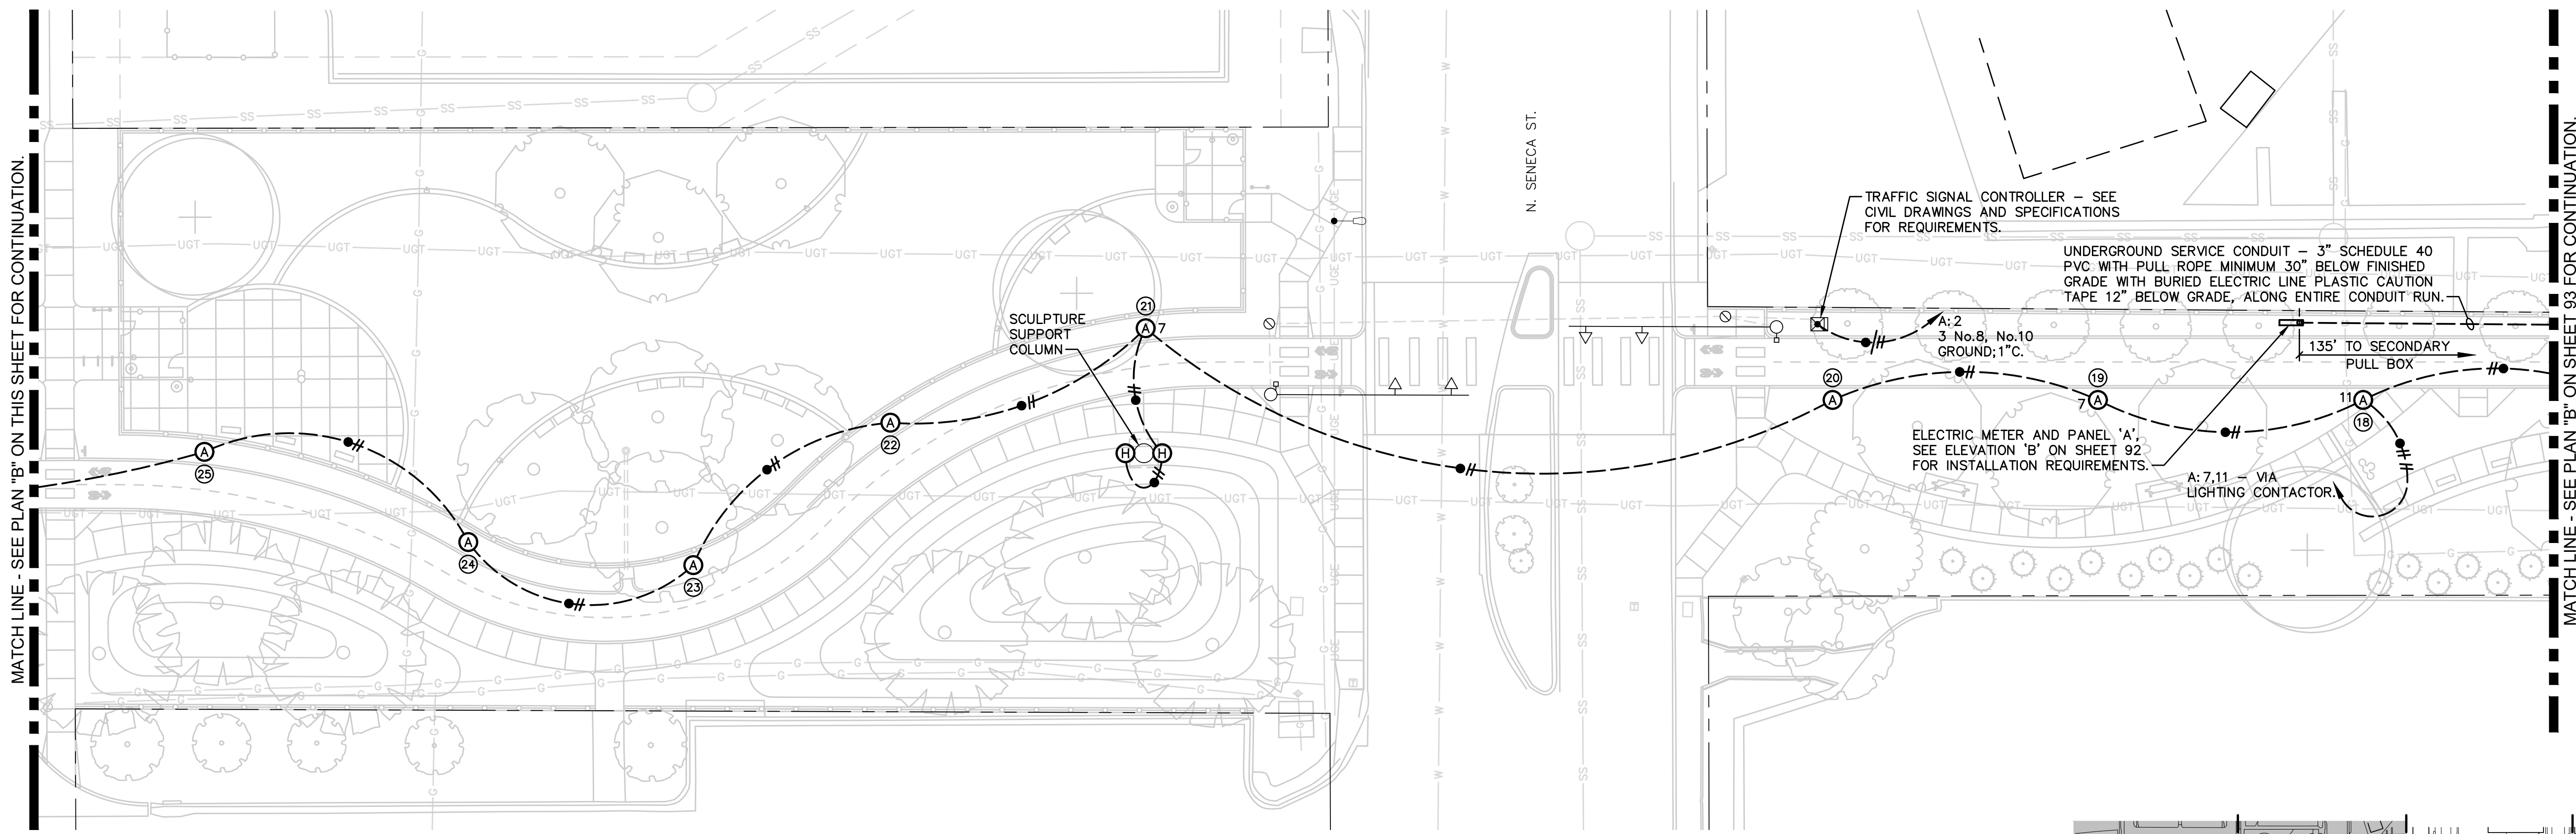


REVISIONS:	MARK	DATE	DESCRIPTION

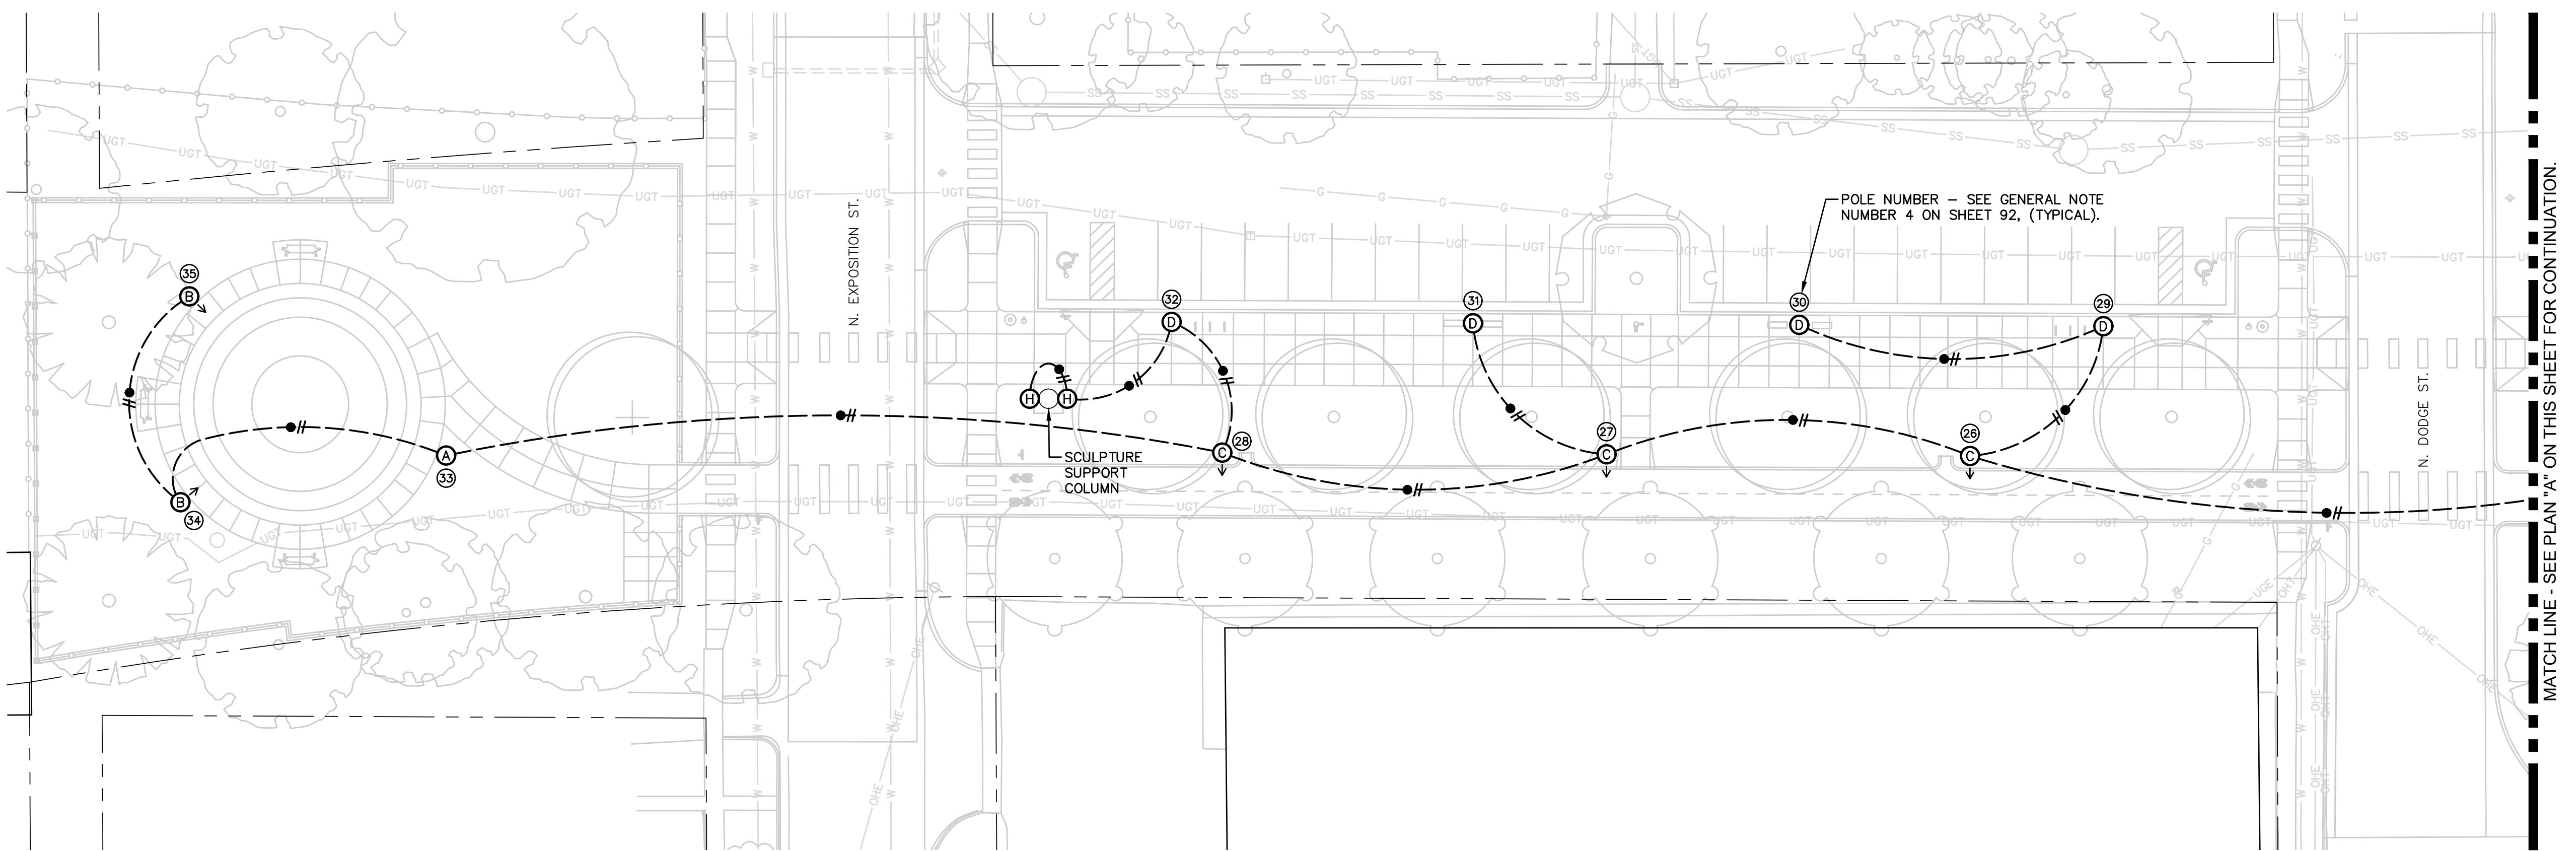
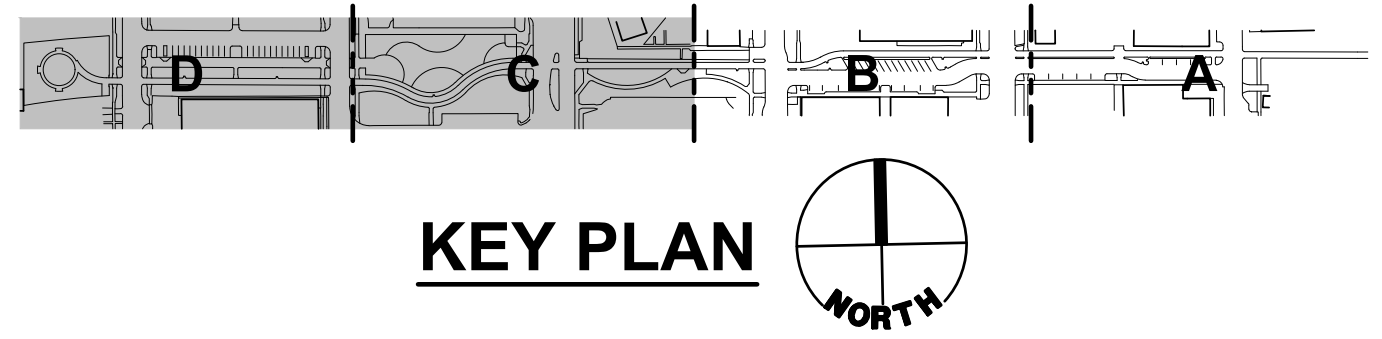
PROJ NO: 472-85463
 SCALE: 1" = 20'-0"
 DATE: 09/30/2022
 DESIGNED BY: S. Tucker
 DRAWN BY: S. Tucker
 CHECKED BY: .

SHEET TITLE:
 SITE ELECTRICAL PLANS - AREAS
 "C" & "D"

SHEET NO.
 94
 SHEET OF



A SITE ELECTRICAL PLAN - AREA "C"
 1" = 20'-0"
 0 10' 20' 40'

B SITE ELECTRICAL PLAN - AREA "D"
 1" = 20'-0"
 0 10' 20' 40'
