


REVISIONS:	MARK	DATE	DESCRIPTION

PROJ NO: 472-2021
SCALE: 1" = 20'-0"
DATE: 12/13/23
DESIGNED BY: S. Tucker
DRAWN BY: S. Tucker
CHECKED BY: .

SHEET TITLE:	
SITE LIGHTING PLAN - AREA "B"	
SHEET NO.	108
SHEET	108 OF 163

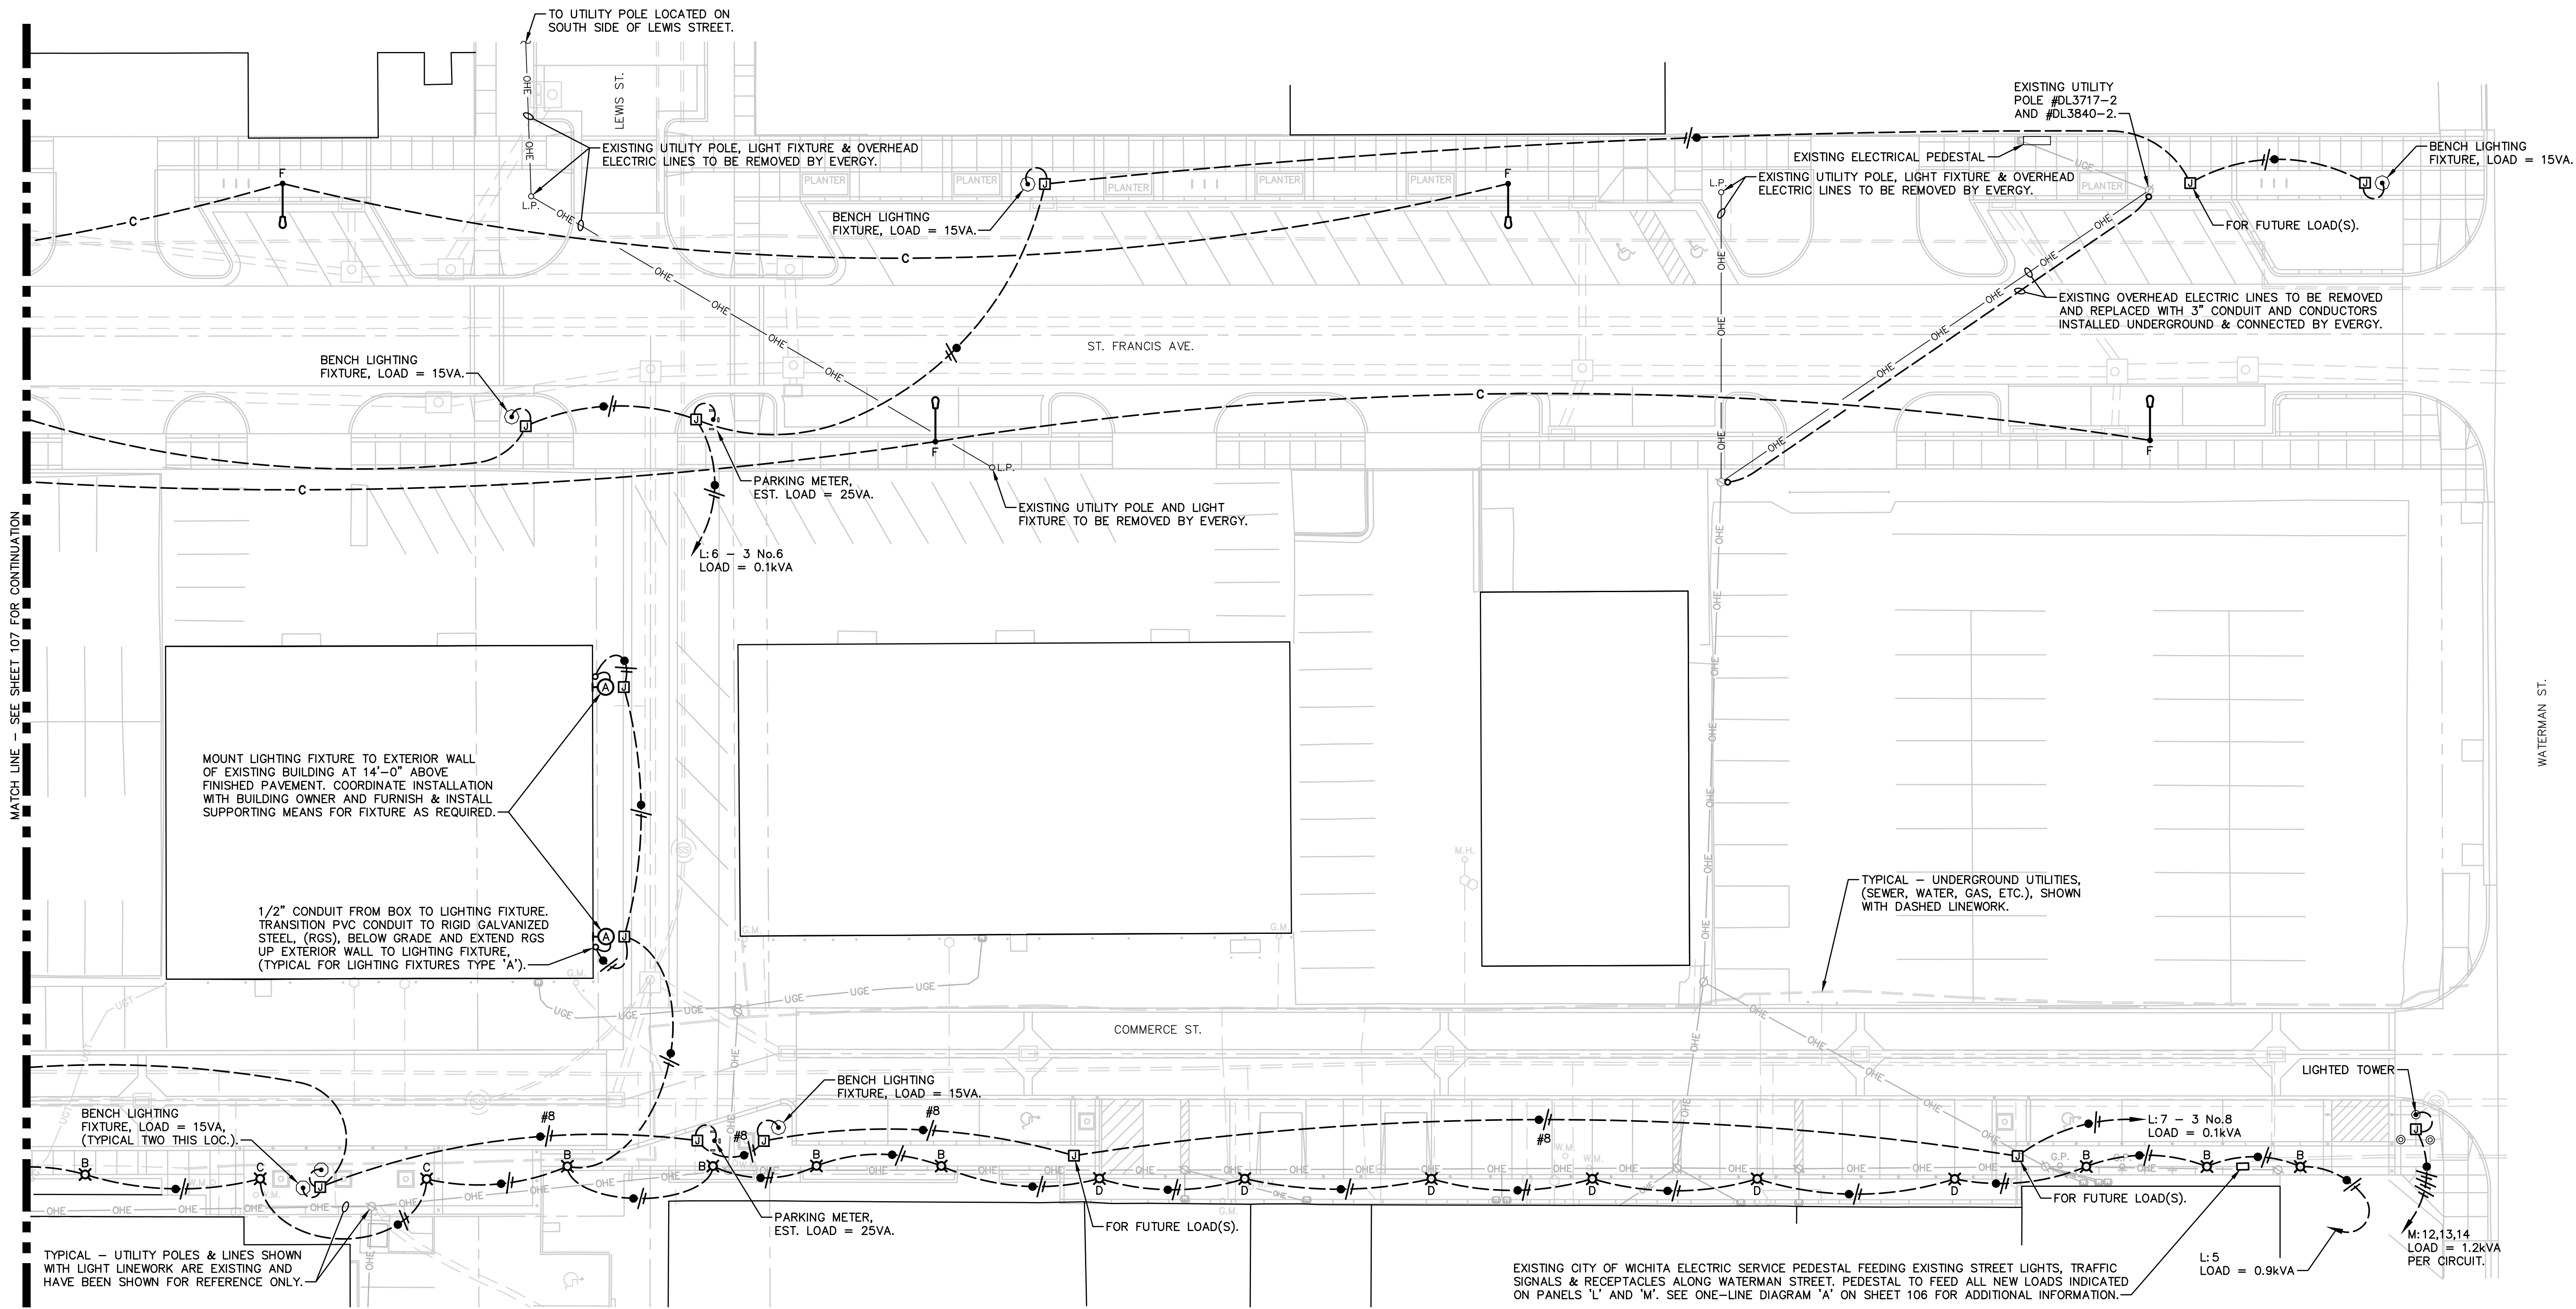

MATCH LINE - SEE SHEET 107 FOR CONTINUATION

A SITE LIGHTING PLAN - AREA "B"

1" = 20'-0"