



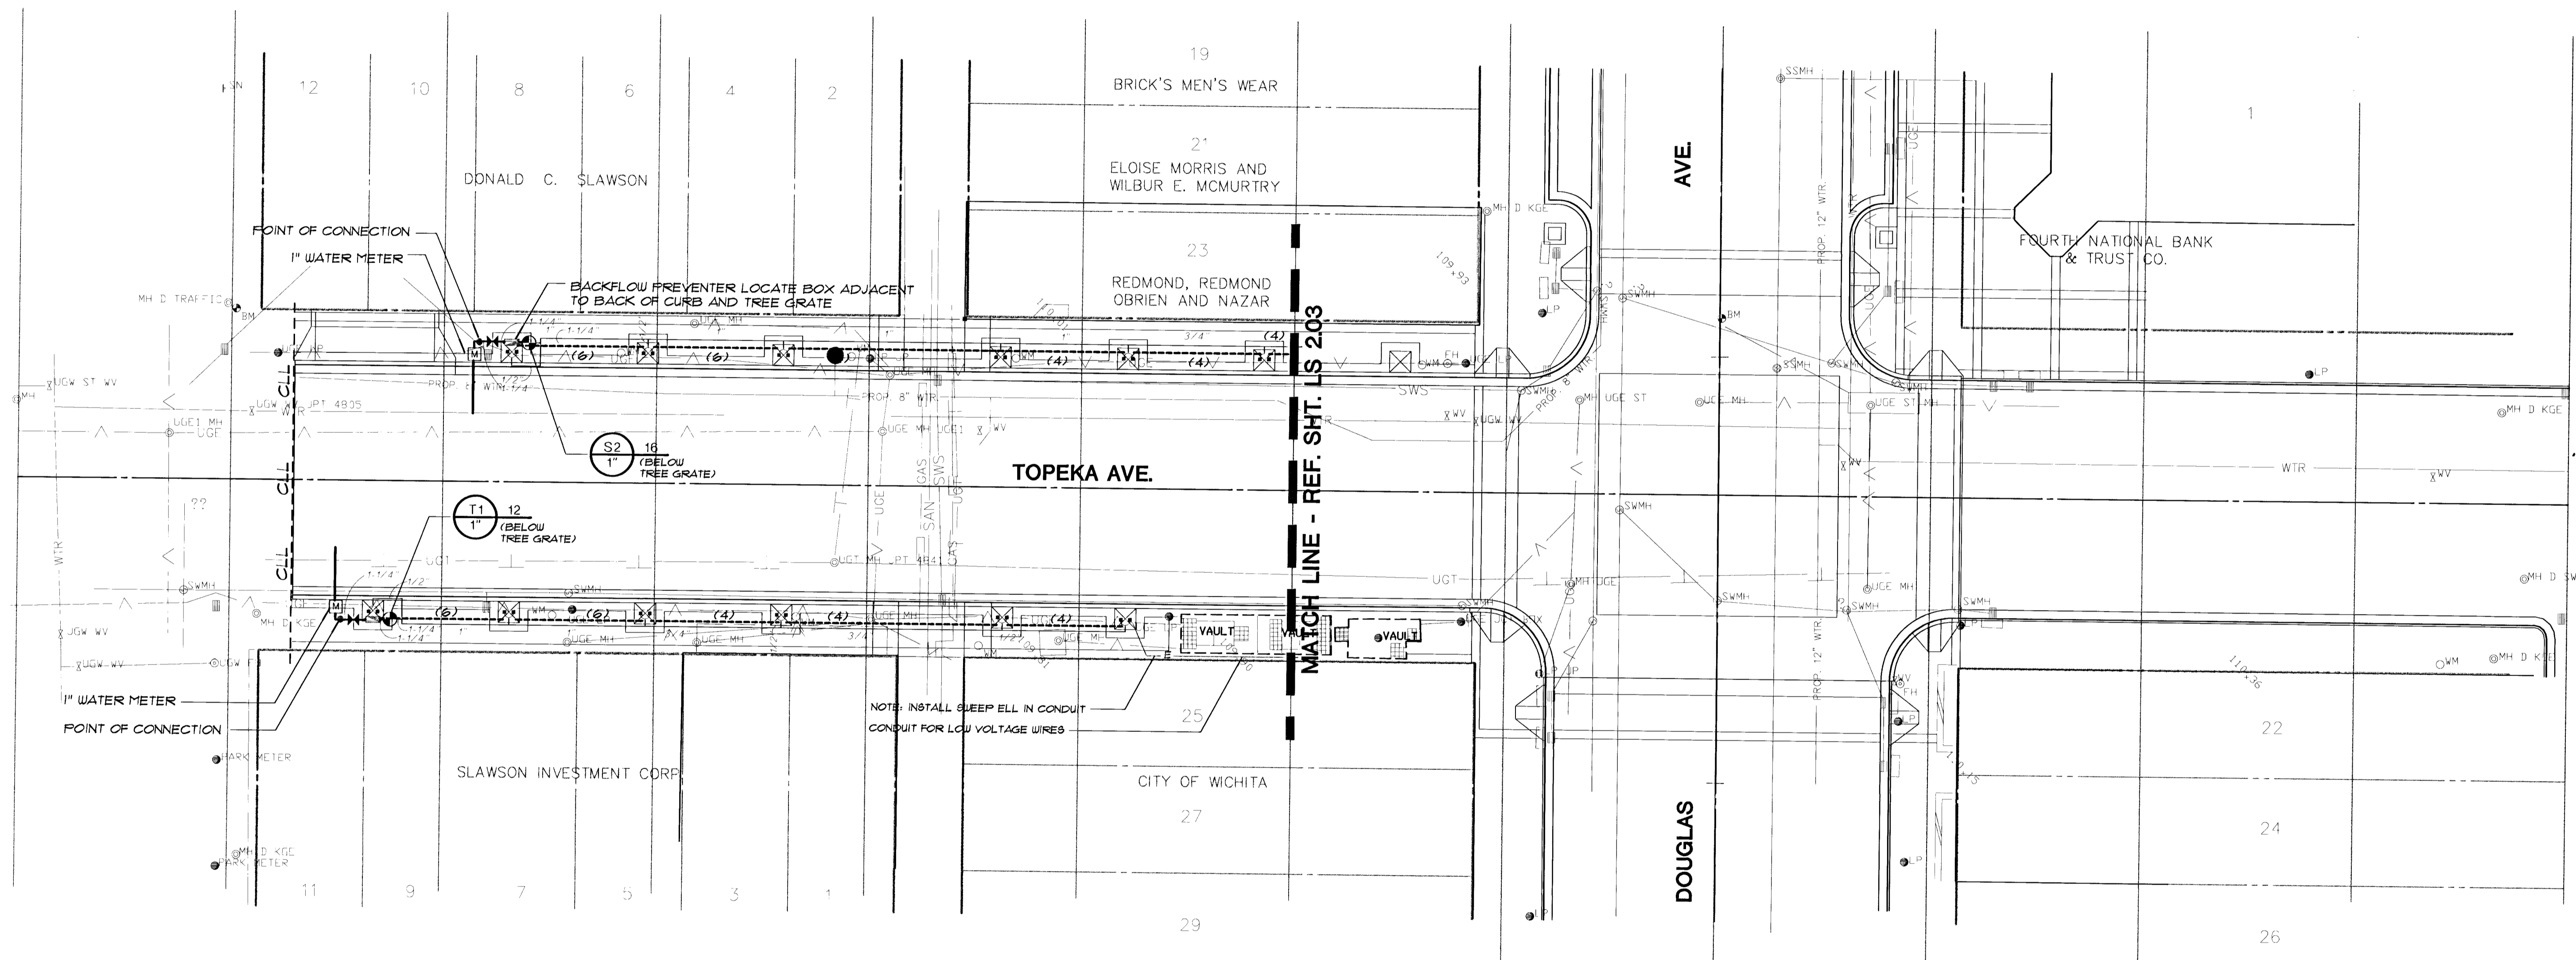

SCALE: 1"=20'

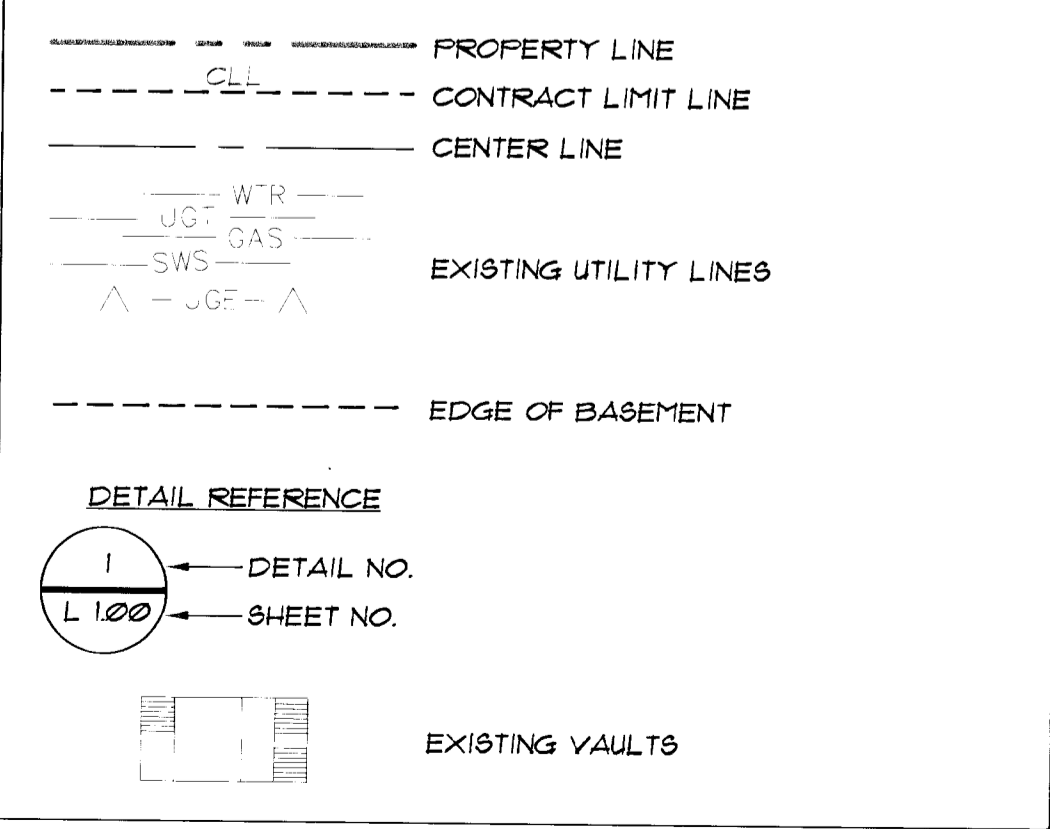

GENERAL LEGEND



the swa group

Landscape Architecture 2211 N. Lamar, Suite 400
 Site Planning Dallas, TX 75202
 Urban Design 214-954-0016

STREETSCAPES
 PROJECT NAME
IRRIGATION PLAN
TOPEKA AVE. @ 96+00 TO 102+00
 SHEET TITLE

MID-KANSAS ENGINEERING CONSULTANTS, INC.
 411 N. WEBB ROAD
 WICHITA, KS. 67206
 316-684-9600

DT DESIGN BY: EG DRAWN BY: JM CHECKED BY:
 OCT '95 DATE: SWA MKC-251 JOB NO. LS 204 SHEET OF

6: CIVIL.DWG\SWA\LS210-44.DWG Tue May 11 15:56:09 1999