


A LANDSCAPE PLAN NO. 2

0' 10' 20' 40'
1"=20.0'

LEGEND

- AREAS TO BE SODDED WITH A TURF-TYPE FESCUE BLEND
- NEW TREES
- POWER OUTLET SEE ELECTRICAL PLANS

- GENERAL NOTES:**
- SEE SHEET LP101 FOR DECIDUOUS TREE PLANTING DETAIL AND PLANT LIST.
 - REFERENCE THE CITY OF WICHITA STANDARD SPECIFICATIONS FOR LANDSCAPE AND IRRIGATION REQUIREMENTS.
 - REMOVE EXISTING SOIL IN MEDIANS TO A DEPTH OF 18" AND REPLACE WITH TOPSOIL. TOPSOIL SHALL BE APPROVED BY OWNER'S REPRESENTATIVE.

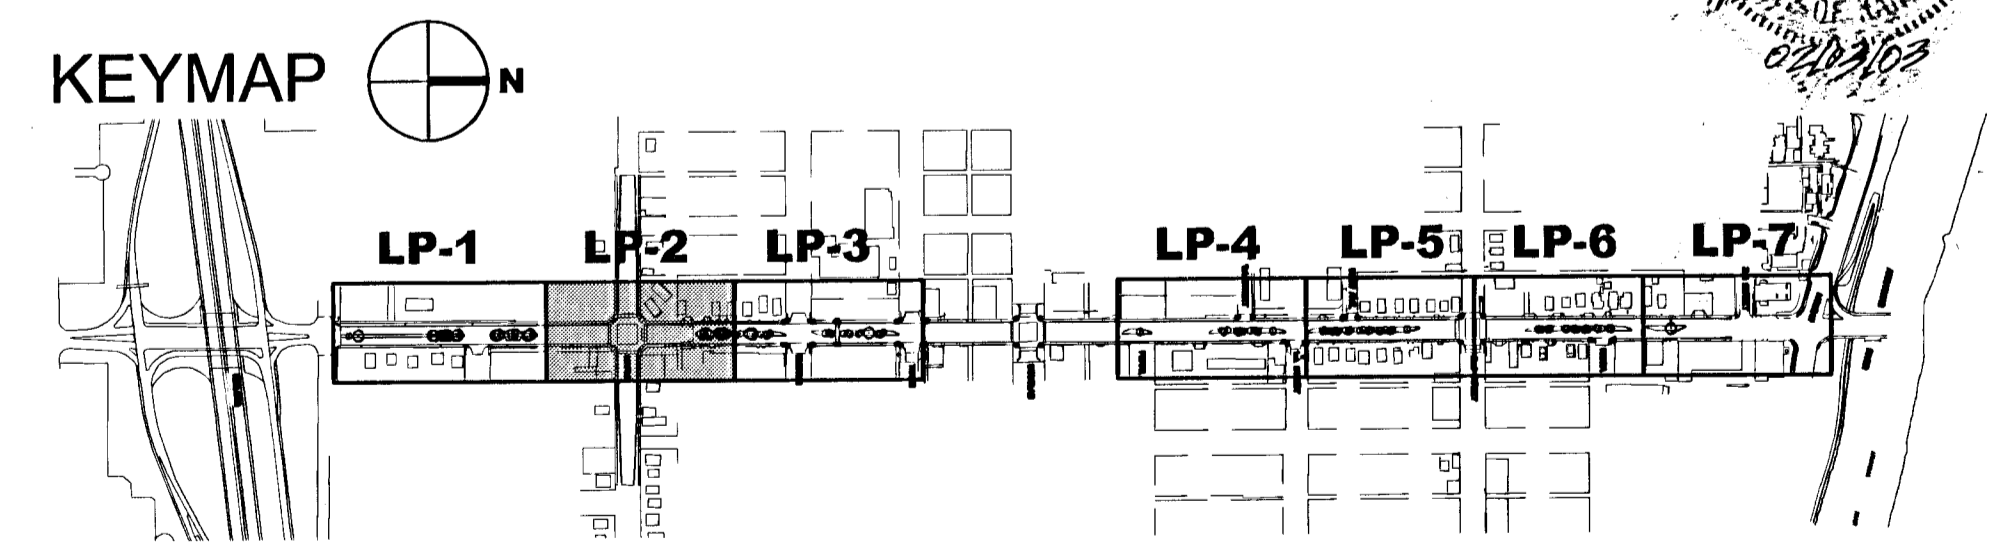

SENECA STREET
PROJECT NAME

LANDSCAPE PLAN NO. 2
SHEET TITLE

TDM DESIGN BY:	LES DRAWN BY:	TDM CHECKED BY:
02/03/03 DATE	LP102 DRAWING NAME	LP2/7 SHEET / OF

411 N. WEBB ROAD
WICHITA, KS. 67206
316-684-9600