


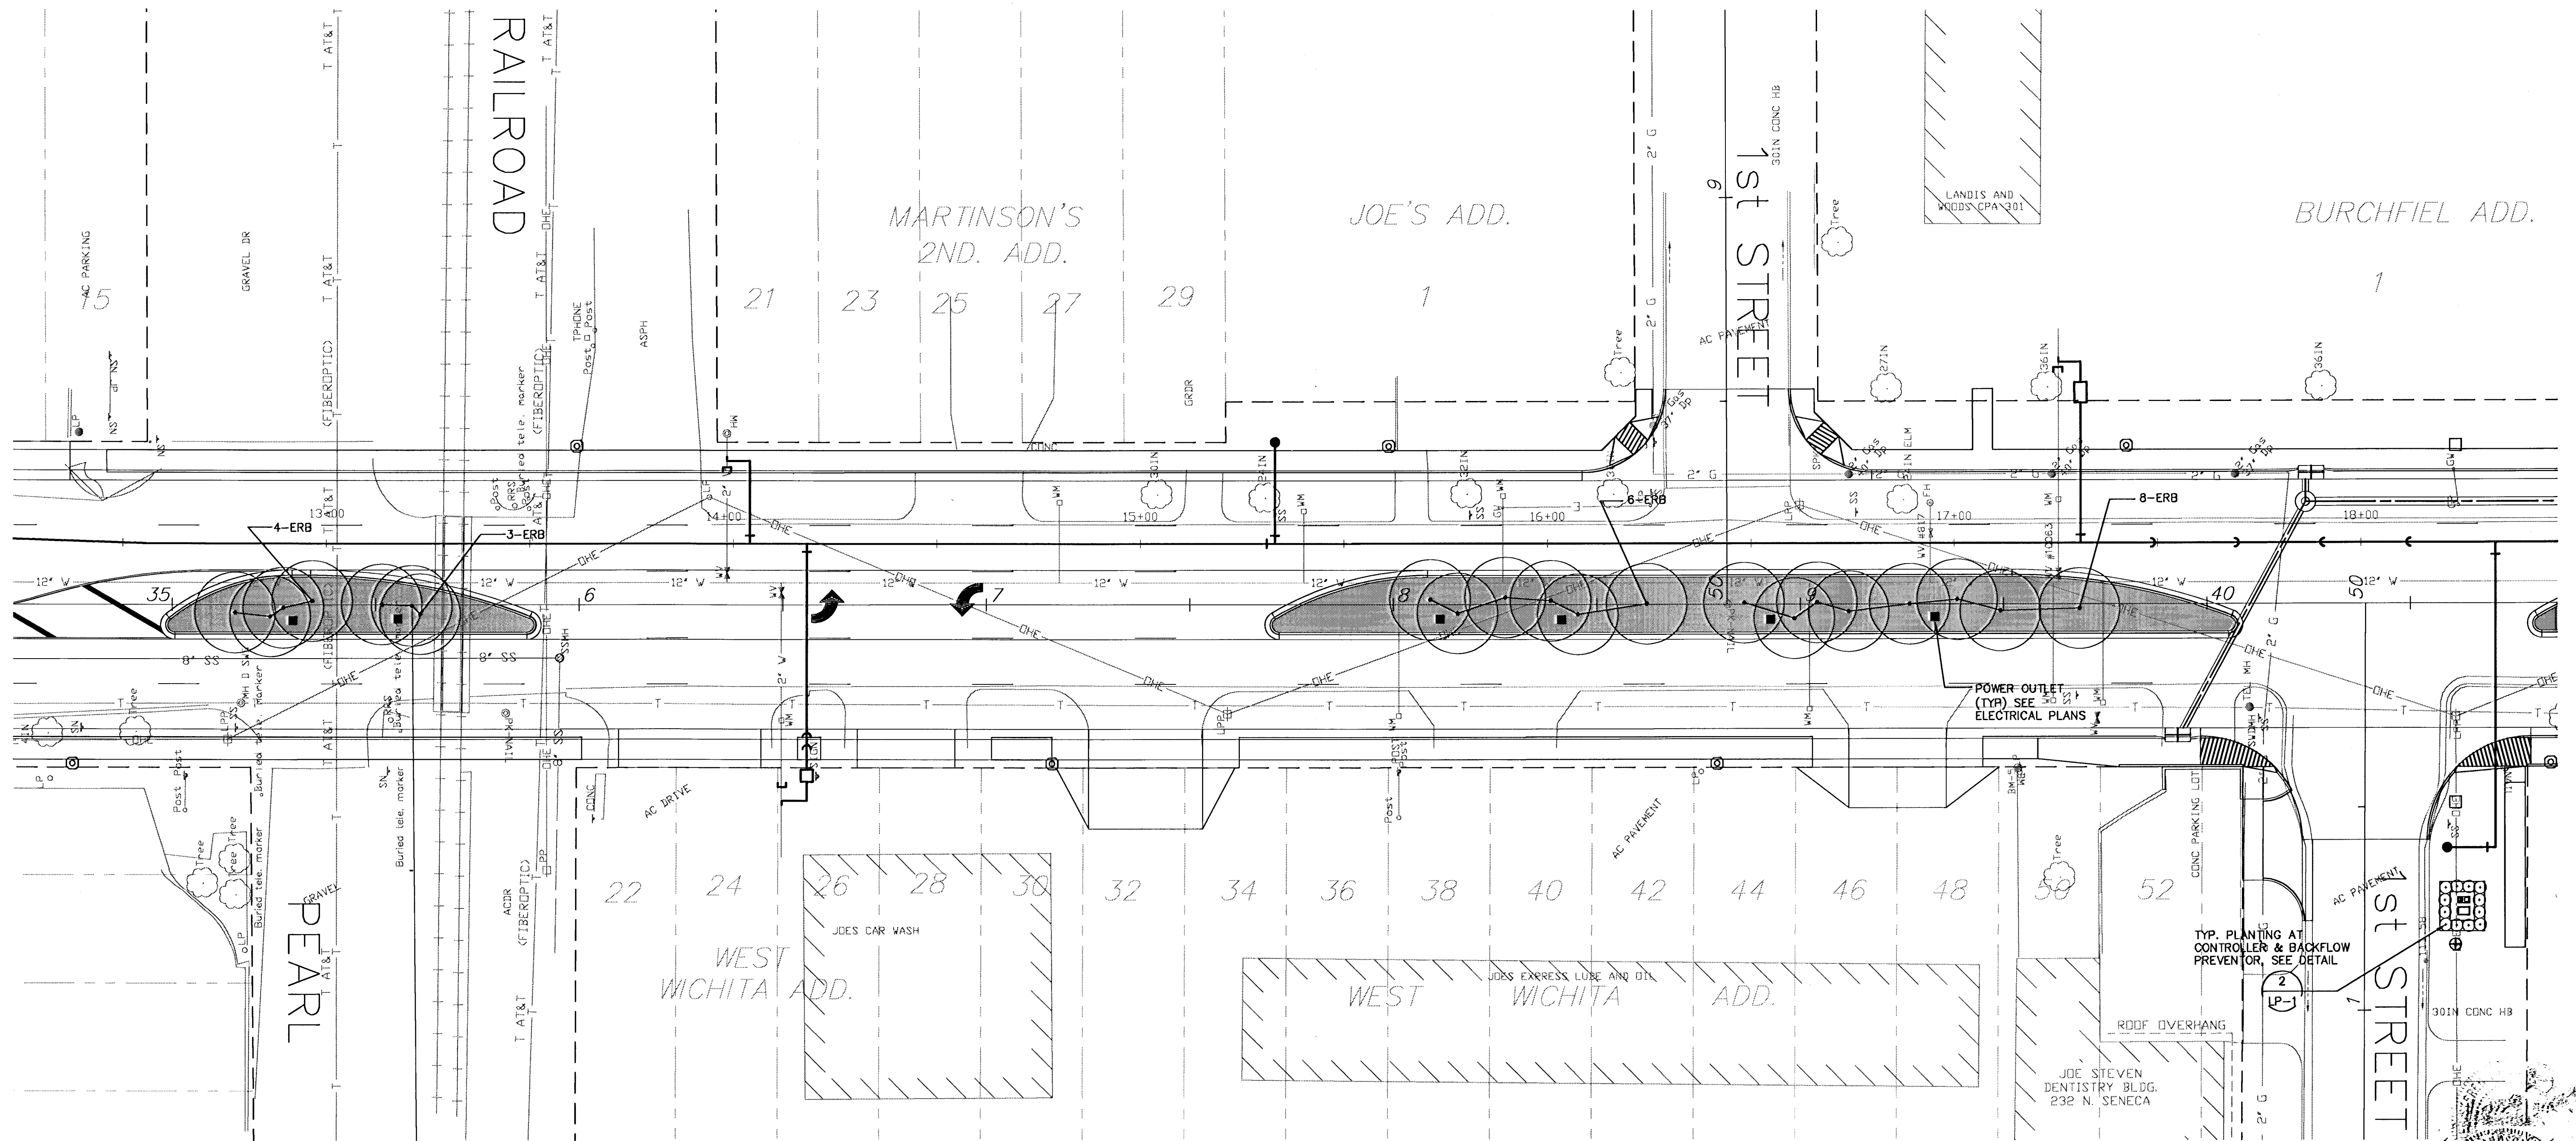

A LANDSCAPE PLAN NO. 4

0' 10' 20' 40' 1"=20.0'


LEGEND

AREAS TO BE SODDED WITH A TURF-TYPE FESCUE BLEND

NEW TREES

POWER OUTLET SEE ELECTRICAL PLANS

- GENERAL NOTES:
1. SEE SHEET LP101 FOR DECIDUOUS TREE PLANTING DETAIL AND PLANT LIST.
 2. REFERENCE THE CITY OF WICHITA STANDARD SPECIFICATIONS FOR LANDSCAPE AND IRRIGATION REQUIREMENTS.
 3. REMOVE EXISTING SOIL IN MEDIANS TO A DEPTH OF 18" AND REPLACE WITH TOPSOIL. TOPSOIL SHALL BE APPROVED BY OWNER'S REPRESENTATIVE.

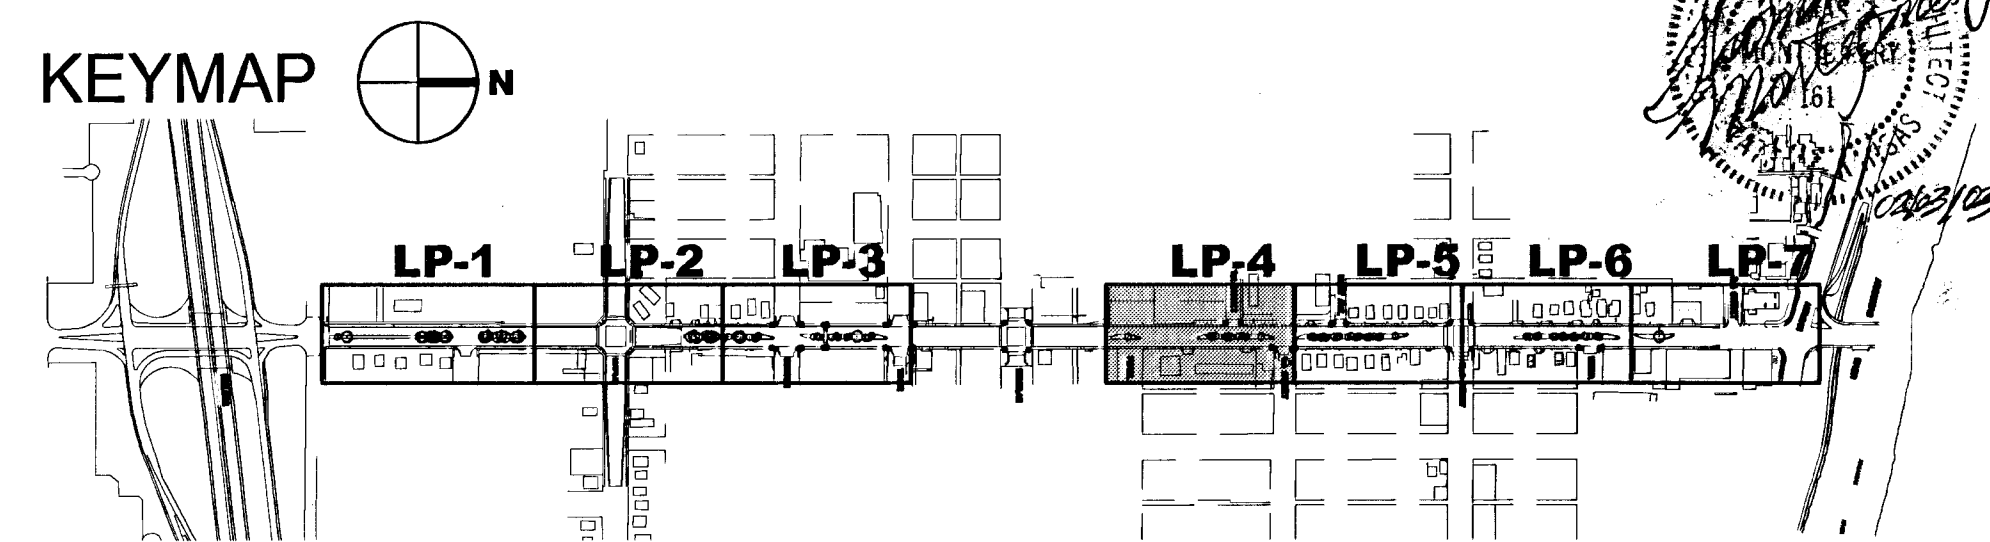

MKEC

ENGINEERING CONSULTANTS

411 N. WEBB ROAD
WICHITA, KS. 67208
316-684-9600

SENECA STREET

PROJECT NAME

LANDSCAPE PLAN NO. 4

SHEET TITLE

TDM	LES	TDM
DESIGN BY:	DRAWN BY:	CHECKED BY:
02/03/03	LP104	LP4 7
DATE	DRAWING NAME	SHEET / OF