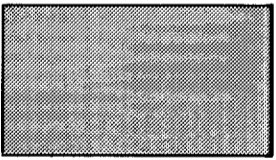

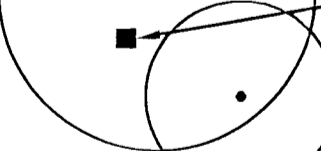



A LANDSCAPE PLAN NO. 6

0' 10' 20' 40'
1"=20.0'


LEGEND

-  AREAS TO BE SODDED WITH A TURF-TYPE FESCUE BLEND
-  NEW TREES
-  POWER OUTLET SEE ELECTRICAL PLANS

KEYMAP

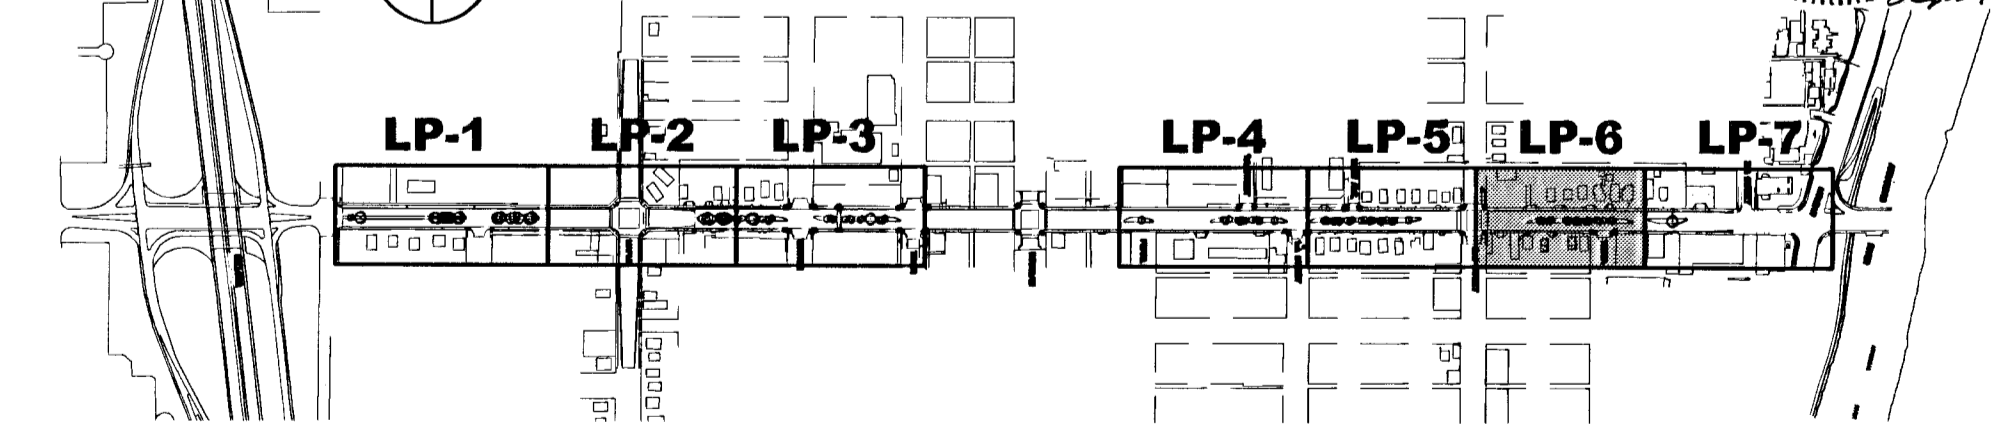

- GENERAL NOTES:**
1. SEE SHEET LP101 FOR DECIDUOUS TREE PLANTING DETAIL AND PLANT LIST.
 2. REFERENCE THE CITY OF WICHITA STANDARD SPECIFICATIONS FOR LANDSCAPE AND IRRIGATION REQUIREMENTS.
 3. REMOVE EXISTING SOIL IN MEDIANS TO A DEPTH OF 18" AND REPLACE WITH TOPSOIL. TOPSOIL SHALL BE APPROVED BY OWNER'S REPRESENTATIVE.

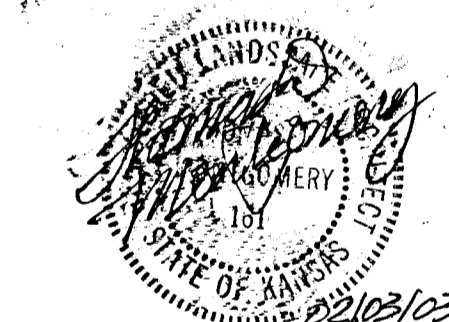

MKEC
ENGINEERING CONSULTANTS
411 N. WEBB ROAD
WICHITA, KS. 67206
316-684-9600

SENECA STREET
PROJECT NAME

LANDSCAPE PLAN NO. 6
SHEET TITLE

DESIGN BY: **LES**
DATE: **02/03/03**

CHECKED BY: **TDM**
DRAWING NAME: **LP106 LP6 7**
SHEET 1 OF