


A LANDSCAPE PLAN NO. 7

LEGEND

- AREAS TO BE SODDED WITH A TURF-TYPE FESCUE BLEND
- NEW TREES
- POWER OUTLET SEE ELECTRICAL PLANS

- GENERAL NOTES:**
1. SEE SHEET LP101 FOR DECIDUOUS TREE PLANTING DETAIL AND PLANT LIST.
 2. REFERENCE THE CITY OF WICHITA STANDARD SPECIFICATIONS FOR LANDSCAPE AND IRRIGATION REQUIREMENTS.
 3. REMOVE EXISTING SOIL IN MEDIANS TO A DEPTH OF 18" AND REPLACE WITH TOPSOIL. TOPSOIL SHALL BE APPROVED BY OWNER'S REPRESENTATIVE.

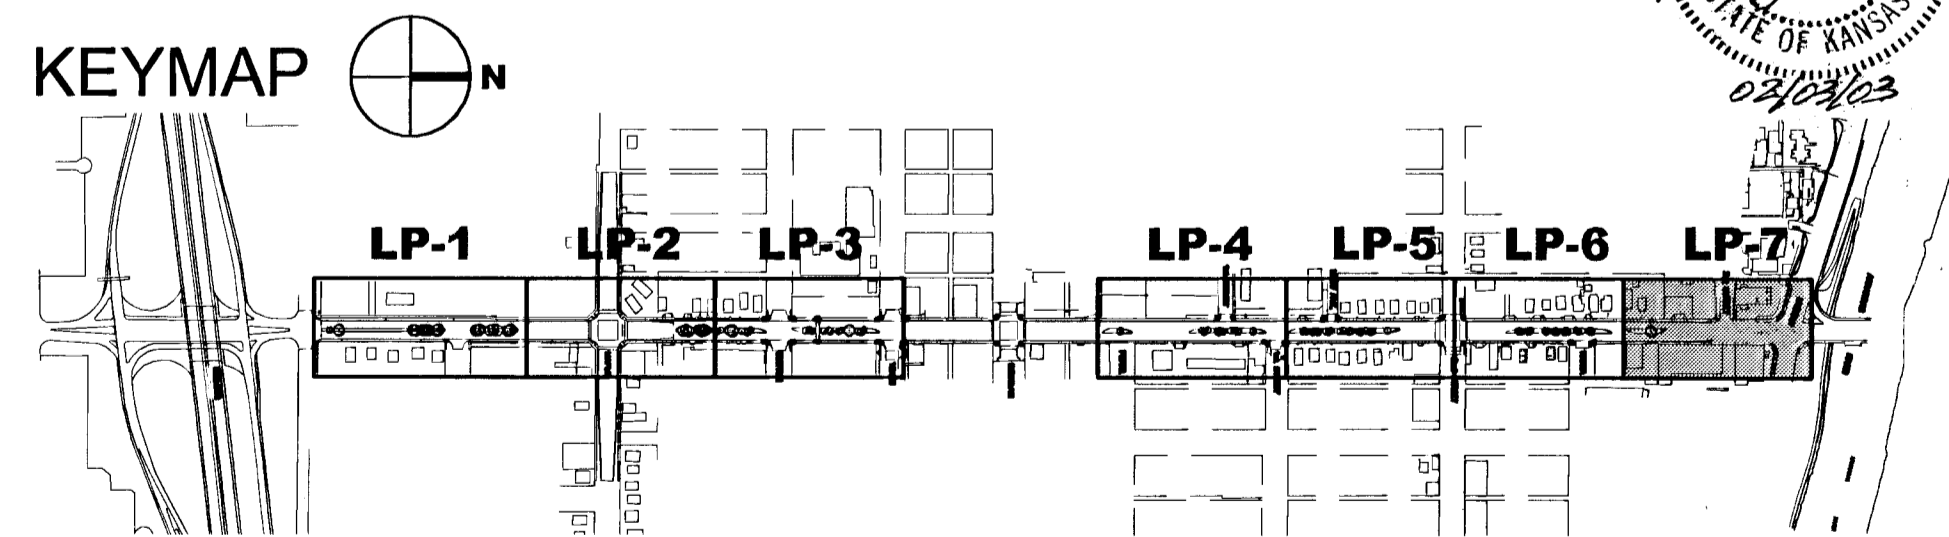

MKEC ENGINEERING CONSULTANTS 411 N. WEBB ROAD WICHITA, KS. 67208 316-684-9600	SENECA STREET	
	PROJECT NAME	
	LANDSCAPE PLAN NO. 7	
	SHEET TITLE	
TDM	LES	TDM
DESIGN BY:	DRAWN BY:	CHECKED BY:
02/03/03	LP107	LP7.7
DATE	DRAWING NAME	SHEET / OF