


STAKEOUT

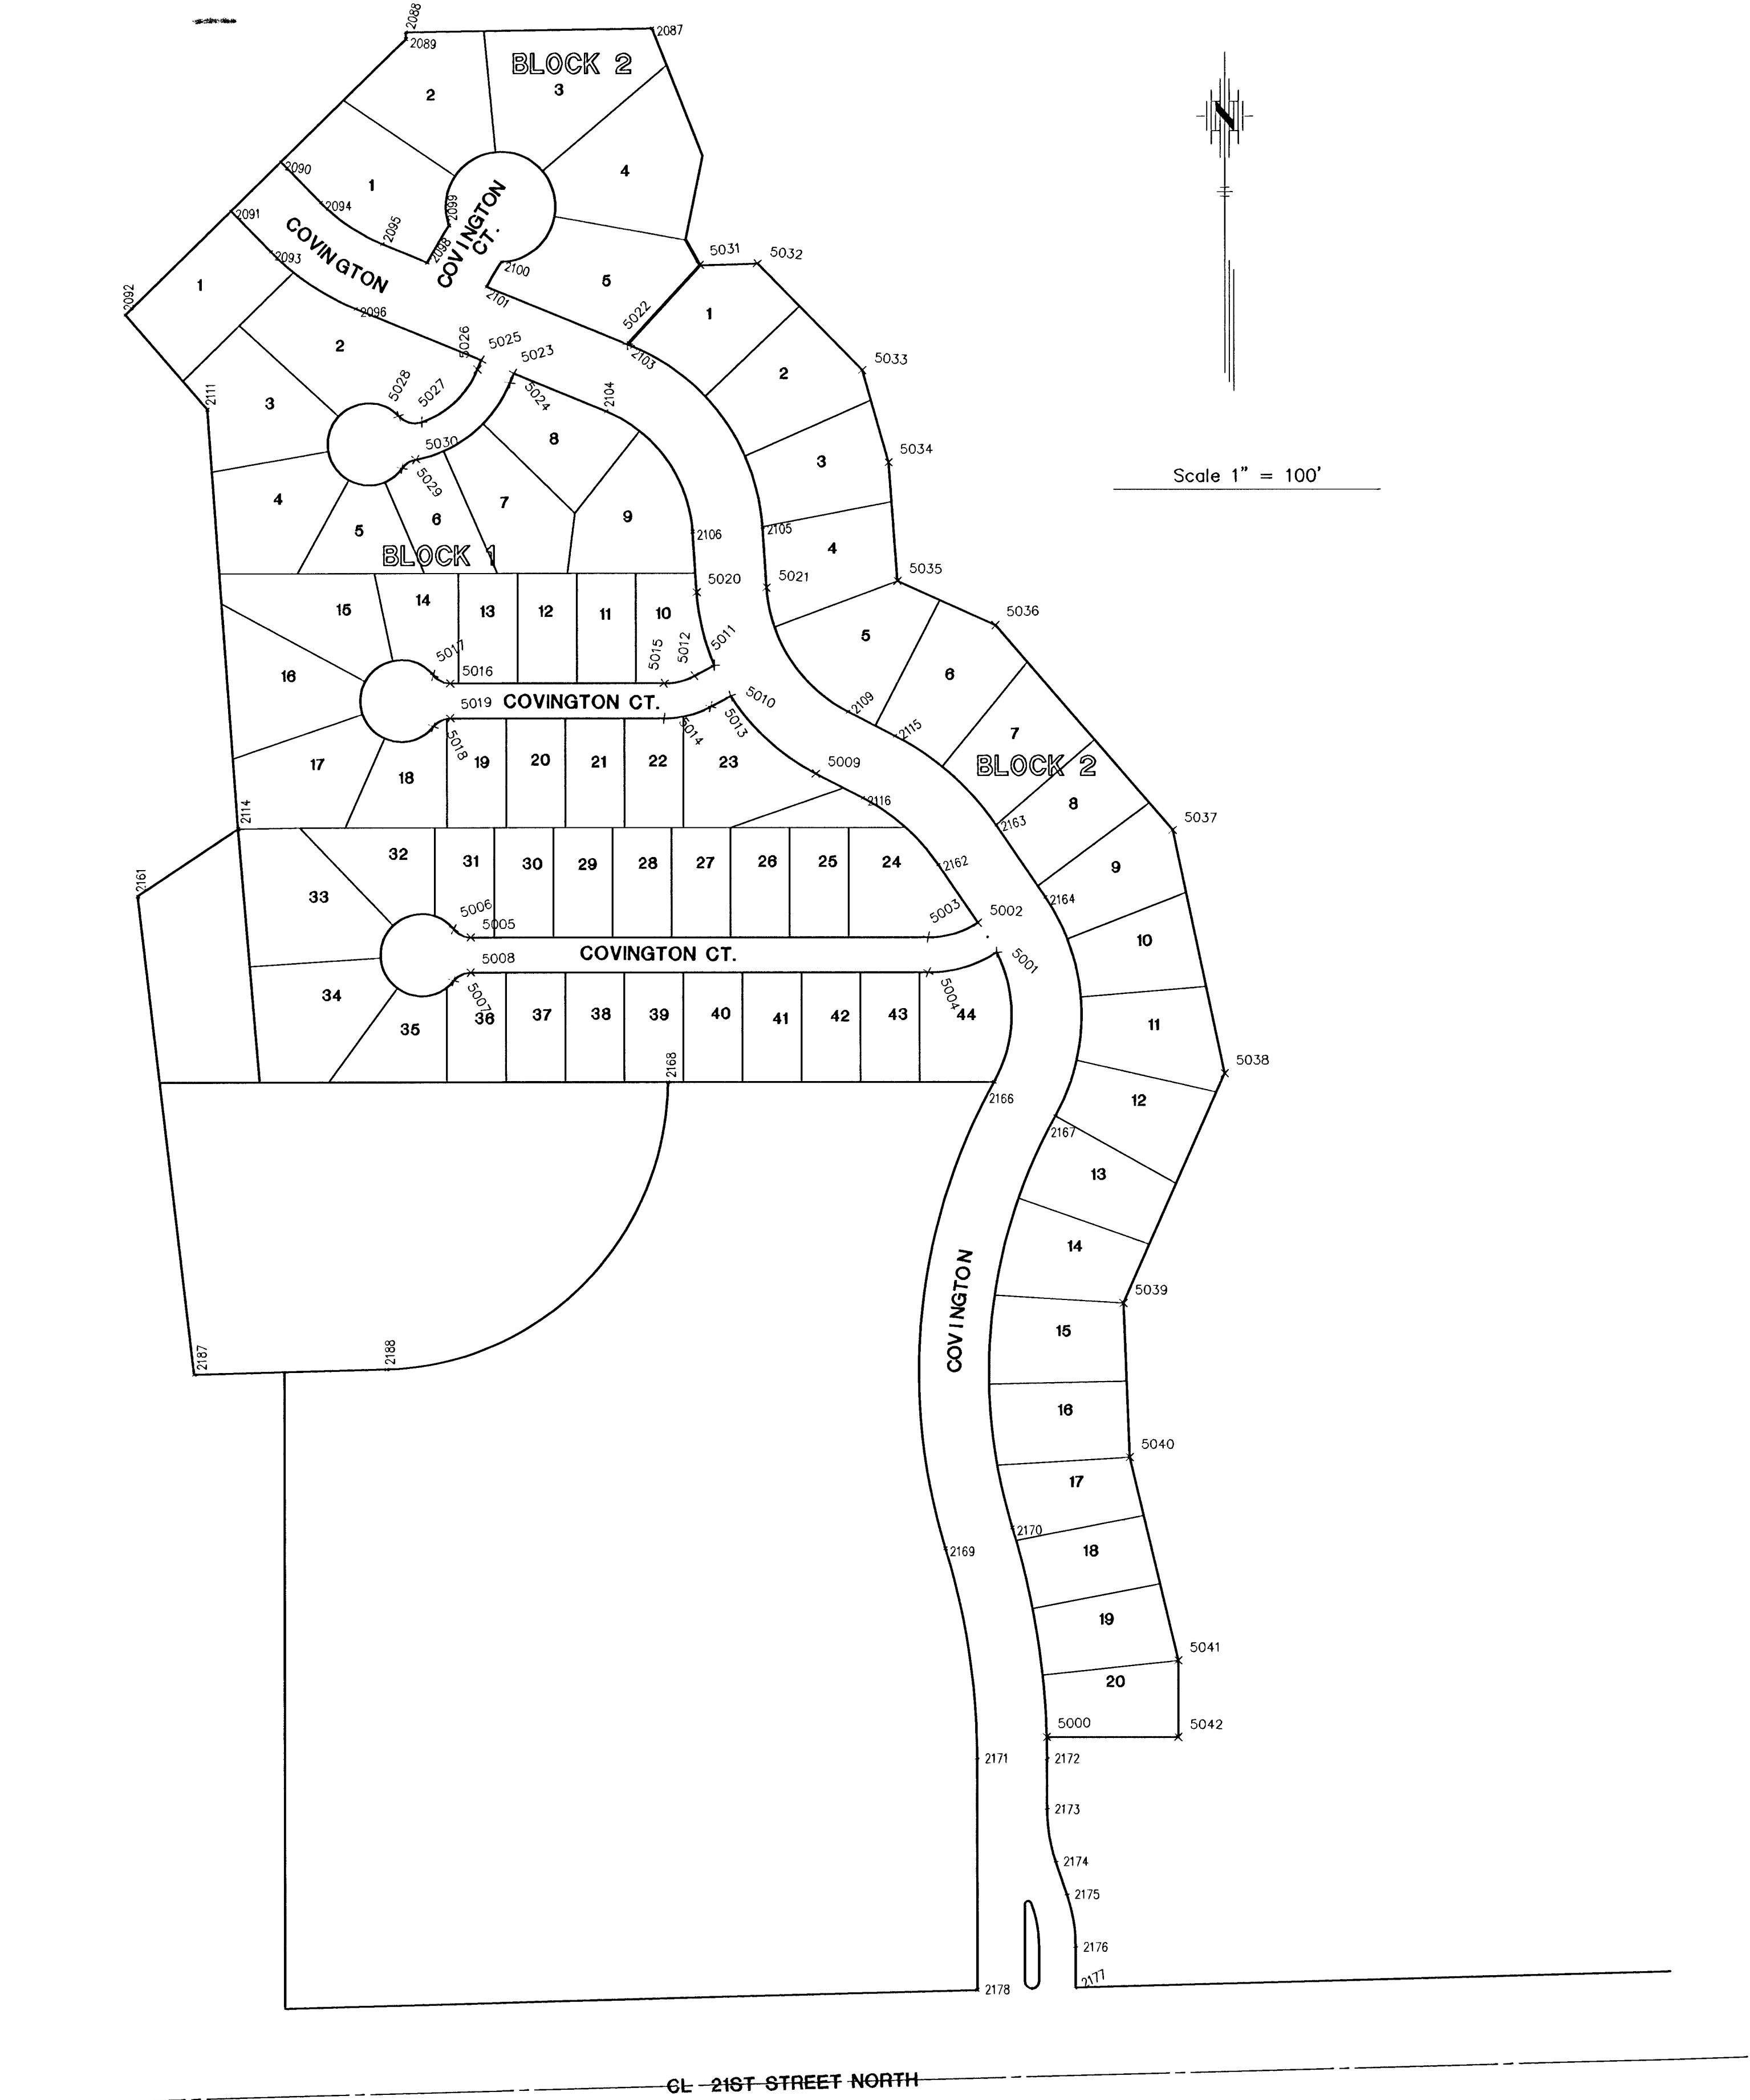

POINT	NORTHING	EASTING
5000	7731.291	12126.334
5001	8447.435	12081.175
5002	8474.435	12064.000
5003	8461.221	12018.768
5004	8429.221	12018.766
5005	8461.254	11600.613
5006	8468.733	11585.018
5007	8421.777	11585.015
5008	8429.254	11600.610
5009	8610.257	11916.108
5010	8681.435	11838.267
5011	8709.720	11823.302
5012	8700.090	11805.099
5013	8671.805	11829.064
5014	8661.240	11777.500
5015	8693.240	11777.502
5016	8693.255	11582.199
5017	8700.735	11566.605
5018	8653.778	11566.601
5019	8661.255	11582.197
5020	8776.028	11807.239
5021	8780.375	11871.091
5022	9002.114	11744.056
5023	8975.590	11640.314
5024	8967.173	11636.756
5025	8987.752	11610.615
5026	8979.335	11607.157
5027	8931.602	11556.118
5028	8936.896	11535.173
5029	8889.285	11538.190
5030	8897.226	11550.729
5031	9074.471	11810.379
5032	9078.065	11863.050
5033	8978.821	11958.817
5034	8894.331	11982.759
5035	8785.196	11950.879
5036	8746.043	12080.386
5037	8558.920	12242.229
5038	8336.976	12289.519
5039	8127.499	12196.794
5040	7986.715	12202.461
5041	7801.426	12246.612
5042	7731.281	12246.607
2161	8499.432	11296.176
2162	8527.203	12027.912
2163	8563.332	12080.740
2164	8491.656	12125.656
2165	8461.527	12072.828
2166	8329.217	12078.847
2167	8298.034	12134.737
2168	8329.240	11780.557
2169	7903.754	12033.772
2170	7922.534	12094.954
2171	7711.505	12062.605
2172	7711.500	12126.605
2173	7665.519	12126.601
2174	7617.447	12134.509
2175	7587.366	12144.684
2176	7539.294	12152.592
2177	7502.858	12152.589
2178	7500.505	12062.589
2114	8560.445	11387.945
2115	8644.996	11988.334
2116	8588.127	11958.975
2103	9000.189	11748.743
2104	8940.991	11724.420
2105	8835.637	11867.329
2106	8831.290	11803.477
2098	9077.176	11561.375
2101	9054.992	11615.366
2090	9169.122	11427.652
2091	9124.353	11381.917
2092	9029.842	11285.366
2093	9087.182	11418.303
2094	9131.551	11464.038
2095	9094.076	11520.244
2096	9034.879	11495.920
2111	8943.193	11360.097
2112	8811.137	11495.091
2113	8813.763	11533.076
2114	8560.445	11387.945
2187	8063.000	11347.331
2188	8067.607	11523.467

FINAL

Engineer: J. Ubert
Drawn By: B. Kulla
Poe Job No.: 1656B
Date: May 2001

POE & ASSOCIATES OF KANSAS, INC.
CONSULTING ENGINEERS
5940 E. Central, Suite 200 ■ Wichita, KS 67208-4242
Phone 316/685-4114 ■ FAX 316/685-4444

THE LOCKS AT ABERDEEN
STREET IMPROVEMENTS
COORDINATE POINTS LIST
CITY OF WICHITA, KANSAS
MICHAEL E. UNDEBAK, P.E. - CITY ENGINEER
Proj.# 472-83359 O.C.A.# 765881

No. Date By Approved Revision

1
2
3
4